


# SYCAMORE STADIUM RIGHT FIELD DECK

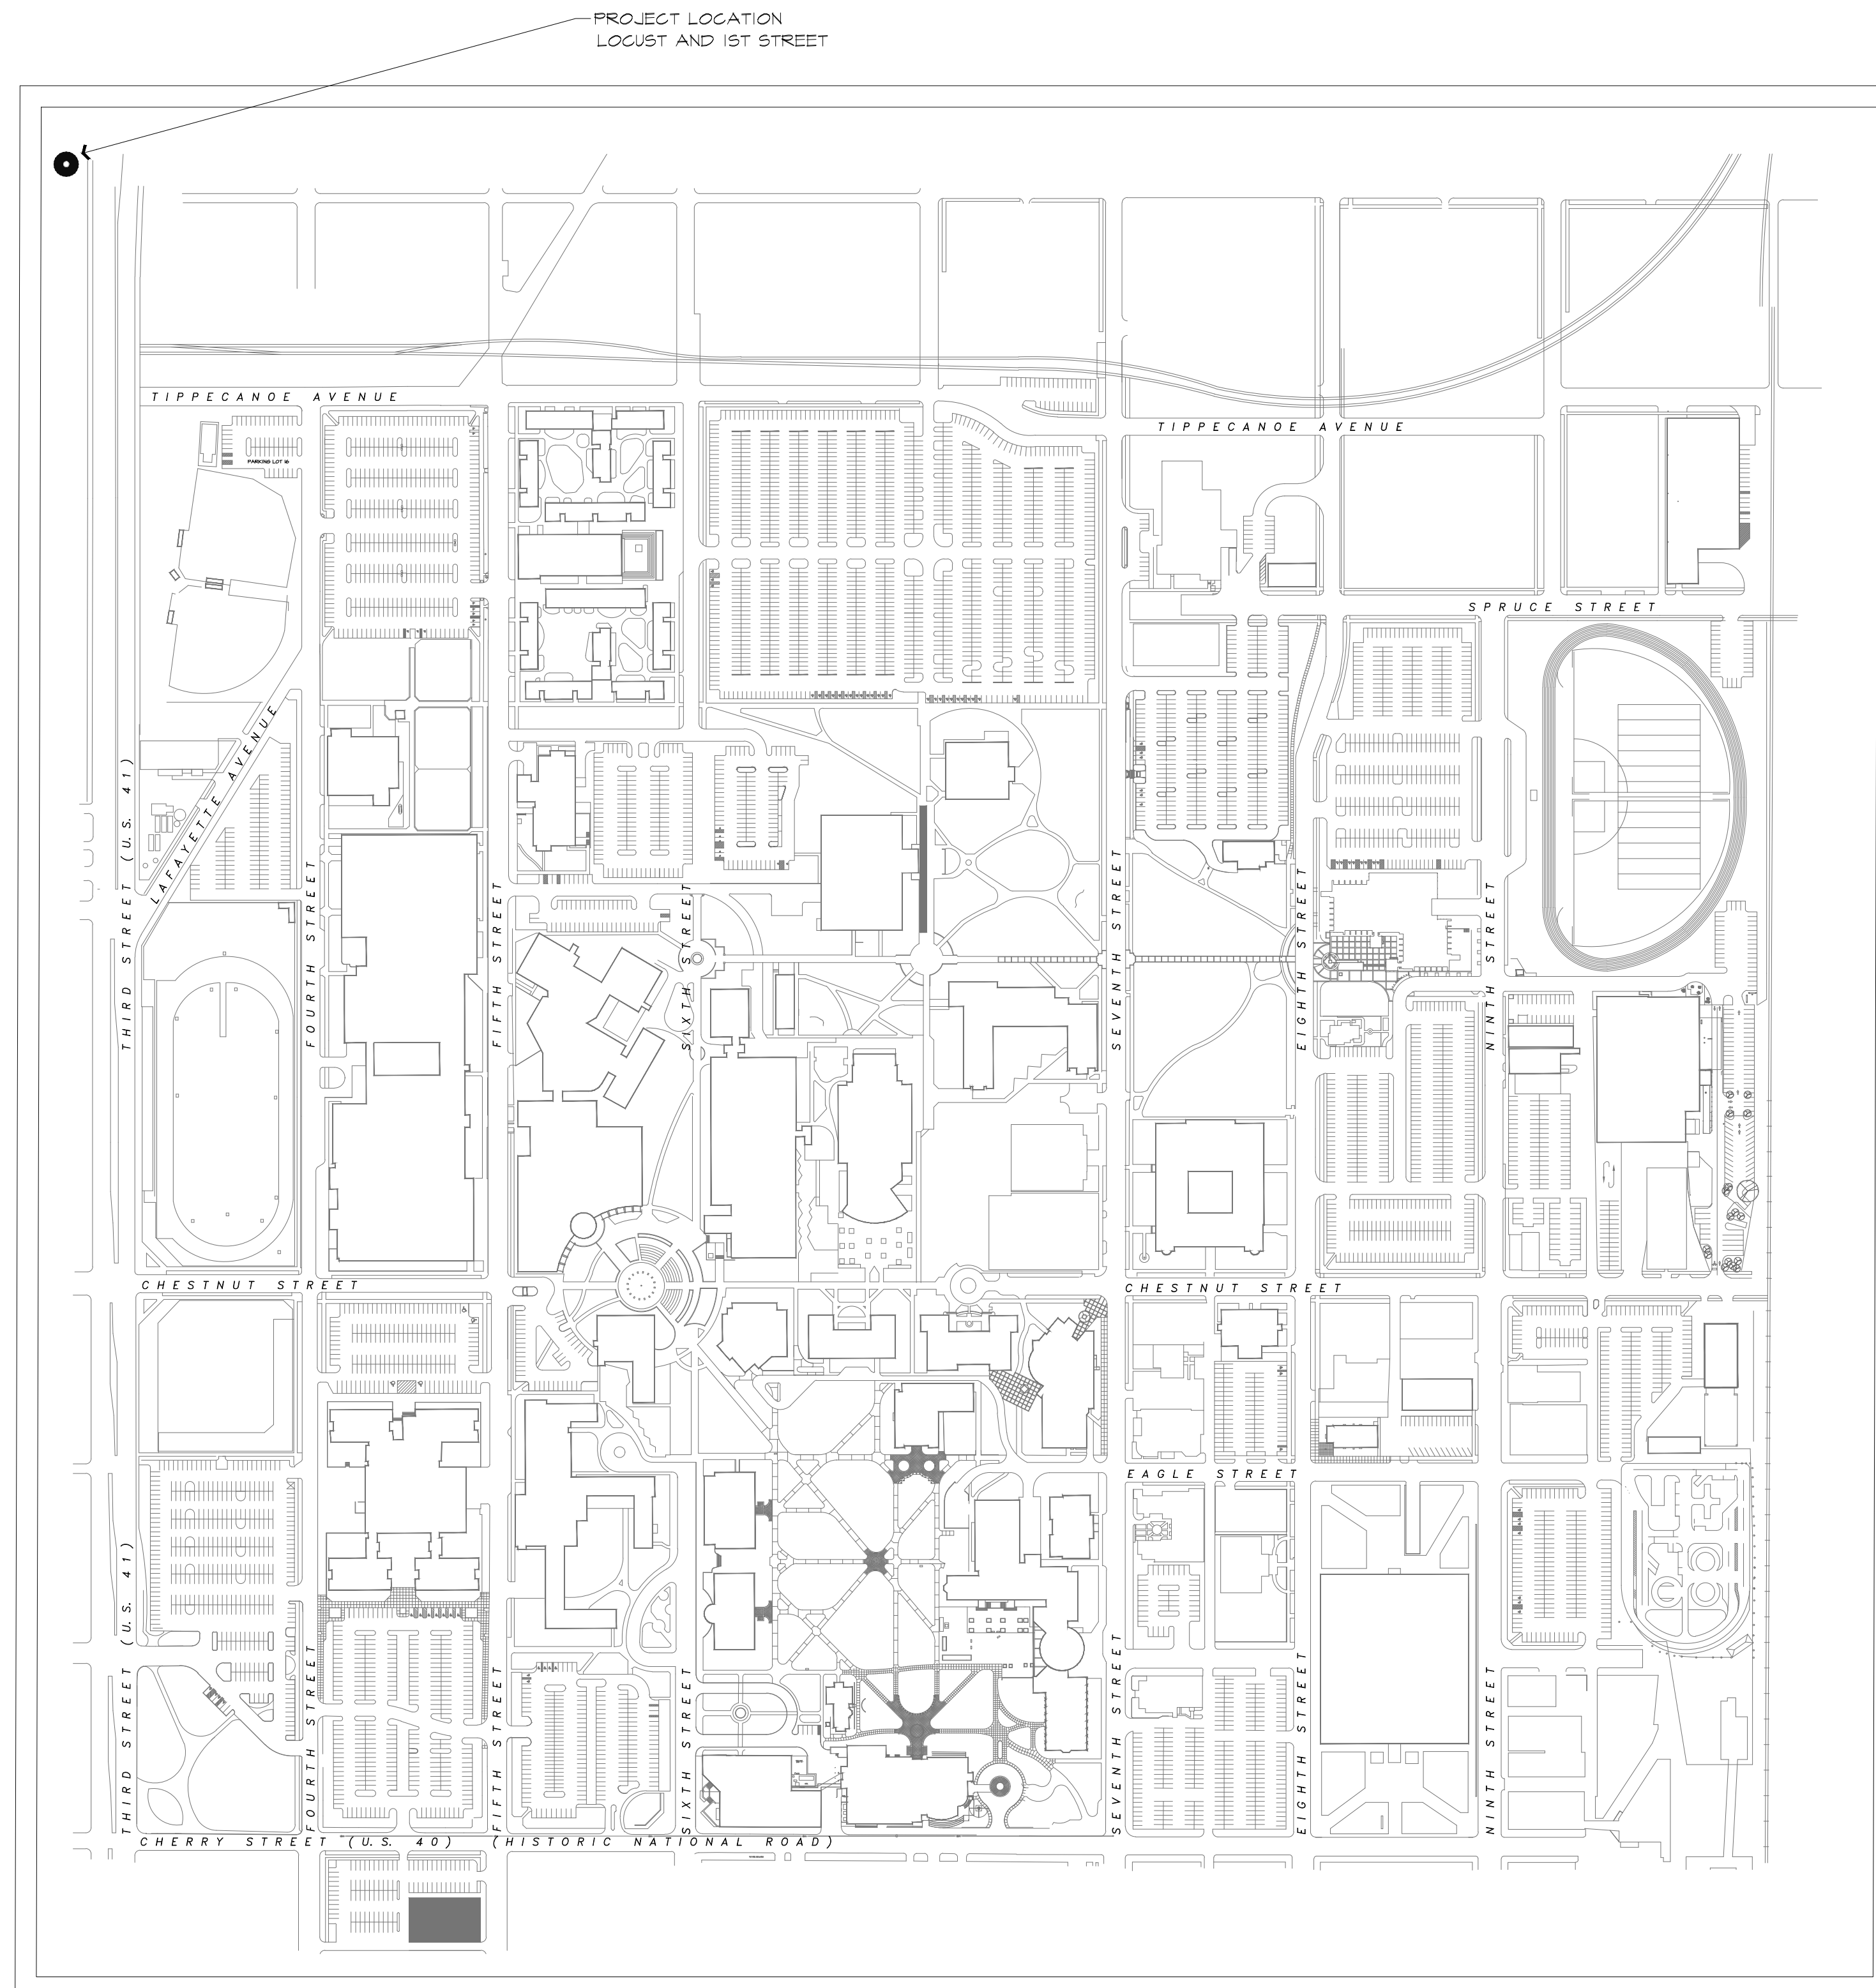

PROJECT LOCATION MAP

## DRAWING INDEX

### CIVIL

CD100 SITE DEMOLITION PLAN  
C101 SITE PLAN

### ELECTRICAL

E101 STORAGE ELECTRICAL PLAN  
E102 DECK ELECTRICAL PLAN

### DEMOLITION

### MECHANICAL


### ARCHITECTURAL

A100 FOUNDATION PLAN  
A101 GROUND FLOOR PLAN  
A102 FLOOR PLAN  
A200 ELEVATIONS  
A201 ELEVATIONS  
A300 BUILDING SECTION

### PLUMBING


### FIRE PROTECTION

INDIANA STATE UNIVERSITY

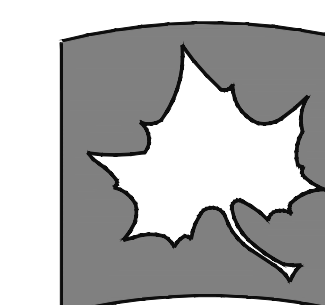

Facilities Management  
951 Sycamore Street  
Terre Haute, IN 47809  
phone: (812) 237-8100 fax: (812) 237-7630

DATE: 5/28/2025 PROJ. NO.: B0028514

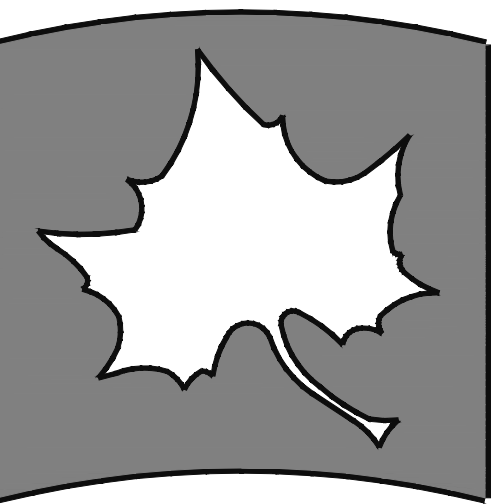

Facilities Management Department  
951 Sycamore Street  
Terre Haute, Indiana 47809  
Phone: (812) 237-8100 Fax: (812) 237-7630


# SITE DEMOLITION PLAN

|               |  |             |
|---------------|--|-------------|
| FILENAME:     |  |             |
| PROPERTY NO.: |  |             |
| REVISIONS     |  |             |
| 1             |  |             |
| 2             |  |             |
| DATE:         |  | 5/12/2025   |
| SCALE:        |  | 1/32"=1'-0" |
| DRAWN BY:     |  | S.TILLMAN   |
| CHECKED BY:   |  | B.DUNCAN    |
| APPROVED BY:  |  |             |
| PROJECT NO.:  |  |             |


CD/00

SHEETS



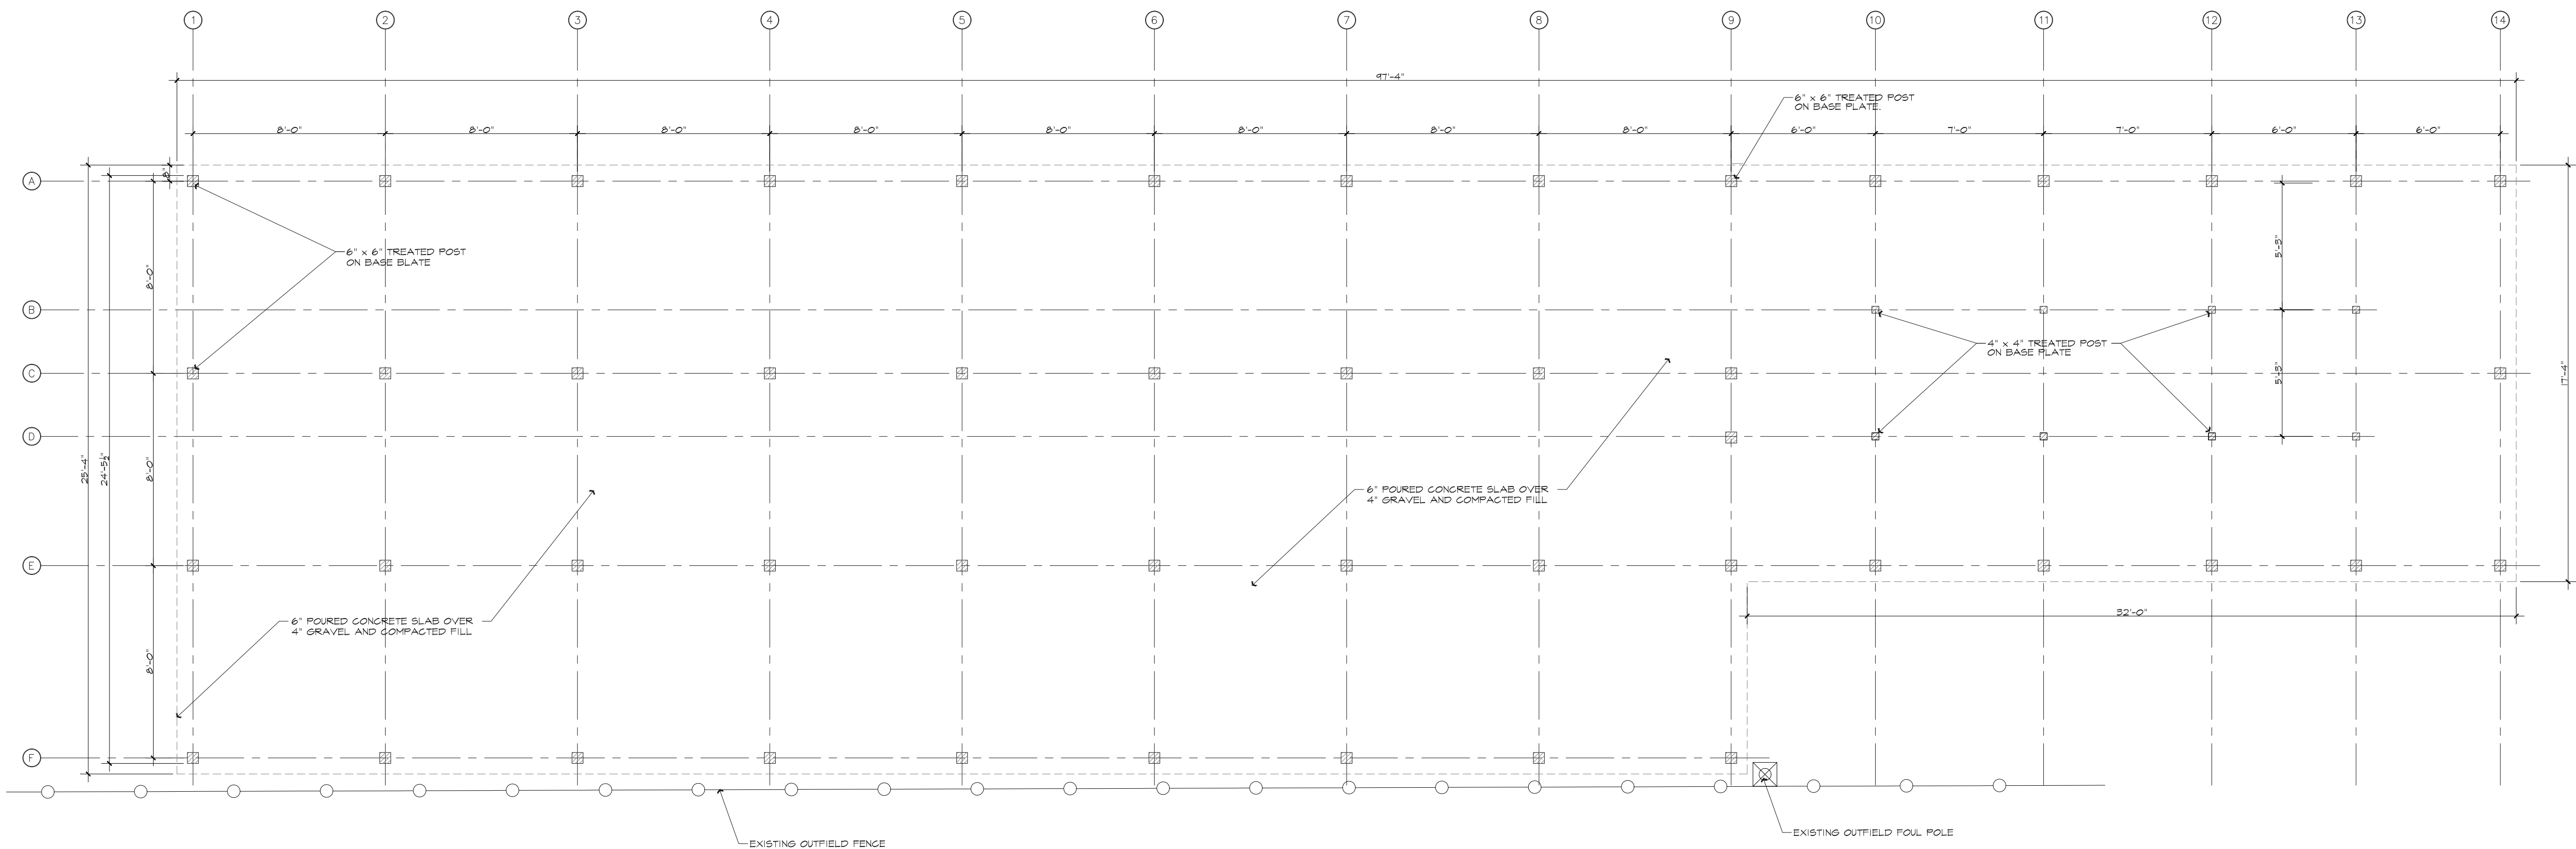

FOUNDATION PLAN  
SCALE: 1/4"=1'-0"

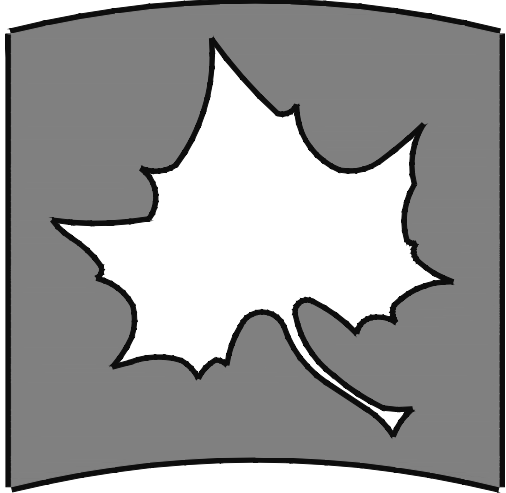

INDIANA STATE UNIVERSITY

Facilities Management Department  
951 Sycamore Street  
Terre Haute, Indiana 47809  
Phone: (812) 237-8100 Fax: (812) 237-7630

SYCAMORE STADIUM  
RIGHT FIELD DECK


FOUNDATION PLAN

|               |            |
|---------------|------------|
| FILENAME:     |            |
| PROPERTY NO.: |            |
| REVISIONS     |            |
| 1             |            |
| 2             |            |
| DATE:         | 5/27/2025  |
| SCALE:        | 1/4"=1'-0" |
| DRAWN BY:     | S.TILLMAN  |
| CHECKED BY:   | B.DUNCAN   |
| APPROVED BY:  |            |
| PROJECT NO.:  |            |

SHEET NO.:

A100

OF SHEETS

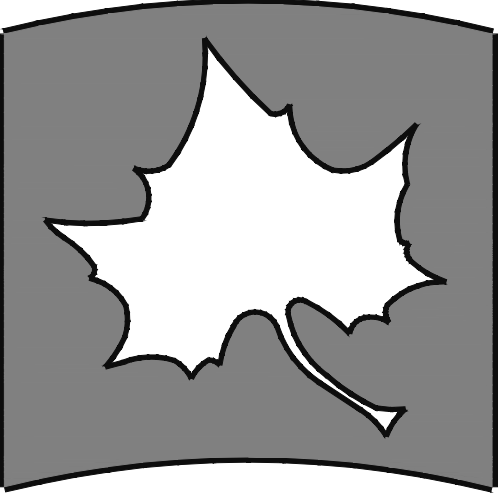

INDIANA STATE UNIVERSITY

Facilities Management Department  
951 Sycamore Street  
Terre Haute, Indiana 47809  
Phone: (812) 237-2100 Fax: (812) 237-7630

SYCAMORE STADIUM

RIGHT FIELD DECK


FIRST FLOOR PLAN

|               |             |
|---------------|-------------|
| FILENAME:     |             |
| PROPERTY NO.: |             |
| REVISIONS     |             |
| 1             |             |
| 2             |             |
| DATE:         | 5/27/2025   |
| SCALE:        | 1/4"=1'-0"  |
| DRAWN BY:     | S. STILLMAN |
| CHECKED BY:   | B. DUNCAN   |
| APPROVED BY:  |             |
| PROJECT NO.:  |             |


SHEET NO.:

A101


OF SHEETS

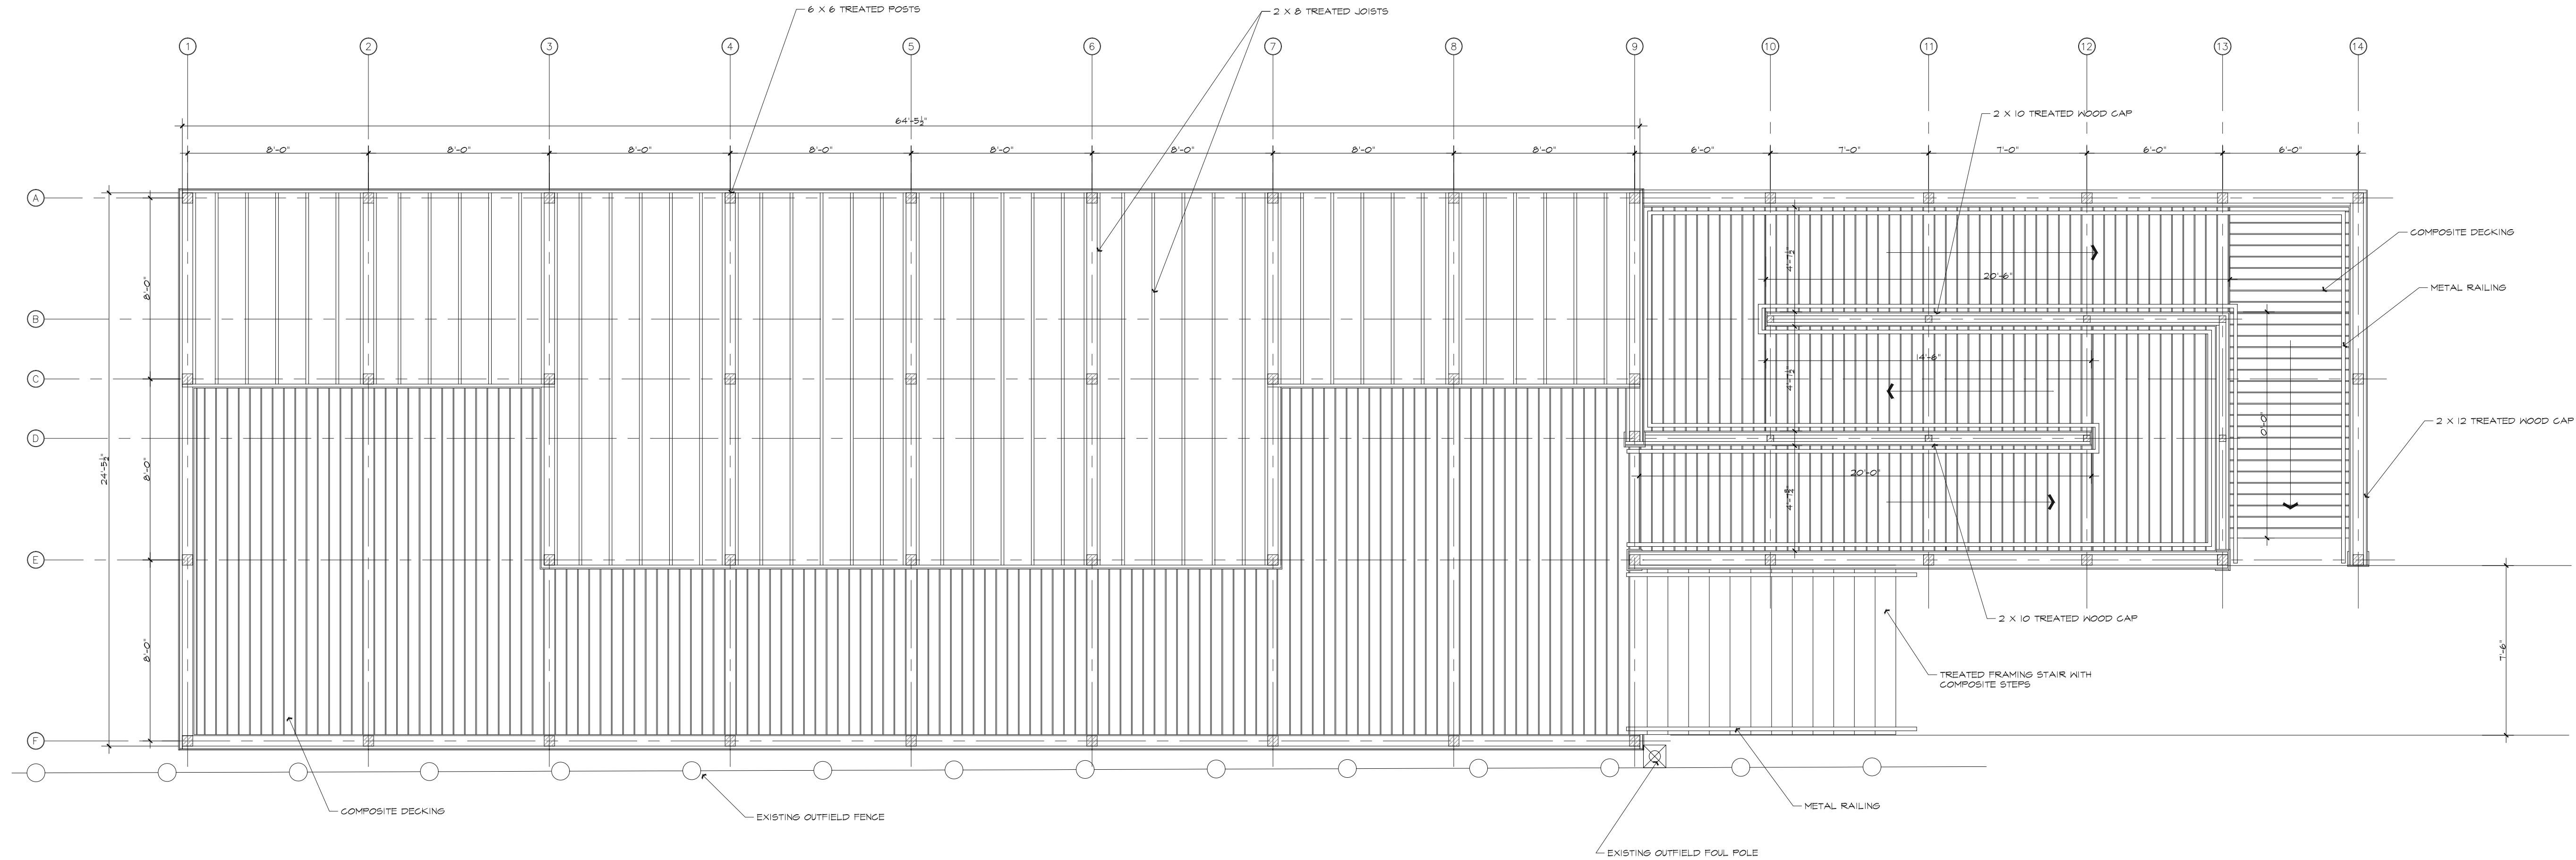

UPPER LEVEL FRAMING PLAN  
SCALE: 1/4"=1'-0"

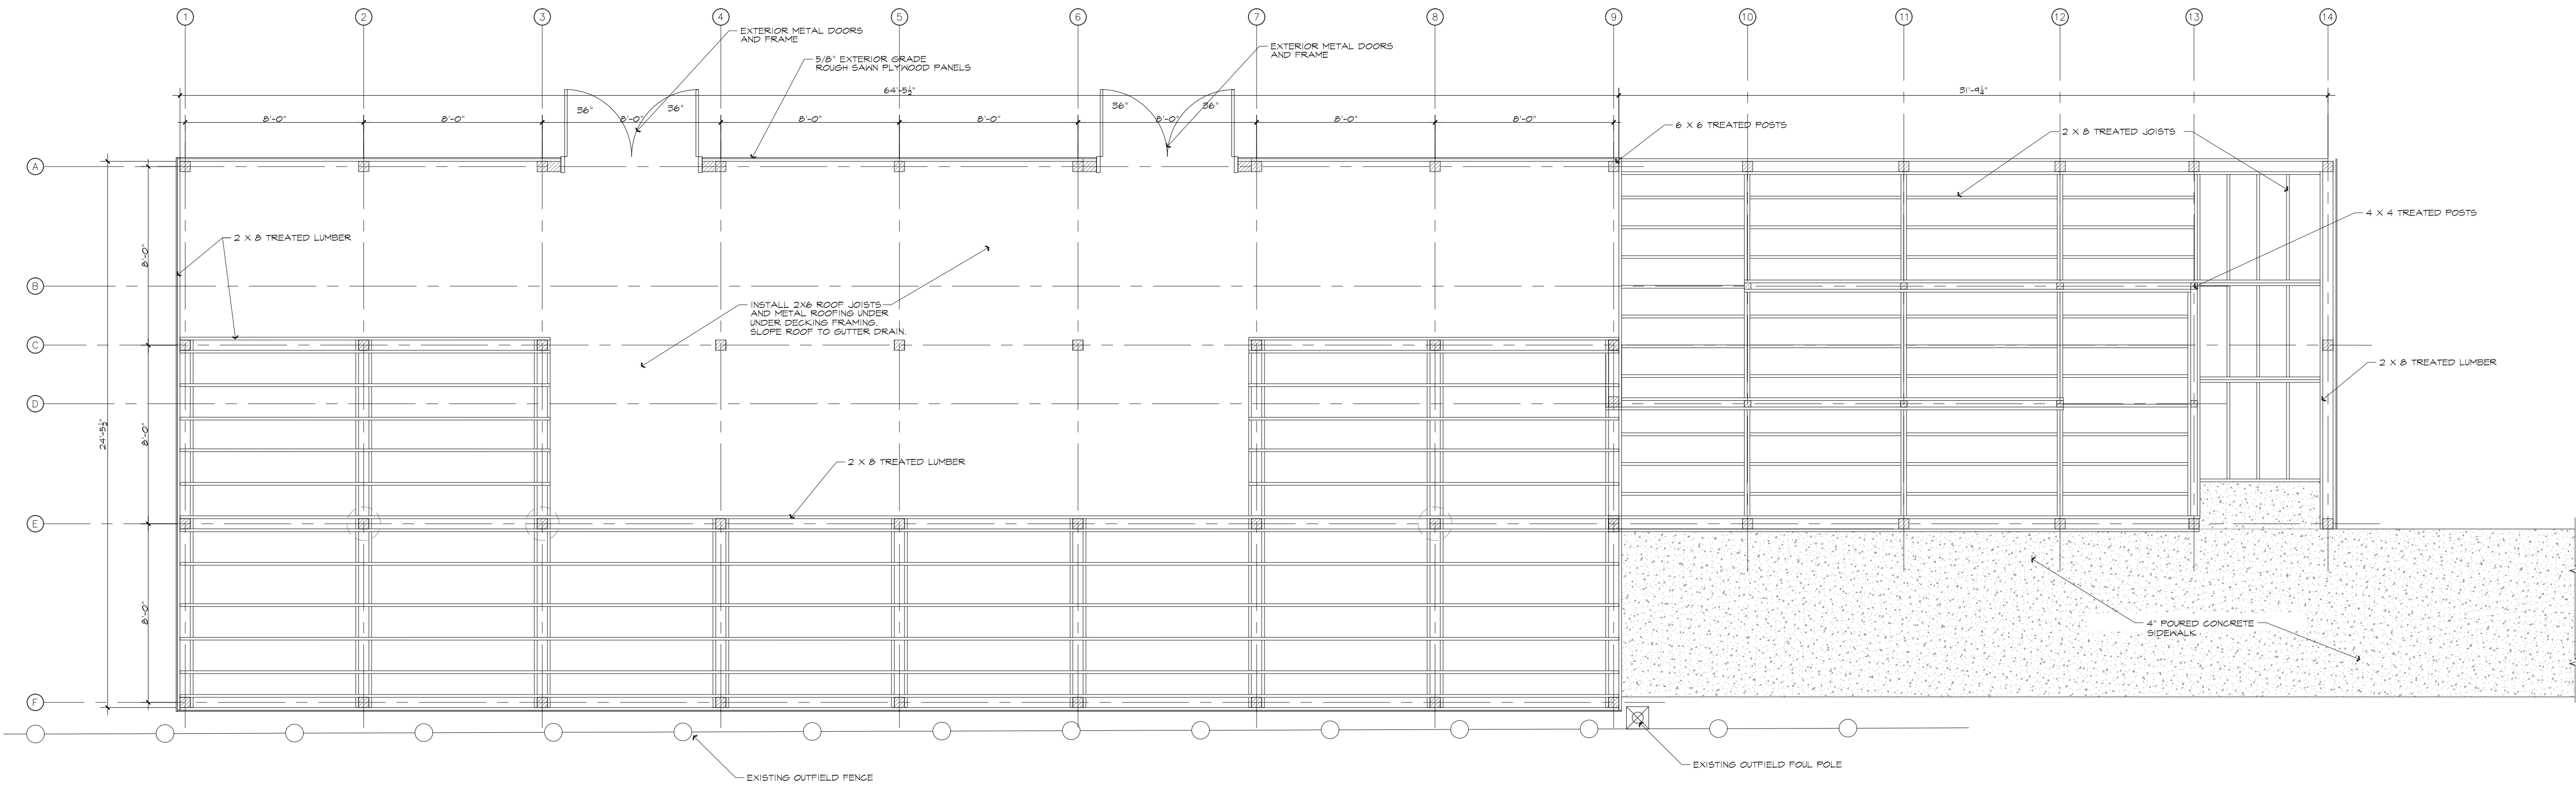

FIRST LEVEL FRAMING PLAN  
SCALE: 1/4"=1'-0"

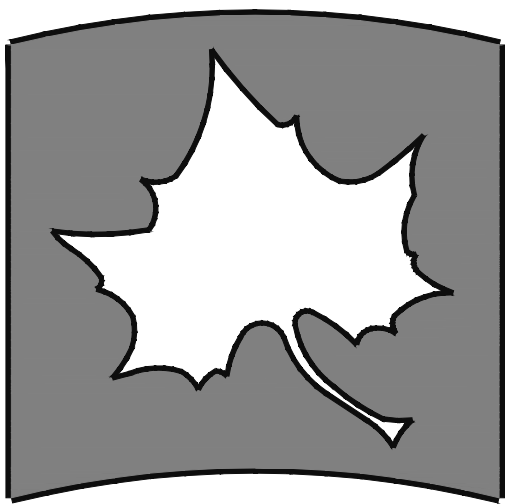



INDIANA STATE UNIVERSITY  
Facilities Management Department  
951 Sycamore Street  
Terre Haute, Indiana 47809  
Phone: (812) 237-2100 Fax: (812) 237-7630

SYCAMORE STADIUM  
RIGHT FIELD DECK  
FLOOR PLAN

|               |            |
|---------------|------------|
| FILENAME:     |            |
| PROPERTY NO.: |            |
| REVISIONS     |            |
| 1             |            |
| 2             |            |
| DATE:         | 5/27/2025  |
| SCALE:        | 1/4"=1'-0" |
| DRAWN BY:     | S.TILLMAN  |
| CHECKED BY:   | B.DUNCAN   |
| APPROVED BY:  |            |
| PROJECT NO.:  |            |

SHEET NO.:  
  
A102  
  
OF SHEETS

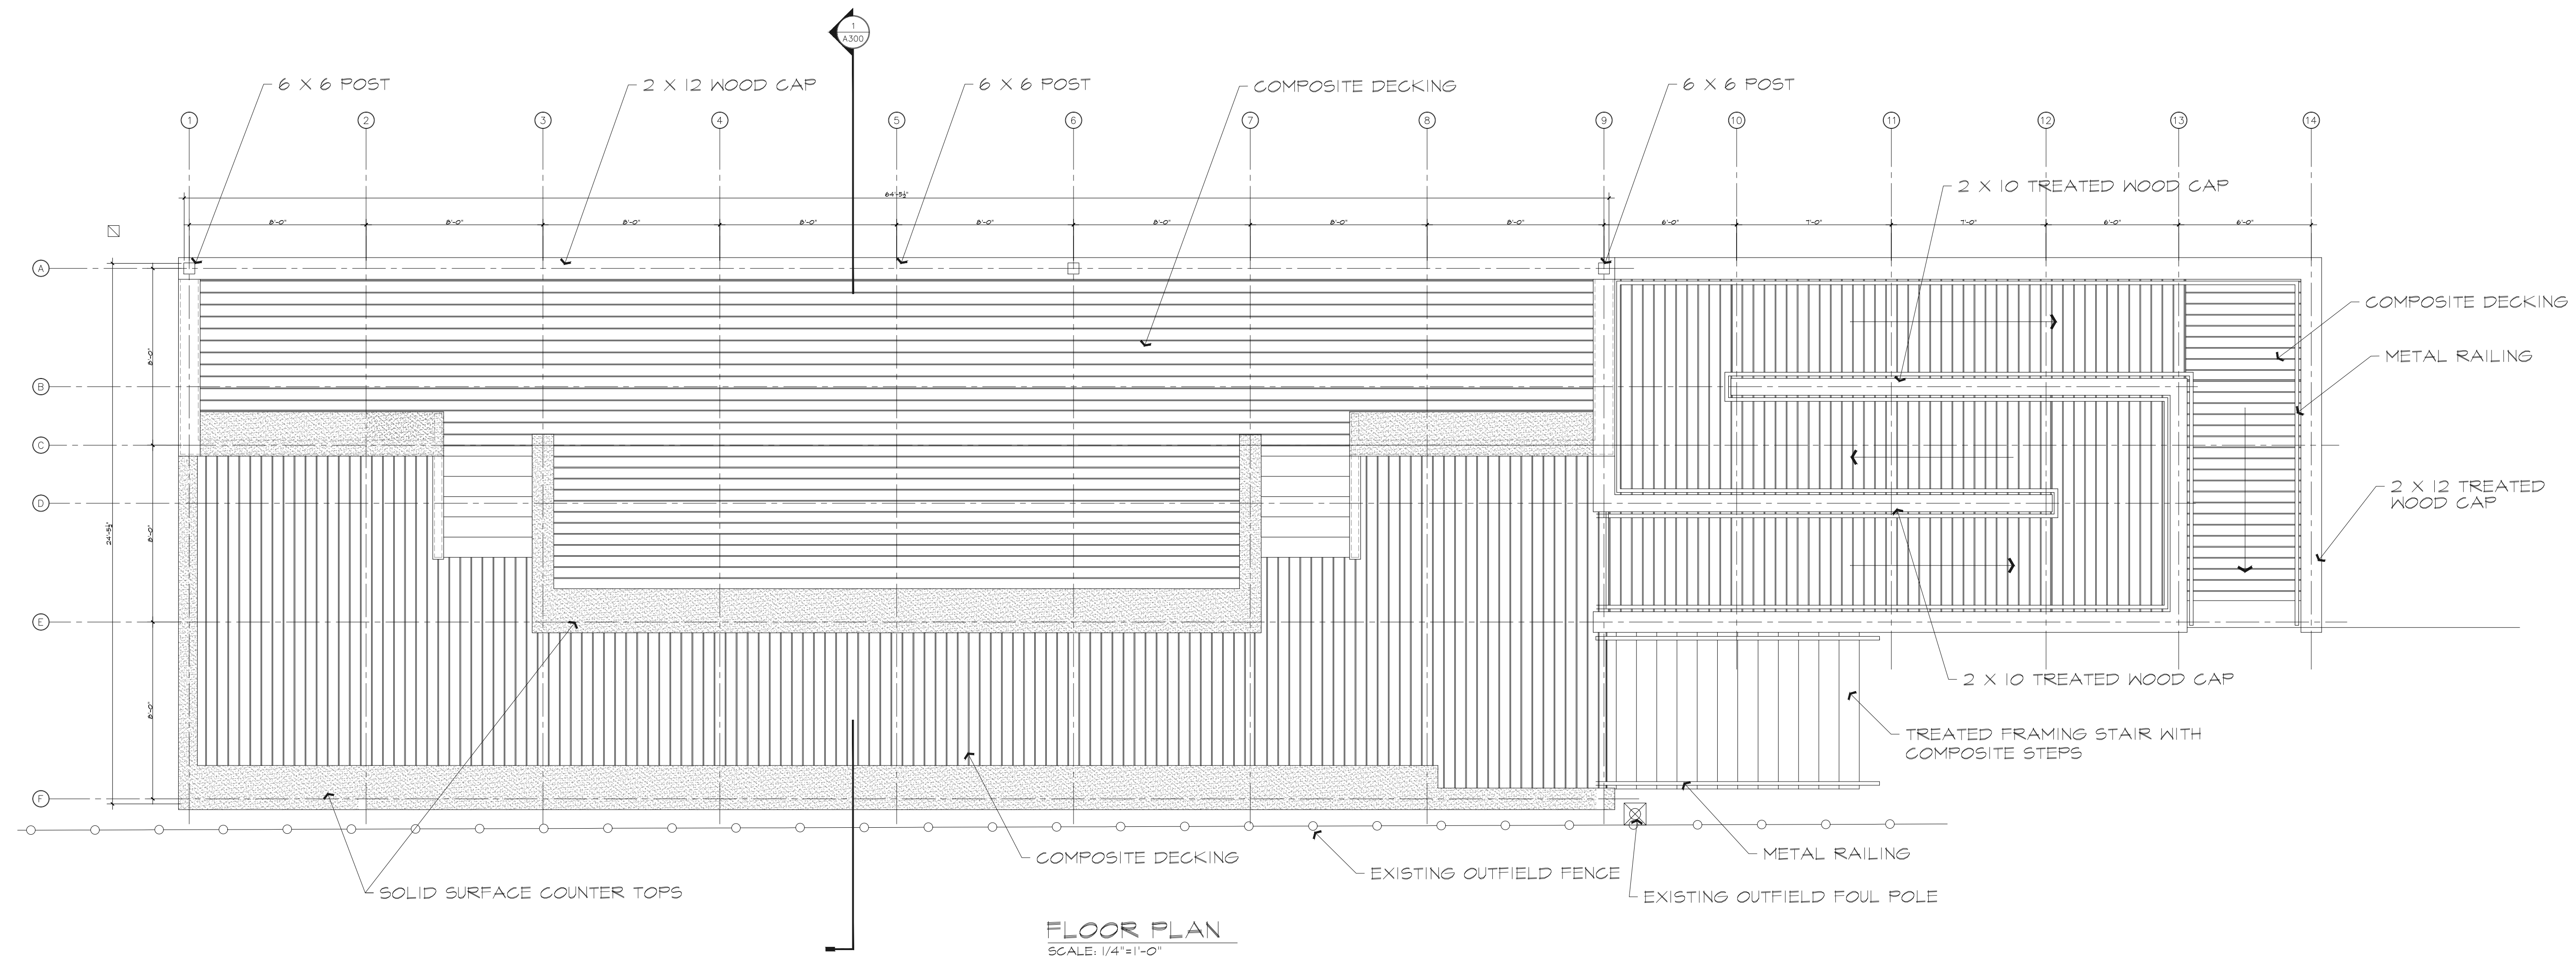

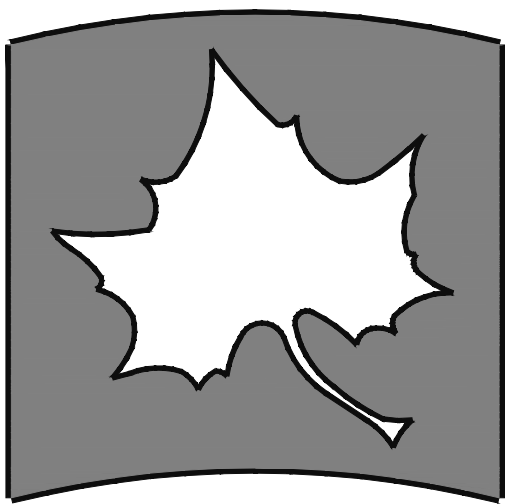





INDIANA STATE UNIVERSITY  
Facilities Management Department  
951 Sycamore Street  
Terre Haute, Indiana 47809  
Phone: (812) 237-2100 Fax: (812) 237-7630

SYCAMORE STADIUM  
RIGHT FIELD DECK  
ELEVATIONS

|               |             |
|---------------|-------------|
| FILENAME:     |             |
| PROPERTY NO.: |             |
| REVISIONS     |             |
| 1             |             |
| 2             |             |
| DATE:         | 5/27/2025   |
| SCALE:        | 1/4"=1'-0"  |
| DRAWN BY:     | S. STILLMAN |
| CHECKED BY:   | B. DUNCAN   |
| APPROVED BY:  |             |
| PROJECT NO.:  |             |

SHEET NO. 1  
A200  
OF SHEETS

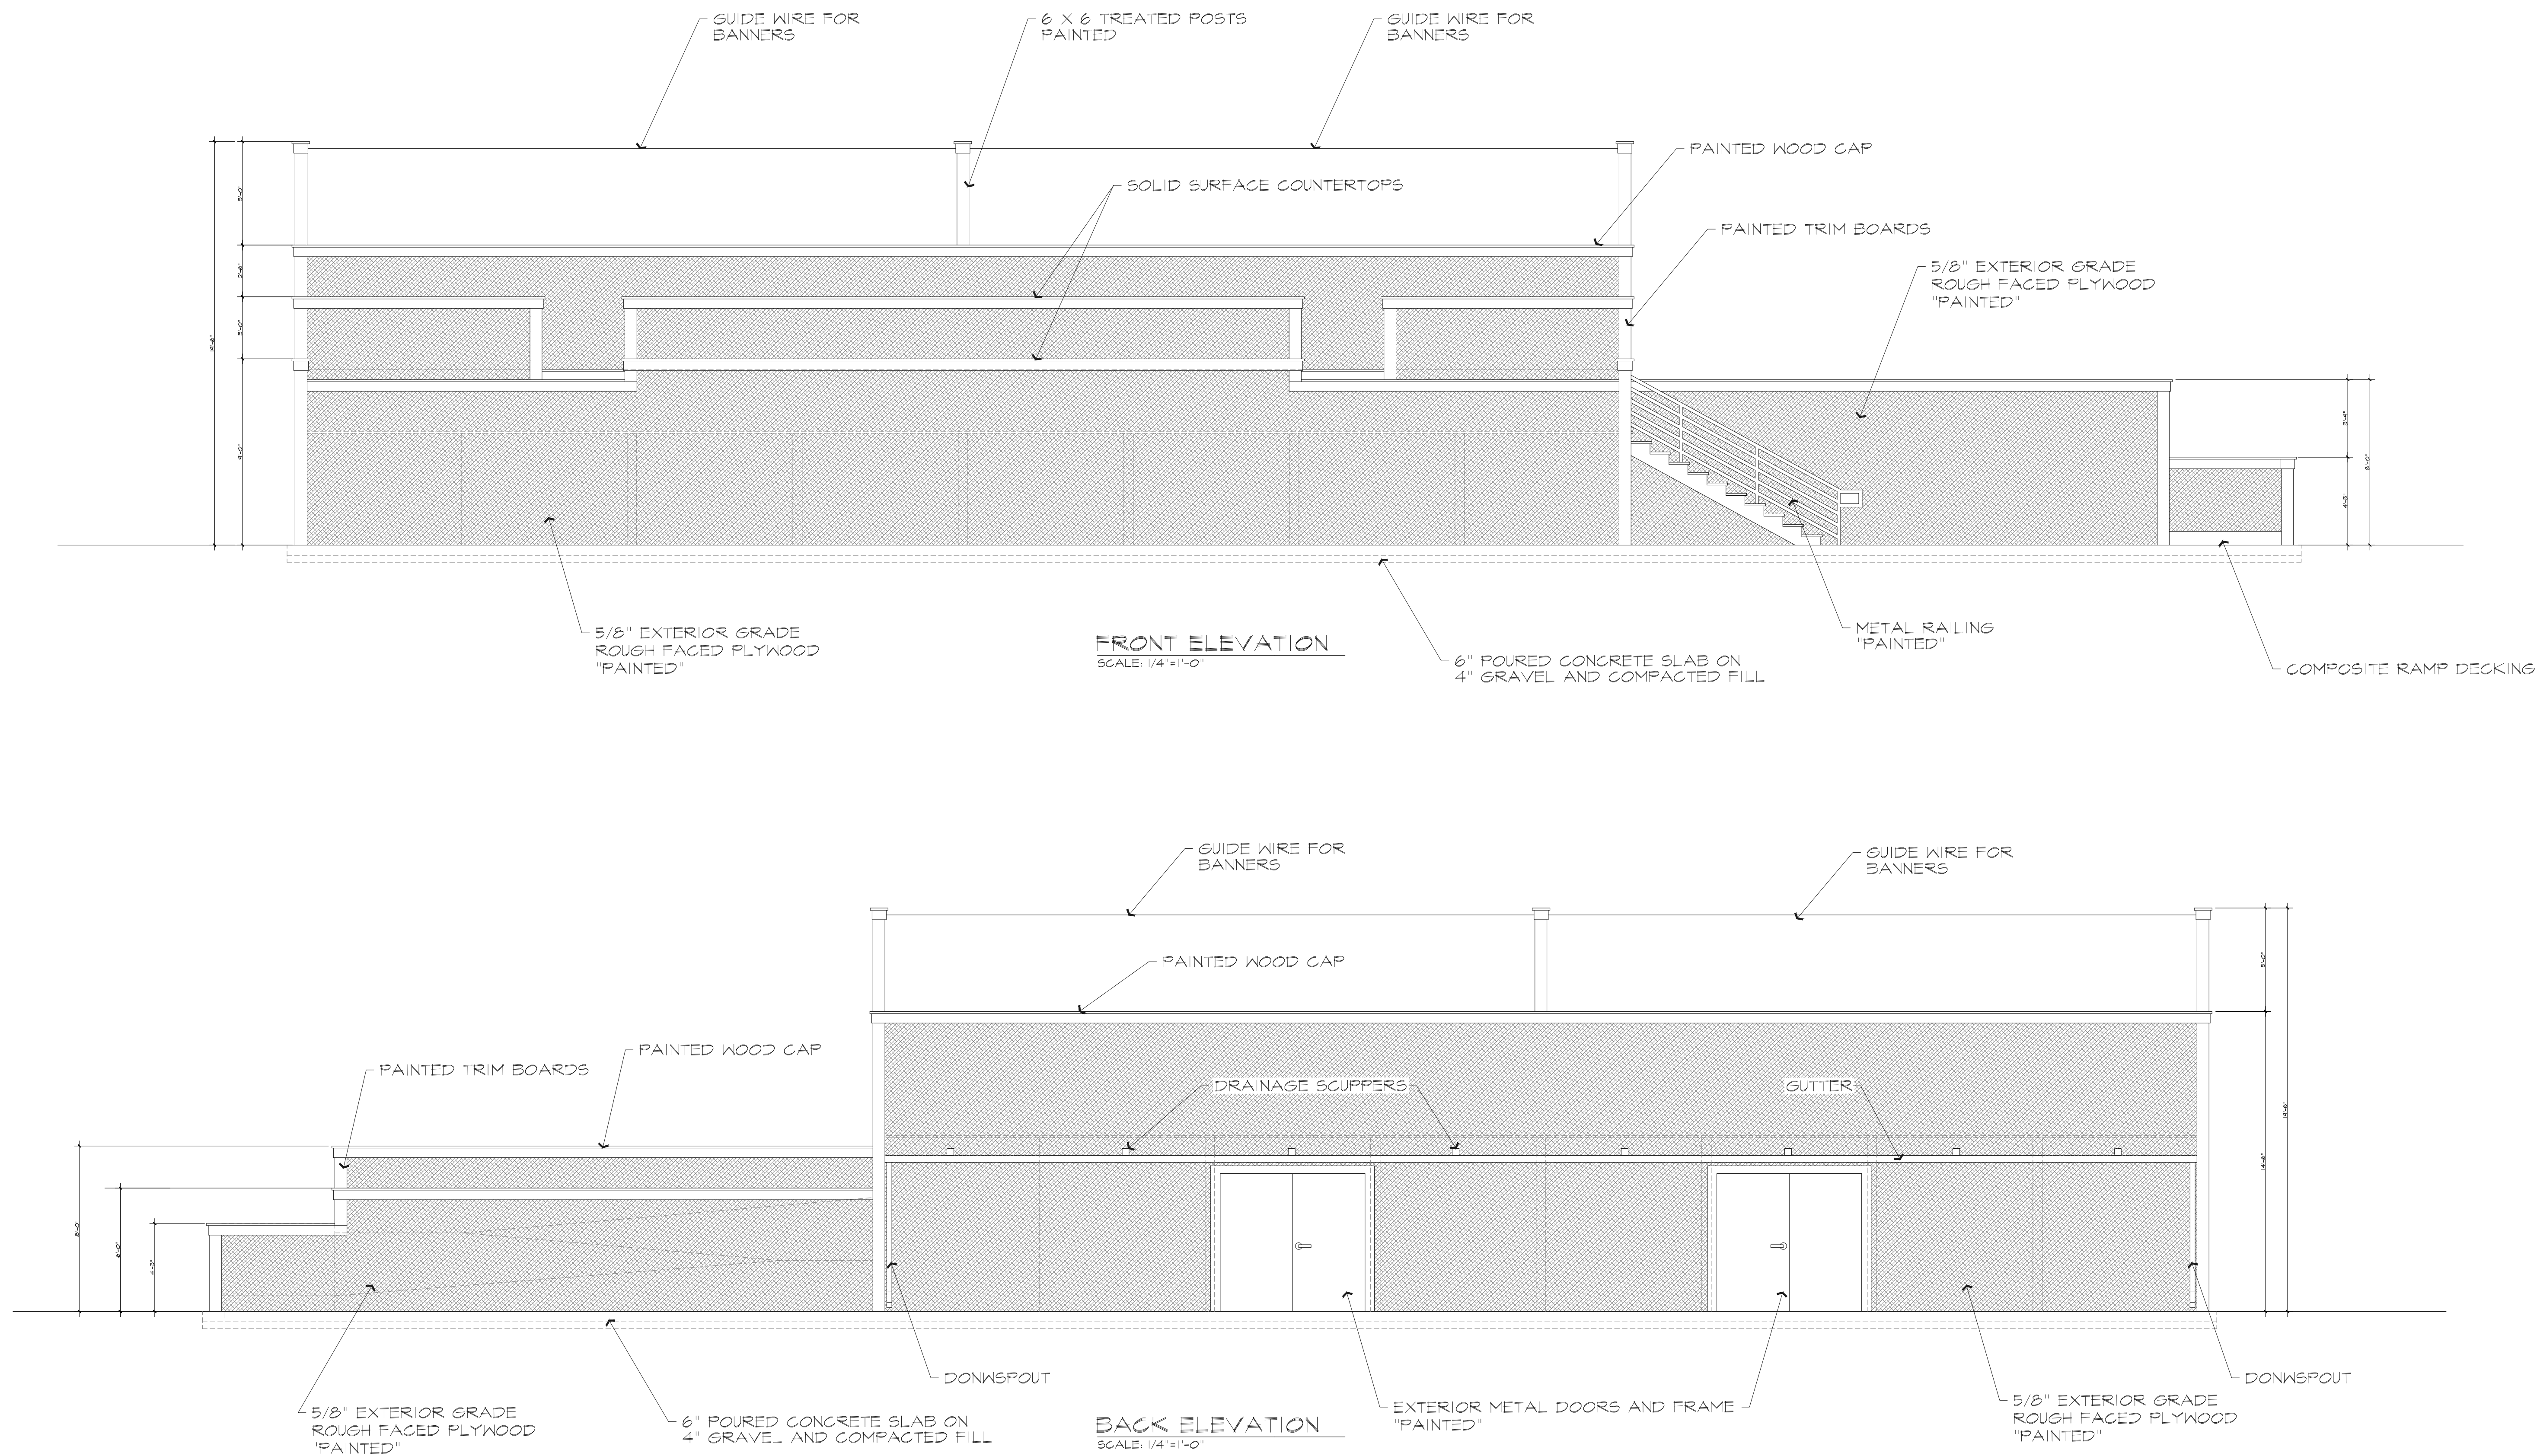

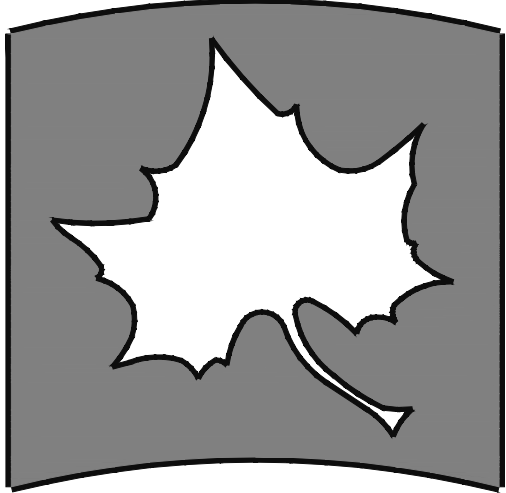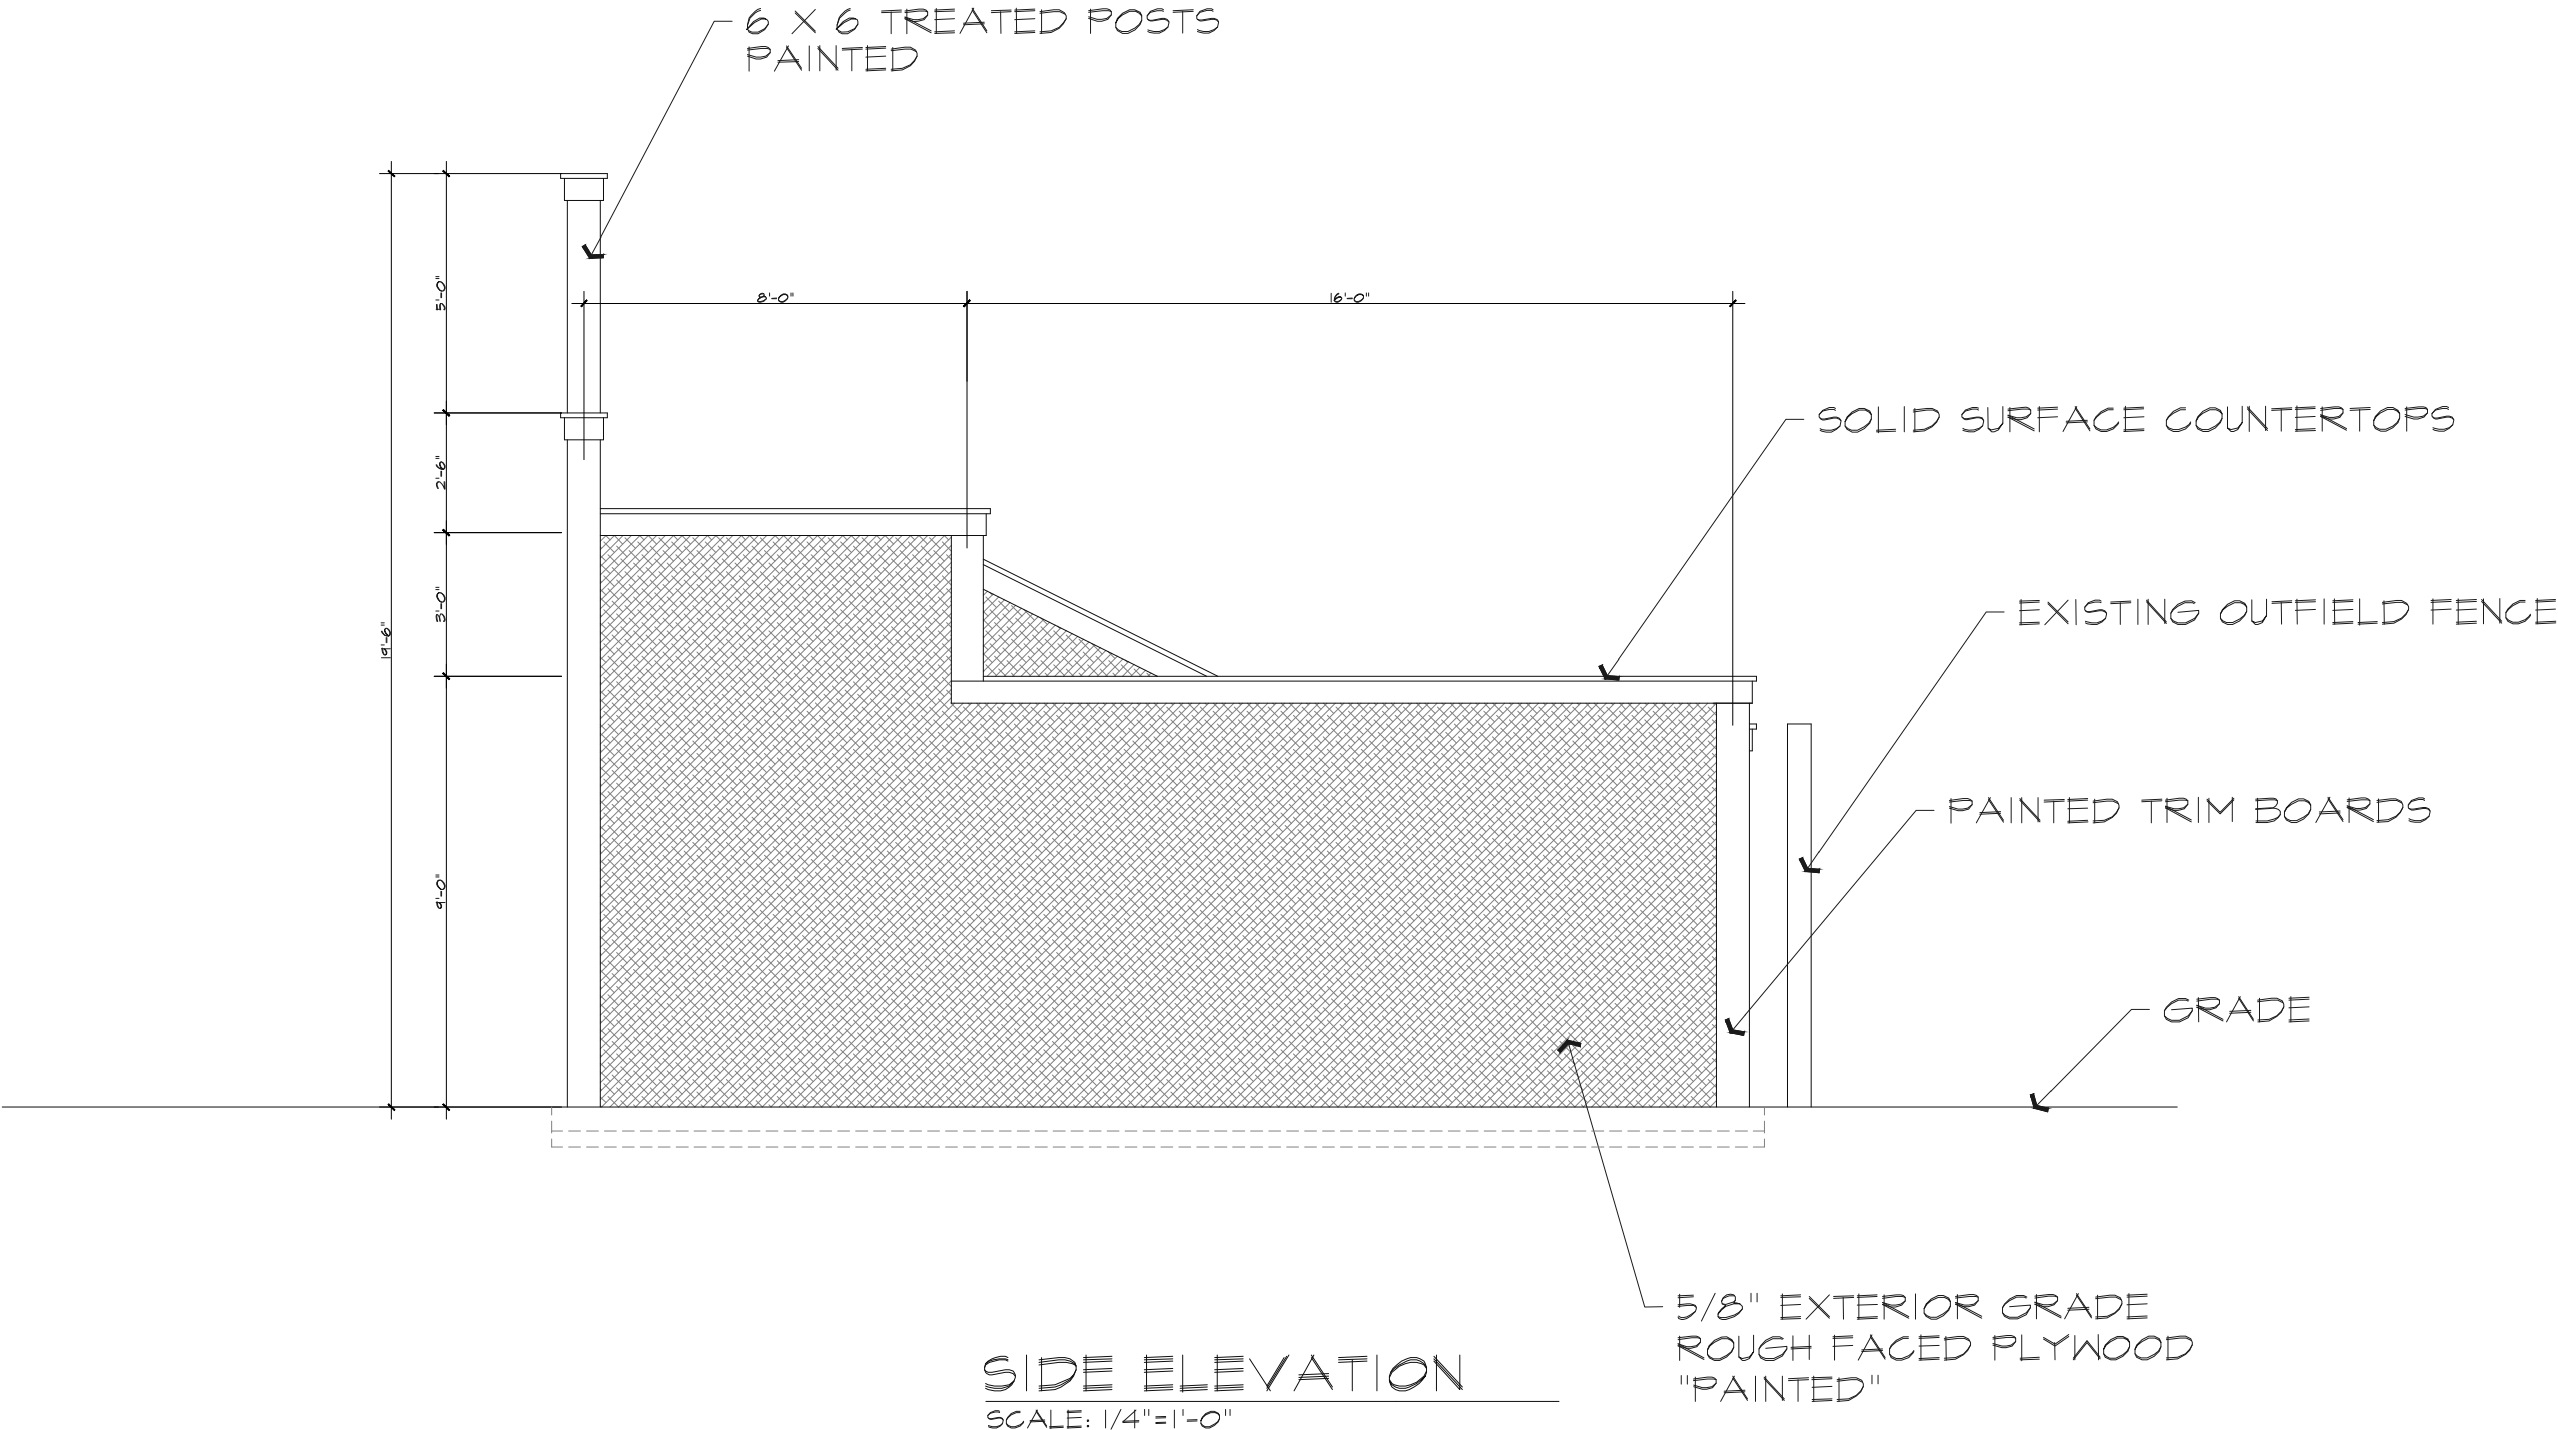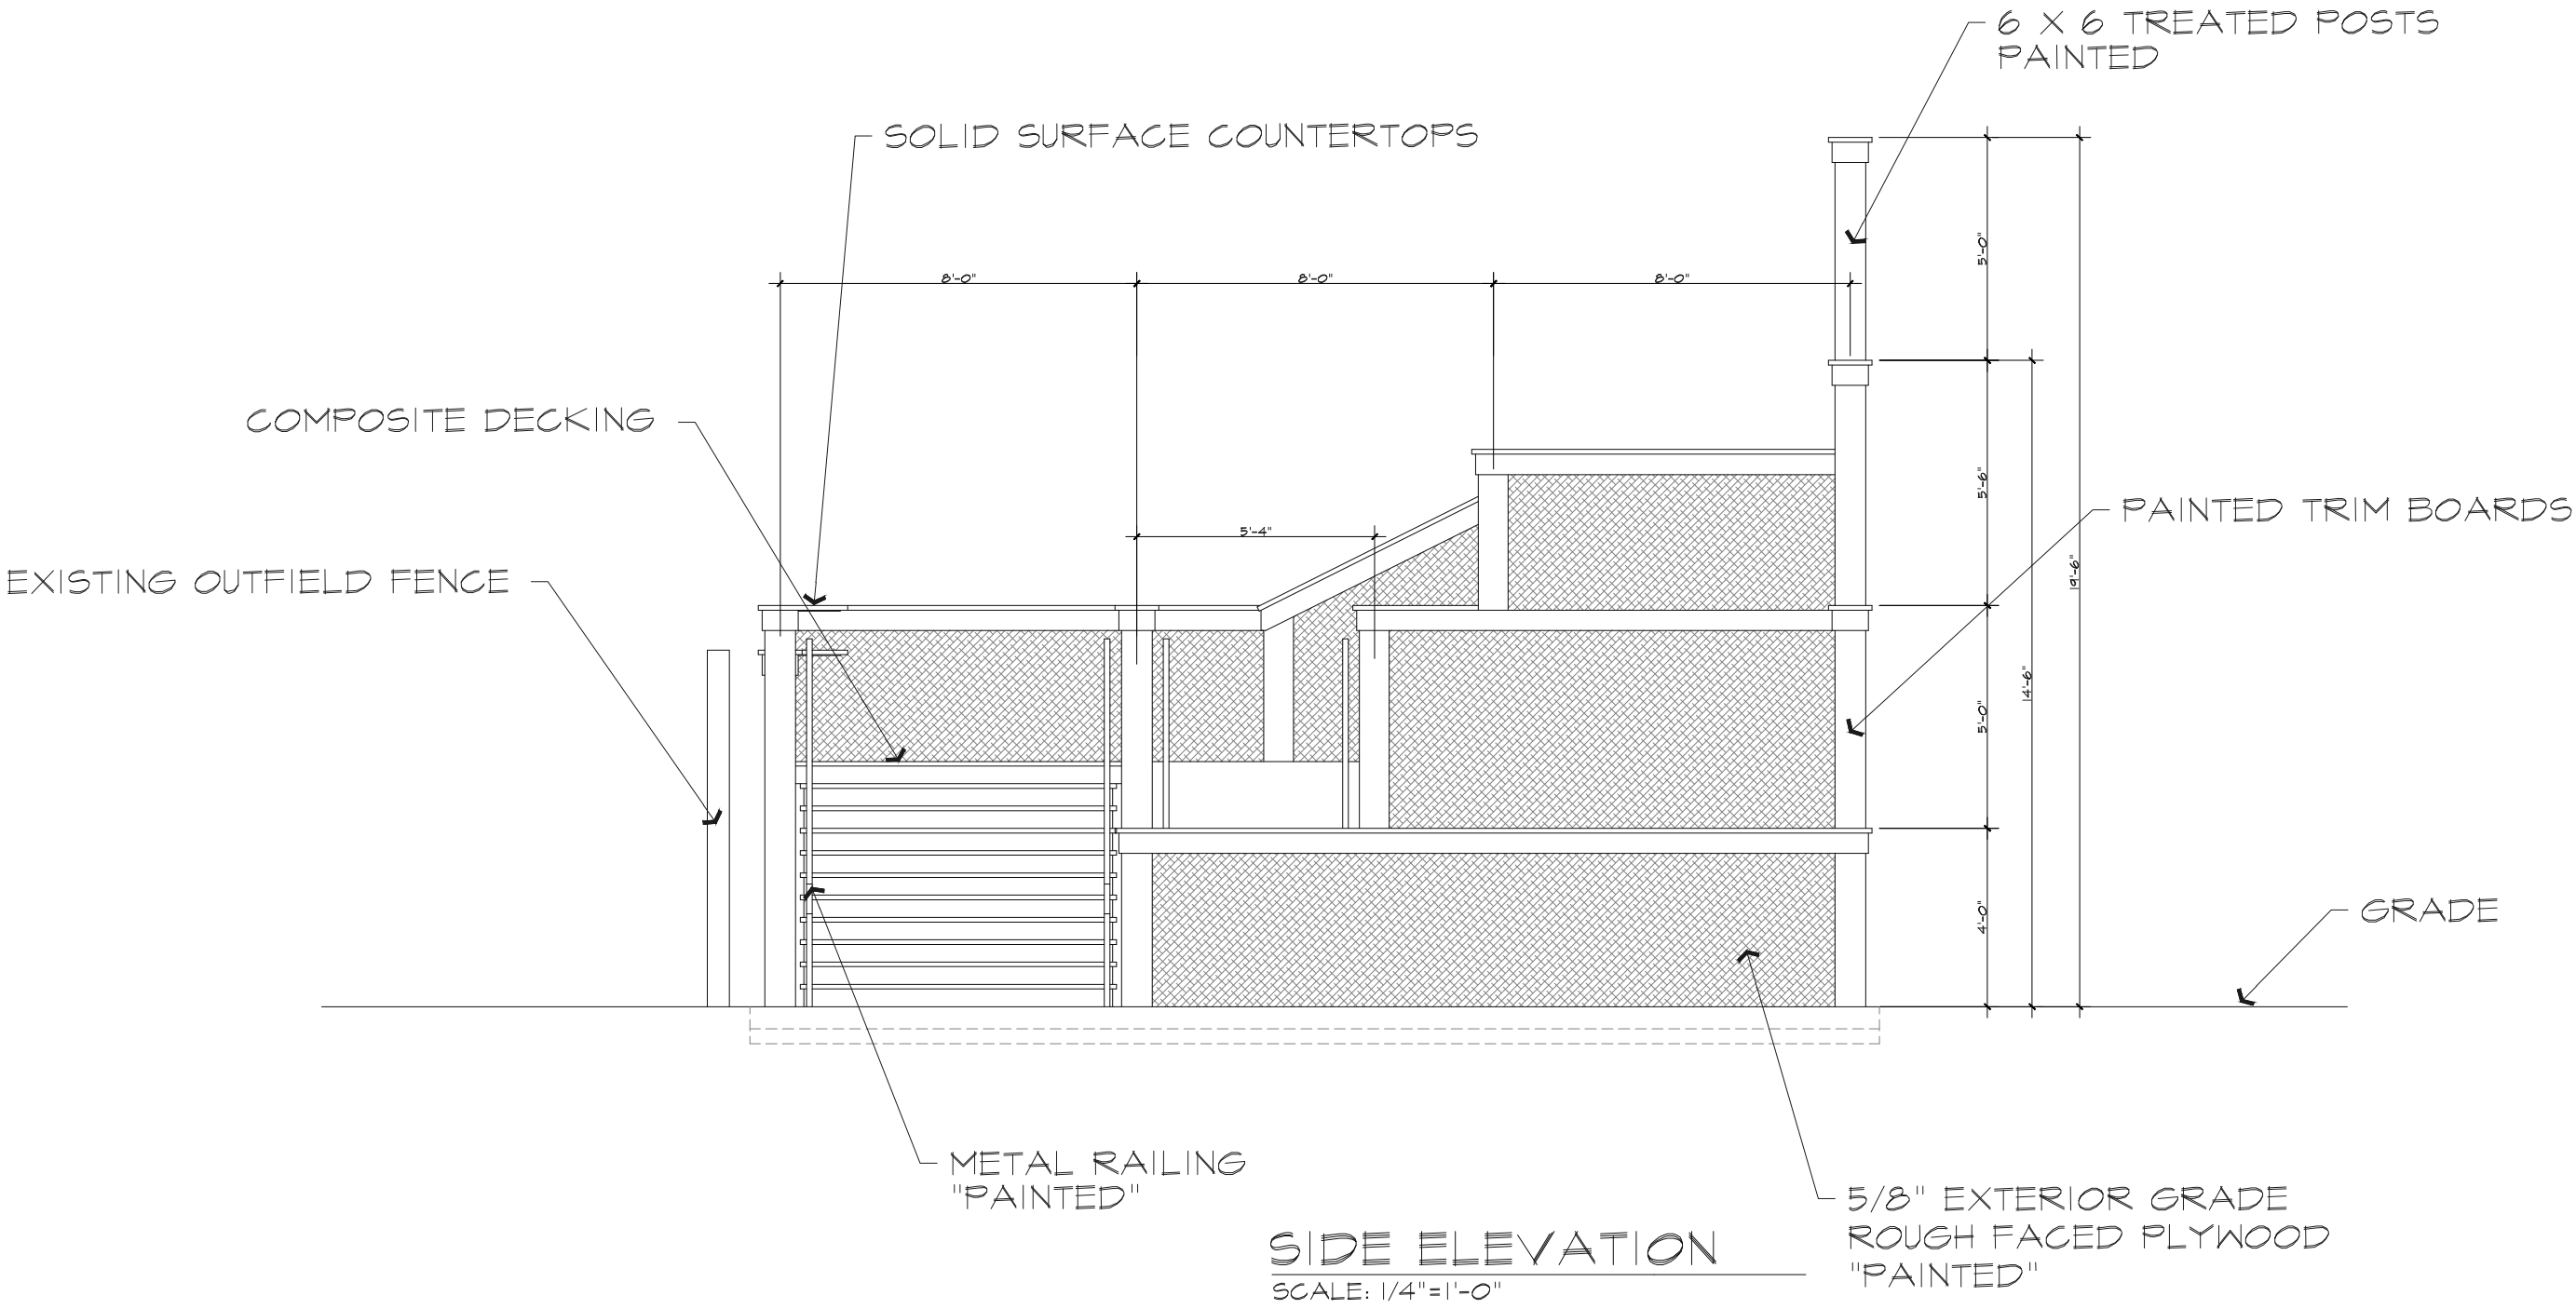


INDIANA STATE UNIVERSITY

Facilities Management Department  
951 Sycamore Street  
Terre Haute, Indiana 47809  
Phone: (812) 237-8100 Fax: (812) 237-7630


SYCAMORE STADIUM  
RIGHT FIELD DECK

SIDE ELEVATIONS

|               |            |
|---------------|------------|
| FILENAME:     |            |
| PROPERTY NO.: |            |
| REVISIONS     |            |
| 1             |            |
| 2             |            |
| DATE:         | 5/27/2025  |
| SCALE:        | 1/4"=1'-0" |
| DRAWN BY:     | S.TILLMAN  |
| CHECKED BY:   | B.DUNCAN   |
| APPROVED BY:  |            |
| PROJECT NO.:  |            |

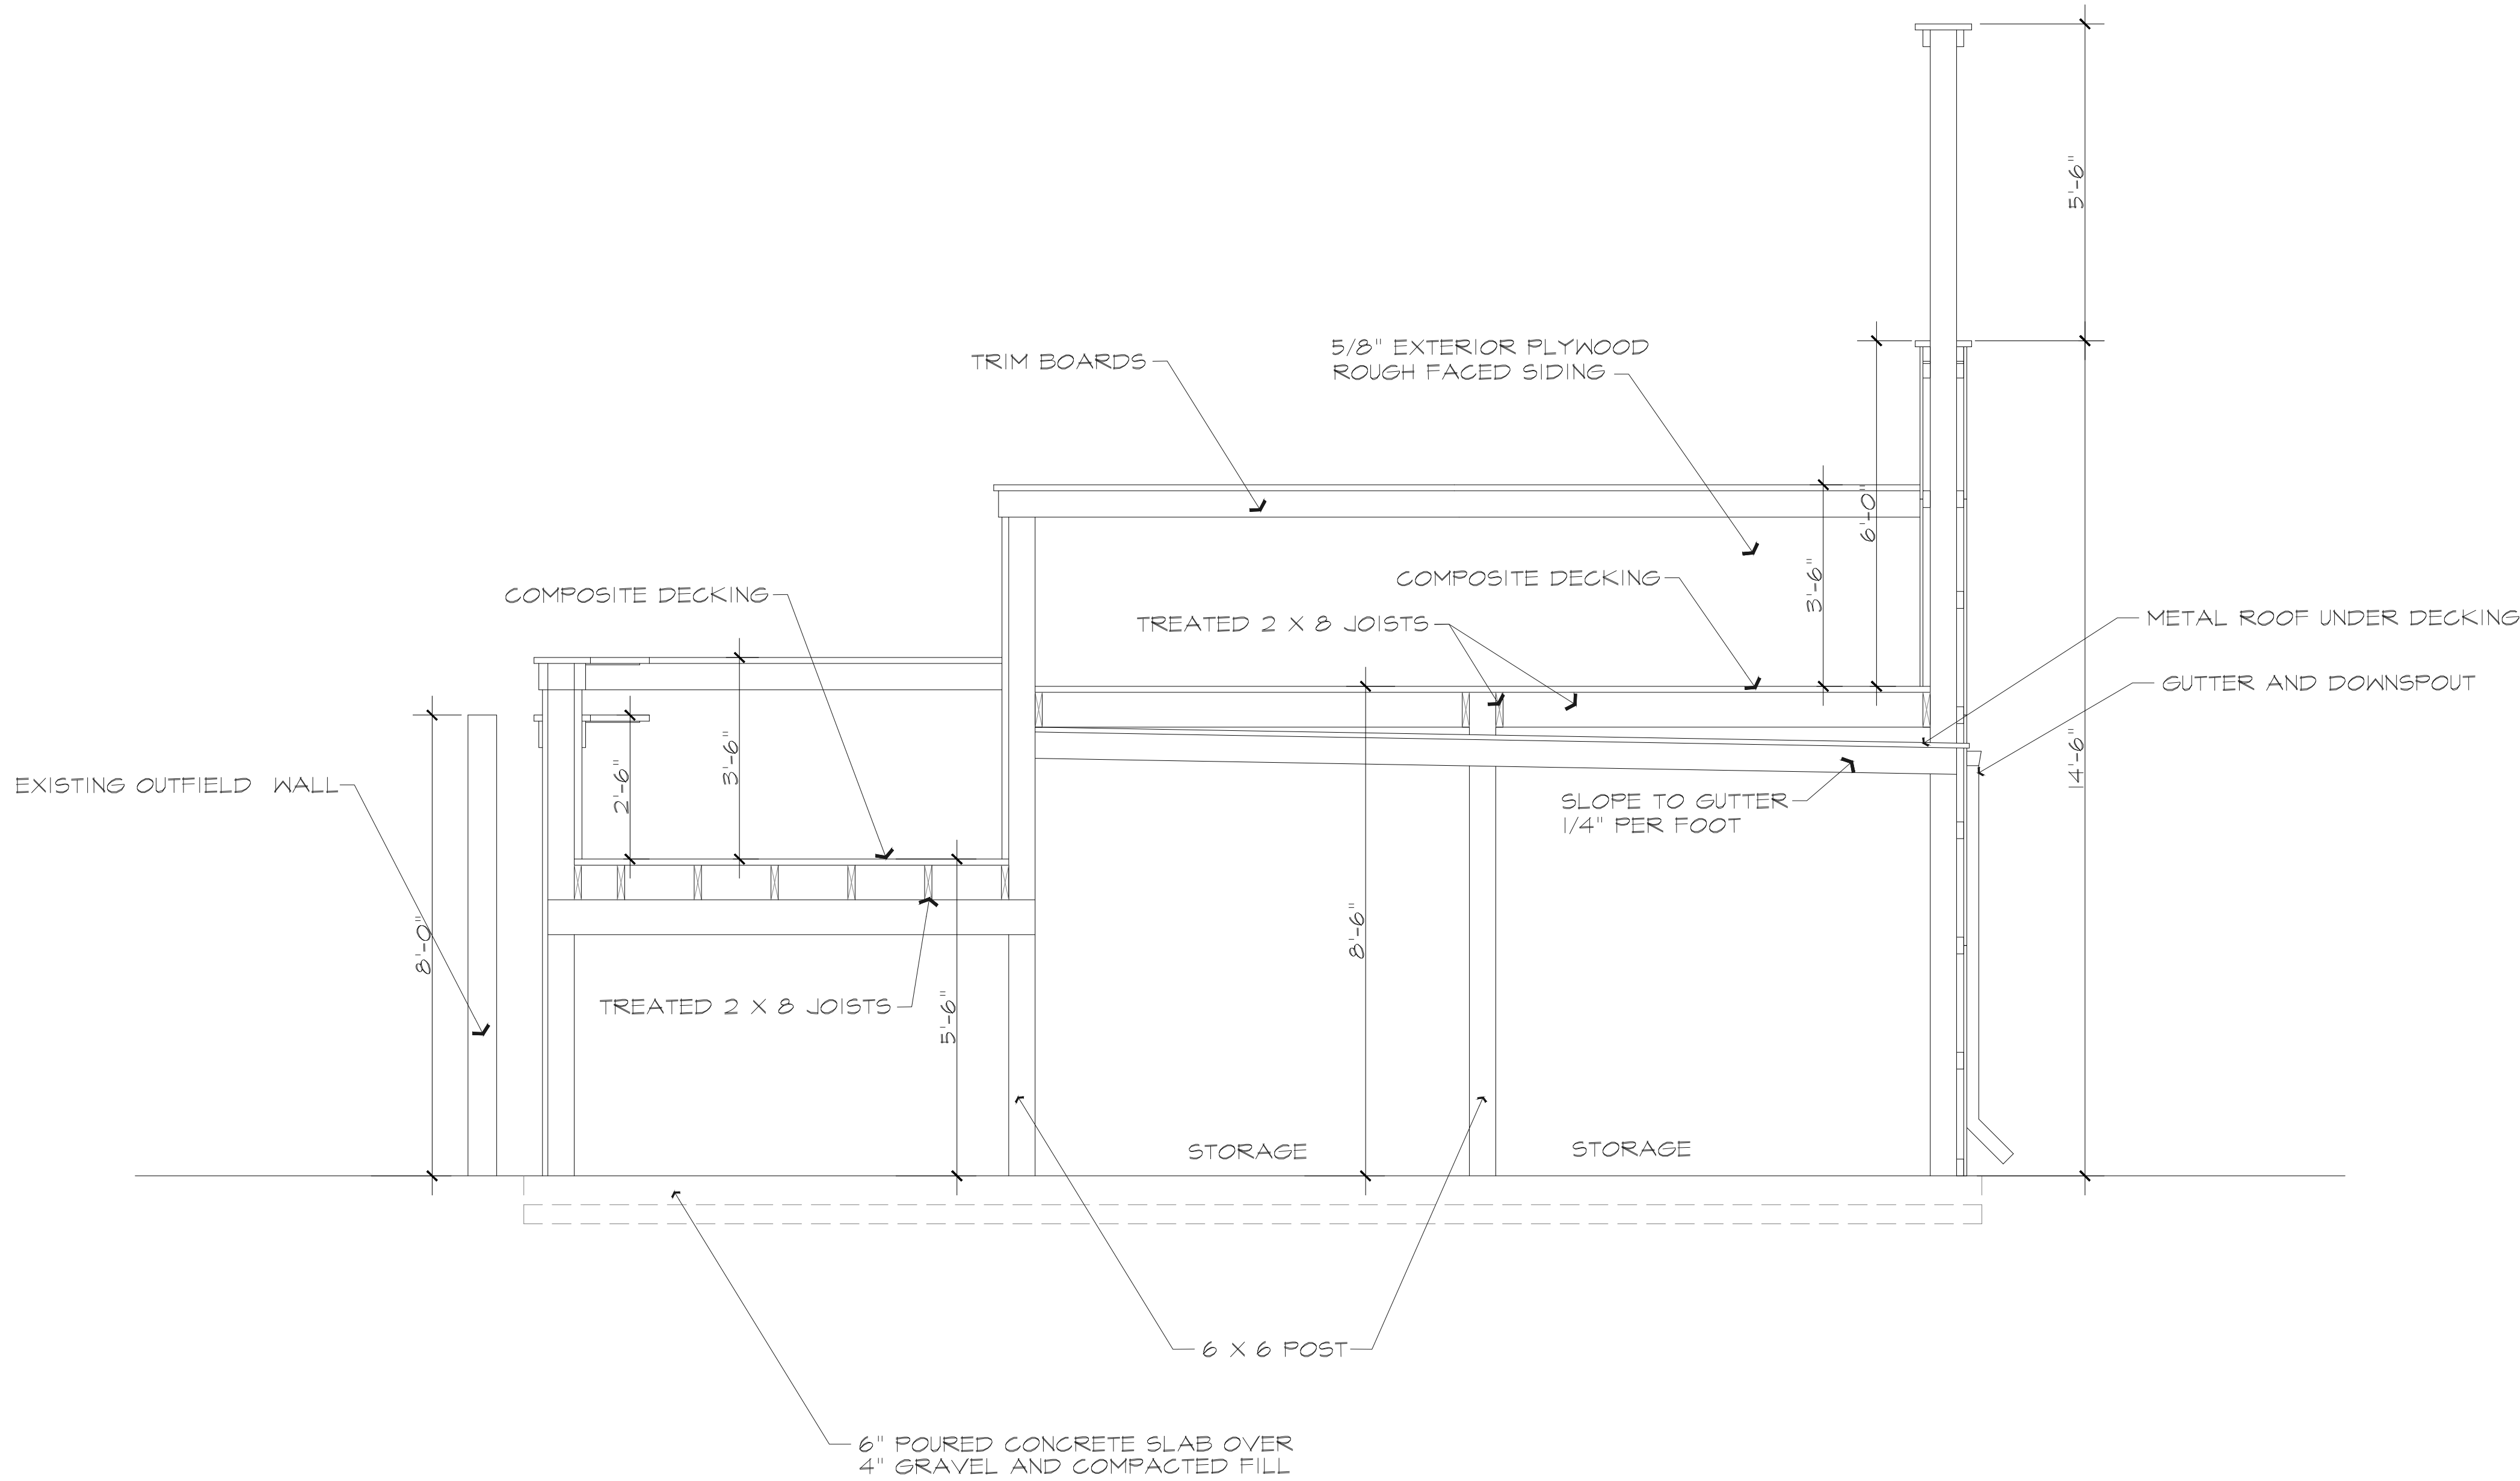

BUILDING SECTION I  
SCALE: 1/2"=1'-0"

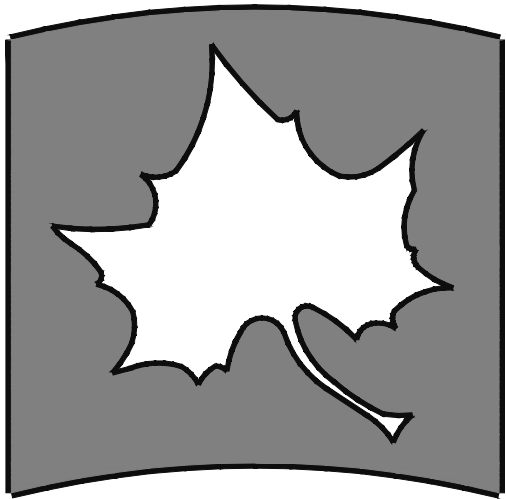


INDIANA STATE UNIVERSITY  
Facilities Management Department  
951 Sycamore Street  
Terre Haute, Indiana 47809  
Phone: (812) 237-2100 Fax: (812) 237-7630

SYCAMORE STADIUM  
RIGHT FIELD DECK  
SECTIONS

|              |            |
|--------------|------------|
| FILENAME:    |            |
| PROPERTY NO: |            |
| REVISIONS    |            |
| 1            |            |
| 2            |            |
| DATE:        | 5/27/2025  |
| SCALE:       | 1/2"=1'-0" |
| DRAWN BY:    | S.TILLMAN  |
| CHECKED BY:  | B.DUNCAN   |
| APPROVED BY: |            |
| PROJECT NO:  |            |

SHEET NO.:  
A300  
OF SHEETS

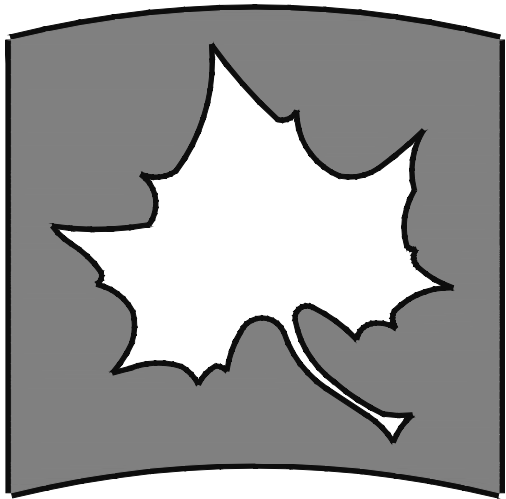

INDIANA STATE UNIVERSITY

Facilities Management Department  
951 Sycamore Street  
Terre Haute, Indiana 47809  
Phone: (812) 237-2100 Fax: (812) 237-7630


SYCAMORE STADIUM  
RIGHT FIELD DECK

GROUND LEVEL ELECTRICAL PLAN

FIXTURE SCHEDULE

TYPE "A" COLUMBIA CSL STRIPLIGHT CATALOG # CSL4-A-LS03

TYPE "B" ILP VIEWPOINT WALL PACK PART # VWM-BL / 11L / 14L-U-CCTS-T3-BRZ-+PCU

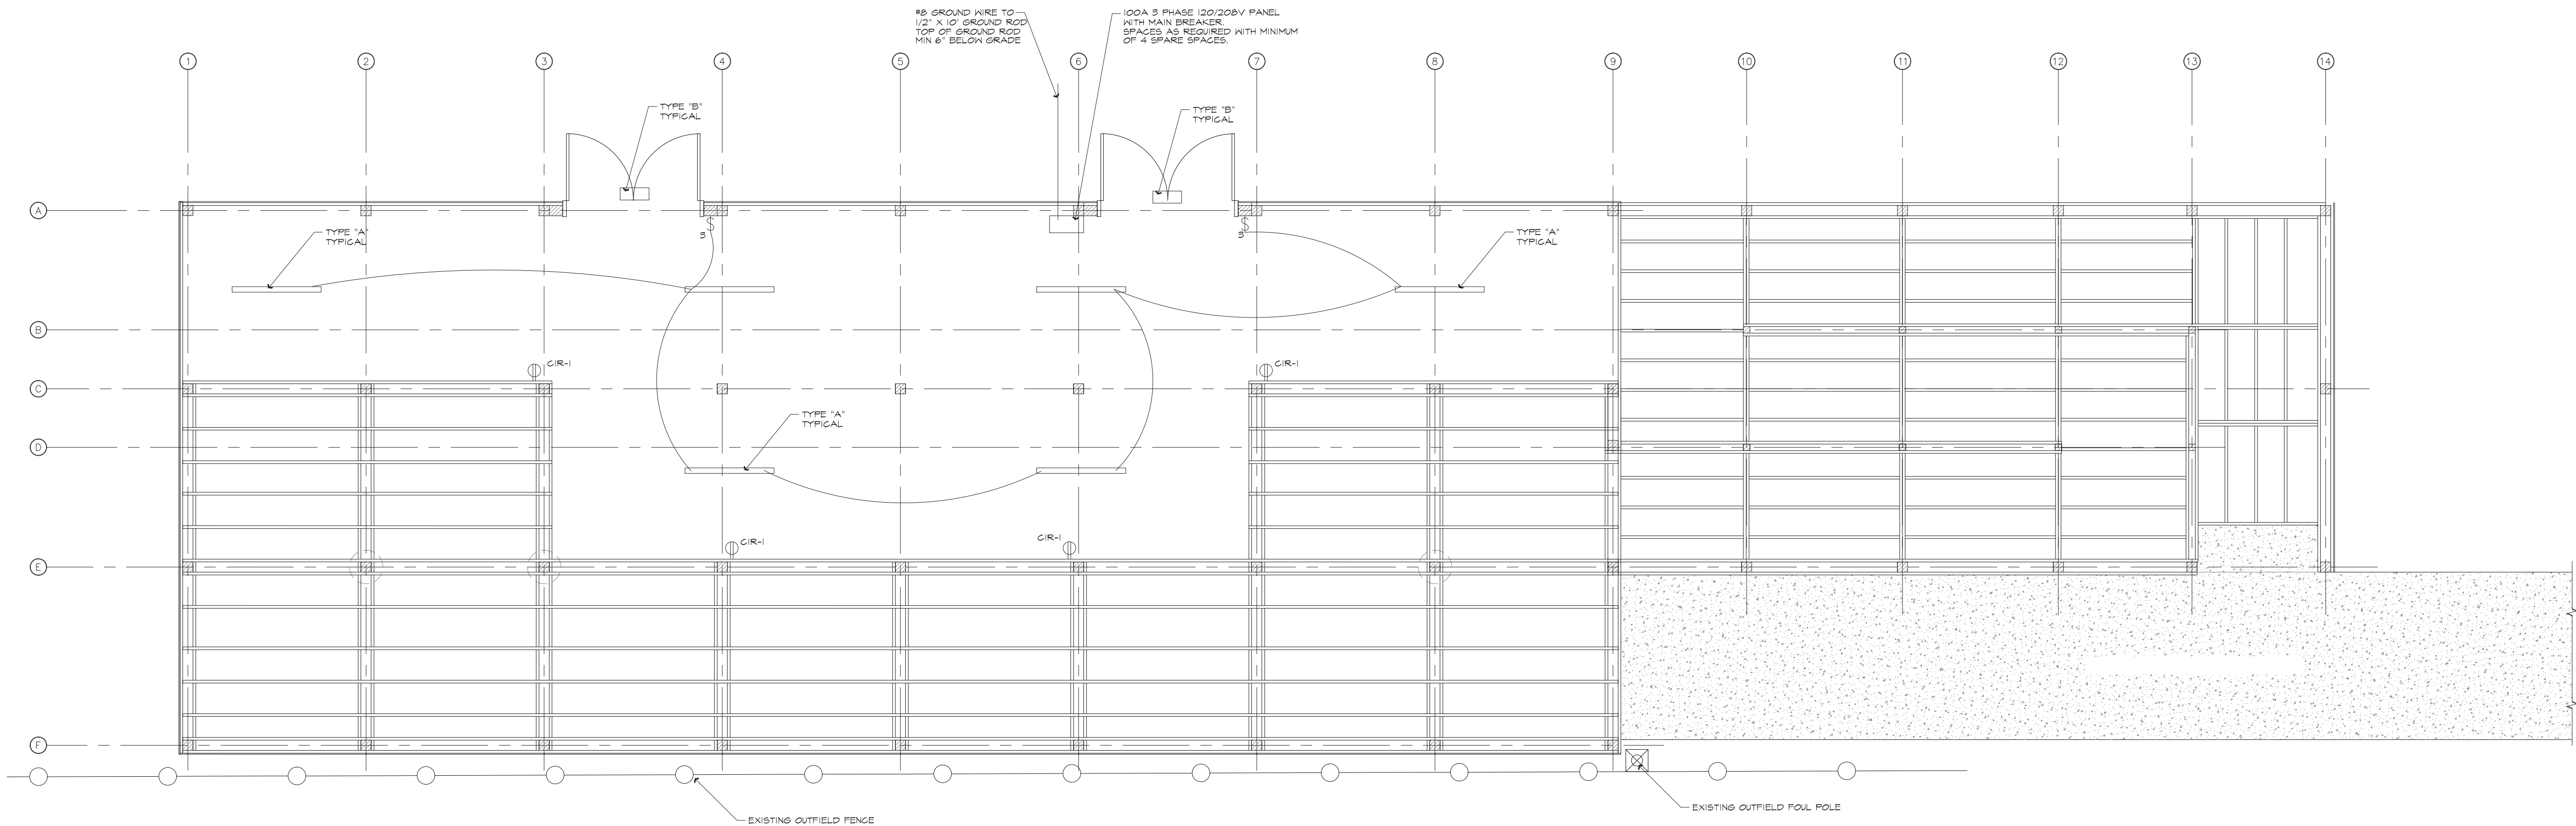


GROUND LEVEL ELECTRICAL PLAN  
SCALE: 1/4"=1'-0"

|              |            |
|--------------|------------|
| FILENAME:    |            |
| PROPERTY NO: |            |
| REVISIONS    |            |
| 1            |            |
| 2            |            |
| DATE:        | 5/27/2025  |
| SCALE:       | 1/4"=1'-0" |
| DRAWN BY:    | S.TILLMAN  |
| CHECKED BY:  | B.DUNCAN   |
| APPROVED BY: |            |
| PROJECT NO:  |            |

SHEET NO.:

E101

OF SHEETS

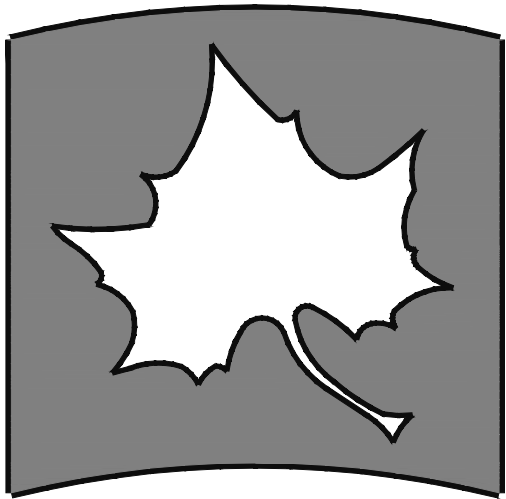

INDIANA STATE UNIVERSITY

Facilities Management Department  
951 Sycamore Street  
Terre Haute, Indiana 47804  
Phone: (812) 237-2100 Fax: (812) 237-7630

SYCAMORE STADIUM  
RIGHT FIELD DECK

DECK LEVEL ELECTRICAL PLAN

|               |             |
|---------------|-------------|
| FILENAME:     |             |
| PROPERTY NO.: |             |
| REVISIONS     |             |
| 1             |             |
| 2             |             |
| DATE:         | 5/27/2025   |
| SCALE:        | 1/4"=1'-0"  |
| DRAWN BY:     | S. STILLMAN |
| CHECKED BY:   | B. DUNCAN   |
| APPROVED BY:  |             |
| PROJECT NO.:  |             |

SHEET NO.:

E102

OF SHEETS

