



BANQUET TABLE LAYOUT
 FOR
 Wm. S. REA PARK CLUB HOUSE
 JOHNSON MILLER MILLER & YEAGER
 ARCHITECTS
 TERRE HAUTE, IND. SEPT. 1, 1925
 SCALE 1/4" = 1'-0"

ROOM SCHEDULE										
ROOMS	FLOOR	WALLS	CEILING	NOTES						
DESCRIPTIONS	ROOM NUMBER	CONC.	PL.	GL.	WOOD	METAL	STONE	TILE	FINISH	ABBREVIATIONS FOR THIS SCHEDULE ONLY
BASEMENT										
WOMEN'S LOCKER ROOM	(1)	CONG.	U		VP	SHV	CP	U	C.P.	CONG. CONCRETE
WOMEN'S TOILET & SHOWER	(2)	CONG.	U		VP	SHV	CP	U	C.P.	C.C. CONCRETE
MEN'S LOCKER ROOM	(3)	CONG.	U		VP	SHV	CP	U	C.P.	U. UNFINISHED
MEN'S TOILET & SHOWER	(4)	CONG.	U		VP	SHV	CP	U	C.P.	SG. SAND FINISH
STORAGE ROOM	(5)	CONG.	U		VP	SHV				CEN. CEMENT
COAL ROOM	(6)	CONG.	U		VP	SHV				Y.P. YELLOW PINE
HALL	(7)	CONG.	SFG.	CEN.	VP	SHV				EN. ENAMEL
HALL	(8)	CONG.	SFG.	CEN.	VP	SHV				C.P. CONC. PAINT
FIRST FLOOR										
CARE-TAKERS' QUARTERS	(9)	CONG.	CC.	SFG.	CC.	VP	VP	SHV	SFG.	F.D. FIBRE BOARD
RECEPTION ROOM	(10)	CONG.	CC.	SFG.	CC.	VP	VP	SHV	SFG.	TESS. TERRAZZO
LAUNCE	(11)	CONG.	TESS.	SFG.	TESS.	VP	VP	SHV	SFG.	
OFFICE & LUNCH ROOM	(12)	CONG.	CC.	SFG.	CC.	VP	VP	SHV	SFG.	
KITCHEN	(13)	CONG.	CC.	SFG.	CC.	VP	VP	SHV	SFG.	


WINDOW SCHEDULE				
MARK	SIZE	GLAZING	TYPE	REMARKS
A	6-11 x 8-3 1/2	10 x 12	STATIONARY	STEEL SASH
B	3-2 1/2 x 4-4 1/4	8 x 12	CASEMENTS	STEEL SASH
C	4-1 1/2 x 4-4 1/4	8 x 12	CASEMENTS	STEEL SASH
D	5-2 1/2 x 3-1 1/2	12 x 14	VENTILATING	STEEL SASH
E	4-2 1/2 x 3-1 1/2	12 x 14	VENTILATING	STEEL SASH

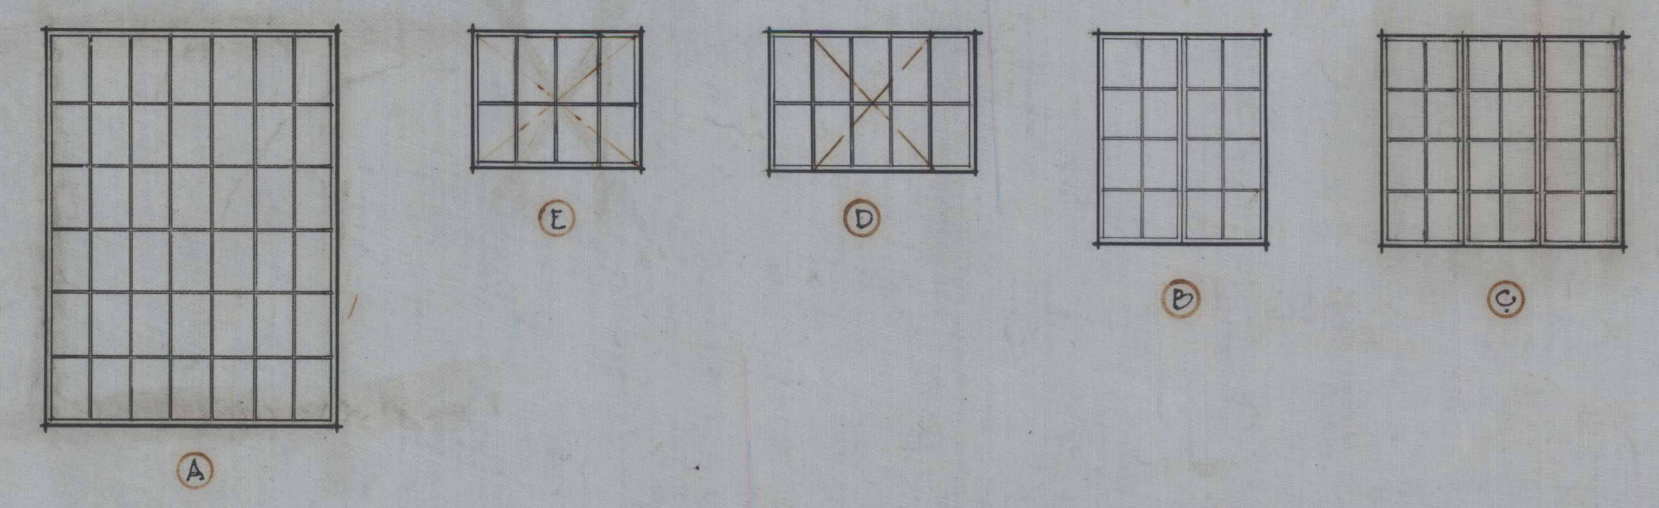



WIRING NOTES
 WIRING SYMBOLS ARE AS ACCEPTED BY THE NATIONAL ELECTRICAL CONTRACTORS ASSOCIATION OF THE UNITED STATES. NUMBERS IN CIRCLES INDICATE WATTAGE ON THE BASIS OF 1:80 WATT.

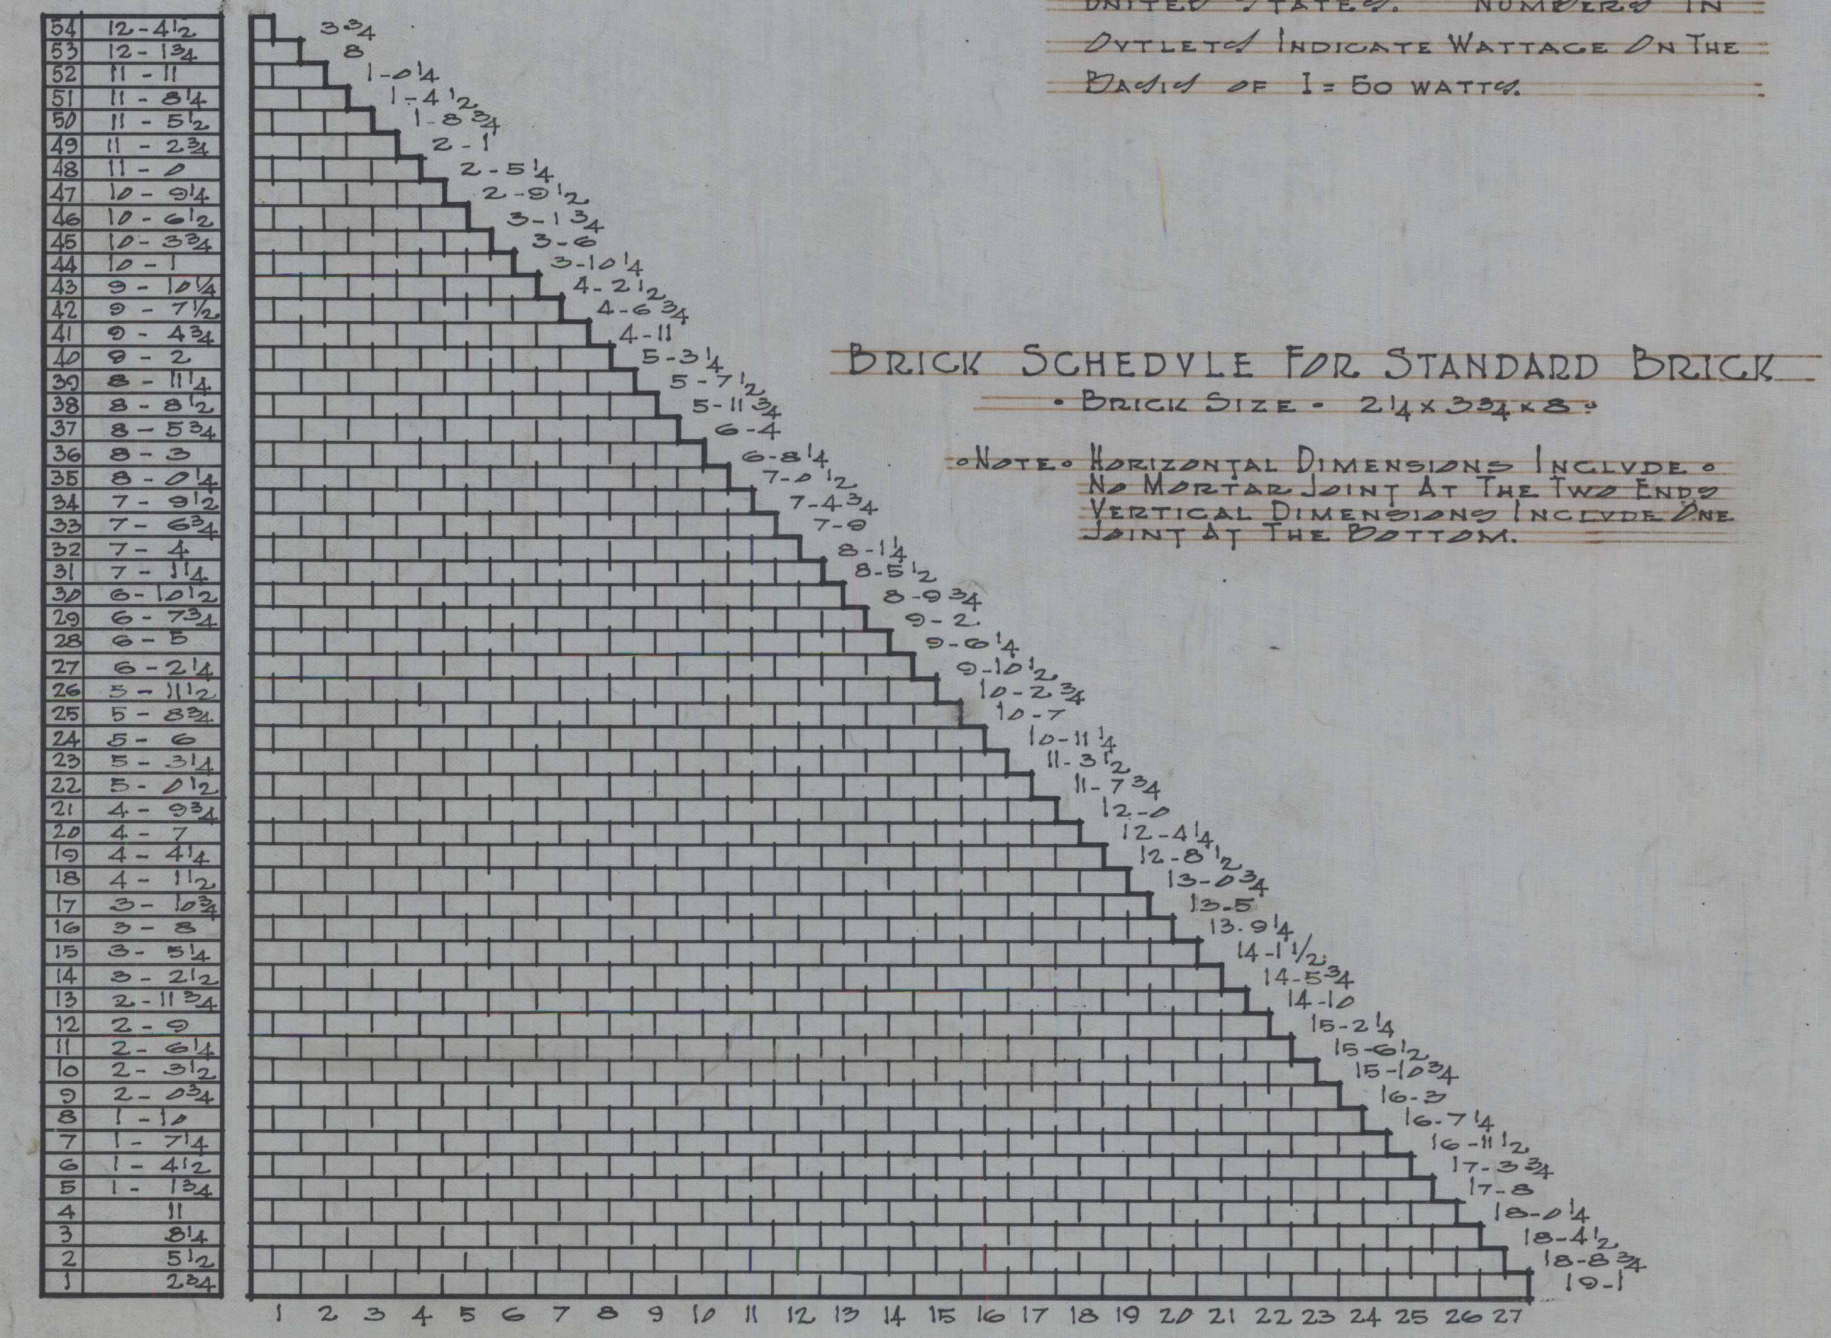

BRICK SCHEDULE FOR STANDARD BRICK
 BRICK SIZE - 2 1/4 x 3 1/2 x 8
 NOTE: HORIZONTAL DIMENSIONS INCLUDE NO MORTAR JOINT AT THE TWO ENDS. VERTICAL DIMENSIONS INCLUDE ONE JOINT AT THE BOTTOM.

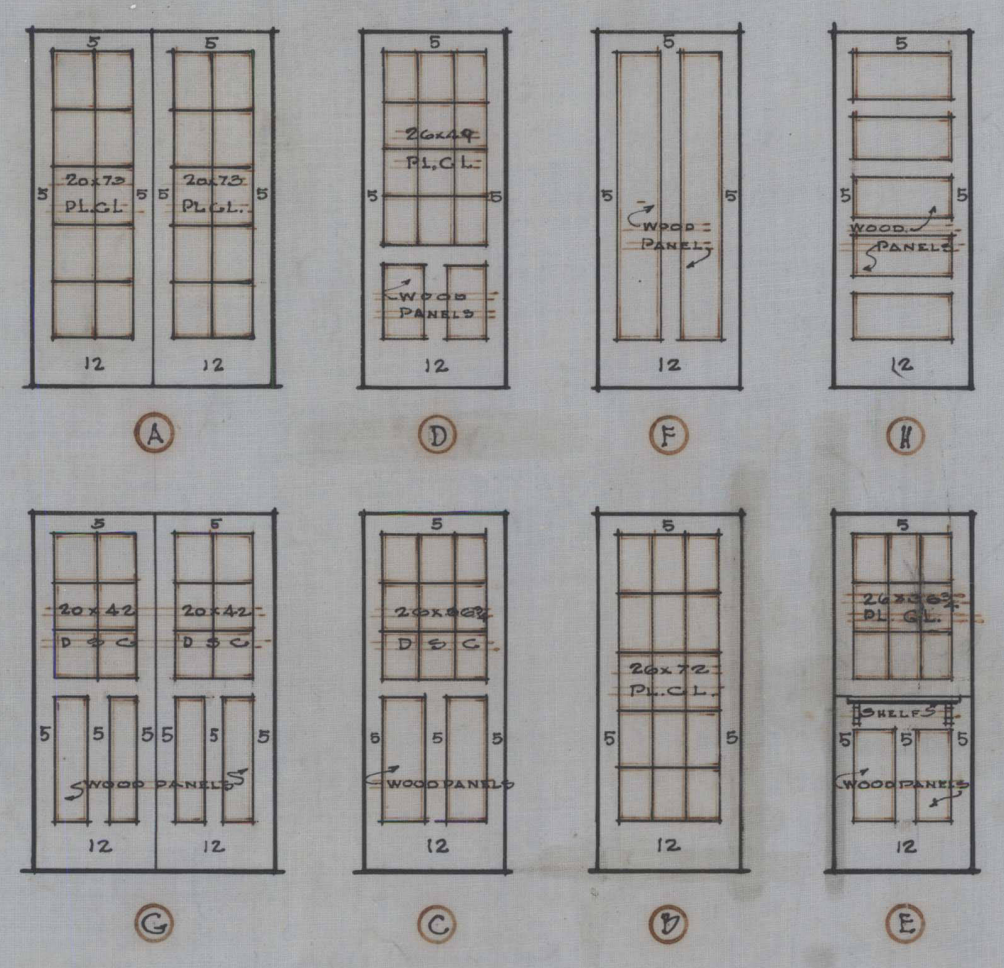

DOOR SCHEDULE				
MARK	SIZE	TYPE	KIND	REMARKS
A	5-0 x 7-0 x 2 1/4	DOUBLE	GLAZED	PL. GL.
D	5-0 x 7-0 x 2 1/4	SINGLE	GLAZED	PL. GL.
C	5-0 x 7-0 x 2 1/4	SINGLE	PANEL-GLAZED	D.S.G.
E	5-0 x 7-0 x 2 1/4	SINGLE	PANEL-GLAZED	PL. GL.
F	5-0 x 7-0 x 2 1/4	SINGLE	TWO PANEL	
G	5-0 x 7-0 x 2 1/4	DOUBLE	PANEL-GLAZED	D.S.G.
R	2-8 x 7-0 x 1 1/2	SINGLE	FIVE PANEL	
H	5-0 x 3-0 x 1 1/2	DOUBLE	THREE-PANEL	
I	2-8 x 3-0 x 1 1/2	SINGLE	PANELED	



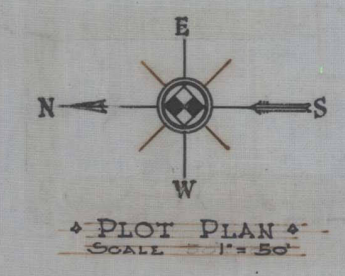
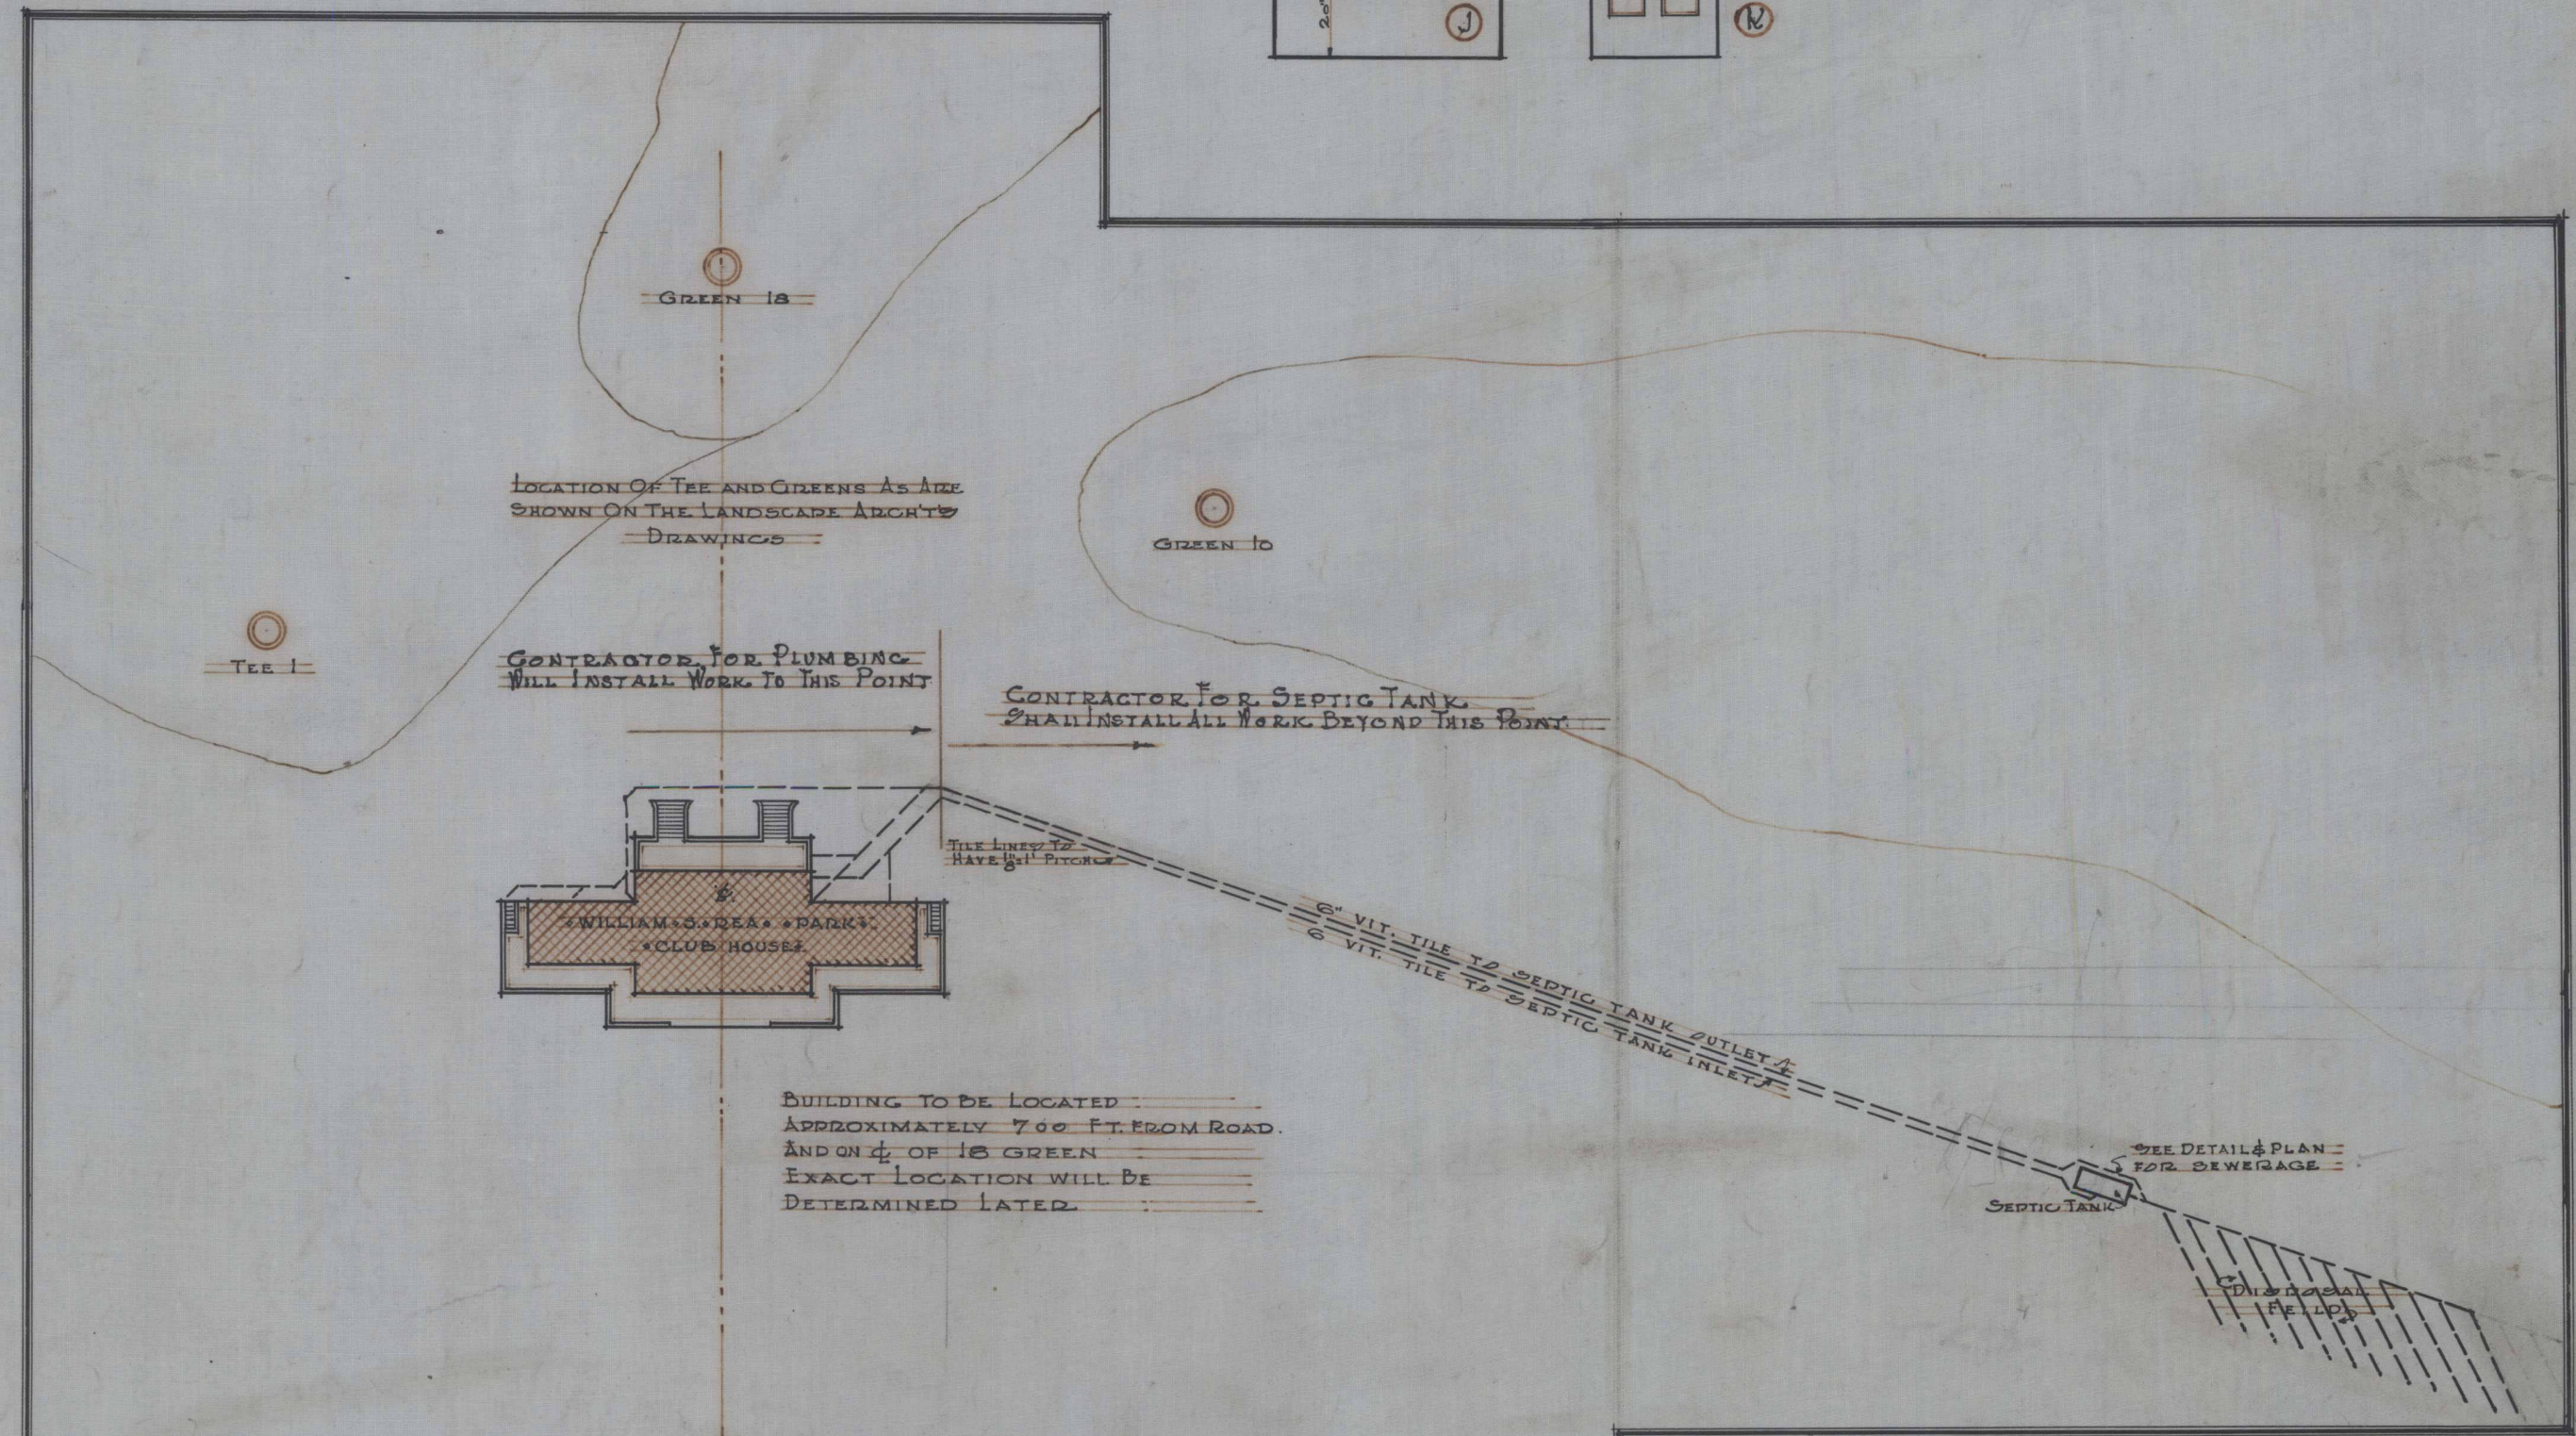


KEY TO MATERIAL	
METAL IN SECTION	[Symbol]
WOOD IN SECTION	[Symbol]
STONE IN SECTION	[Symbol]
PLASTER IN SECTION	[Symbol]
METAL IN ELEVATION	[Symbol]
STONE IN ELEVATION	[Symbol]
TILE IN SECTION	[Symbol]
BRICK IN SECTION	[Symbol]


ABBREVIATIONS	
D.S.	DOWNSPOUT
D.S.G.	DOUBLE STRENGTH GLASS
PL. GL.	PLATE GLASS
C.I.	CAST IRON
G.I.	GALVANIZED IRON
CONG.	CONCRETE
W.I.	WROUGHT IRON
BR. TH.	BRASS THRESHOLD

SCALE NONE
 REG. NO. 1
 JOB NO. 890
 SHEET 1
 JOHNSON, MILLER, MILLED, & YEAGER, ARCHITECTS
 TERRE HAUTE, INDIANA


NOTE
 DATUM WHICH IS TO BE APPROXIMATELY 2'-0" ABOVE HIGH POINT OF KNOLL ON WHICH BUILDING IS TO BE LOCATED. EXACT LEVELS TO BE DETERMINED WHEN CONSTRUCTION IS STARTED.
 LEVELS FROM -4'-6" INDICATES FUTURE FINISHED GRADES.

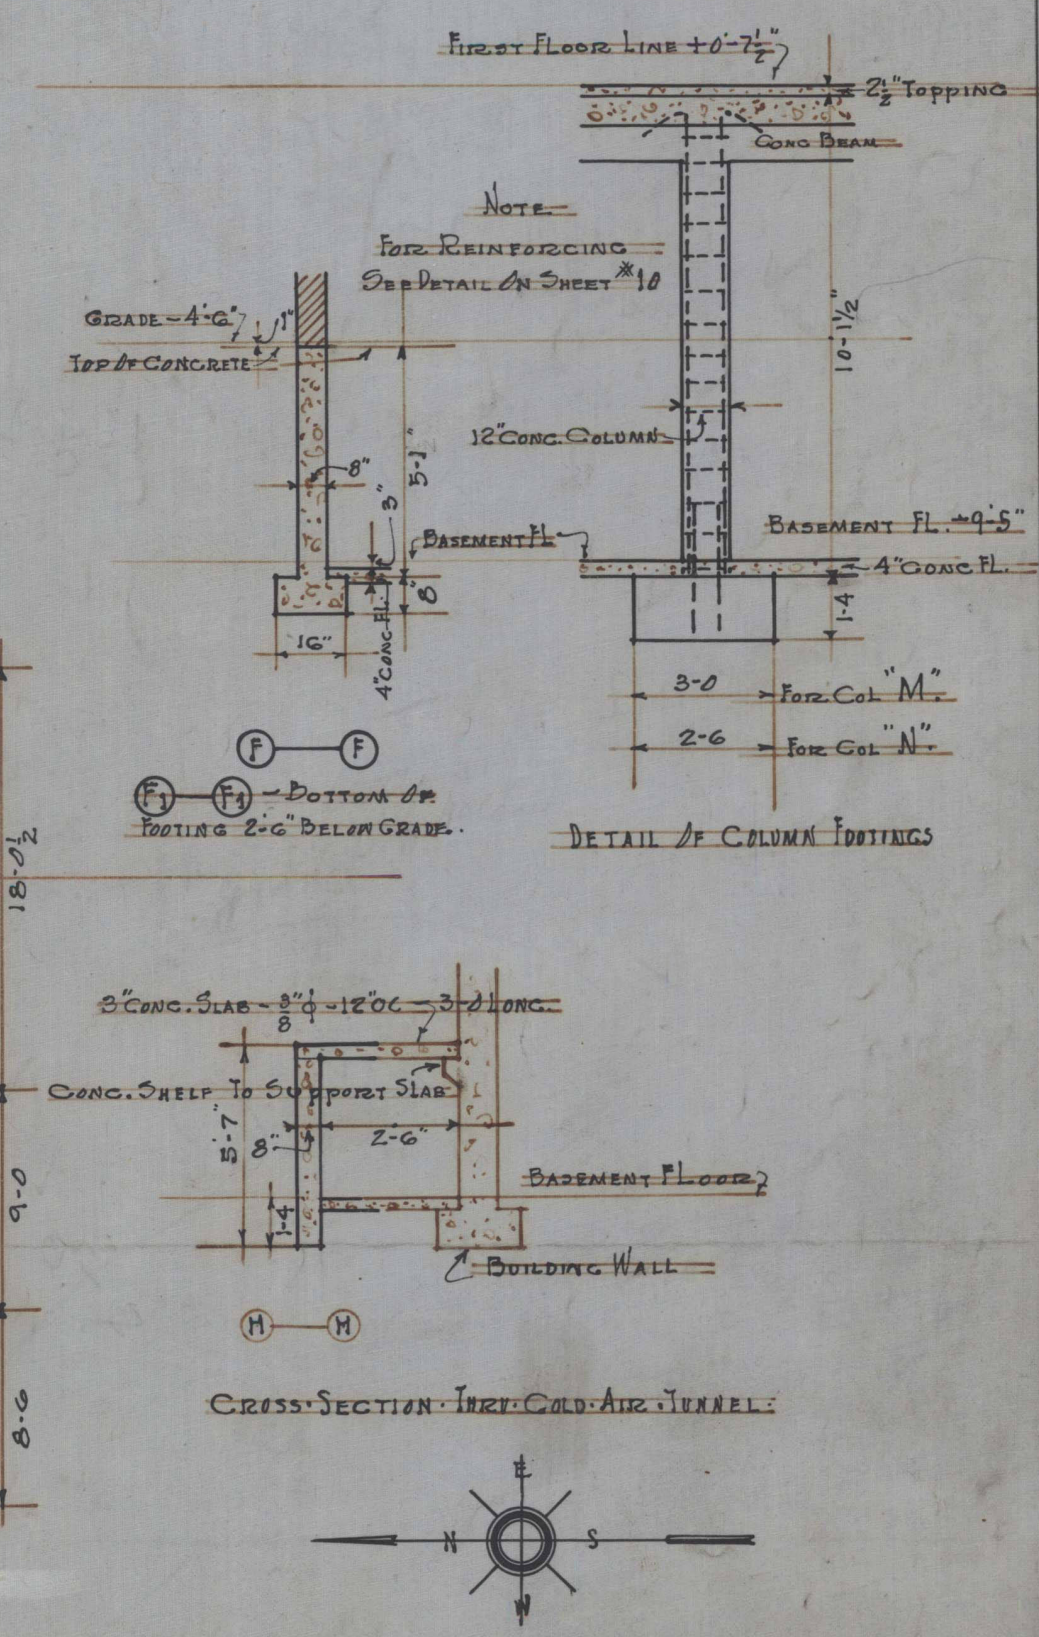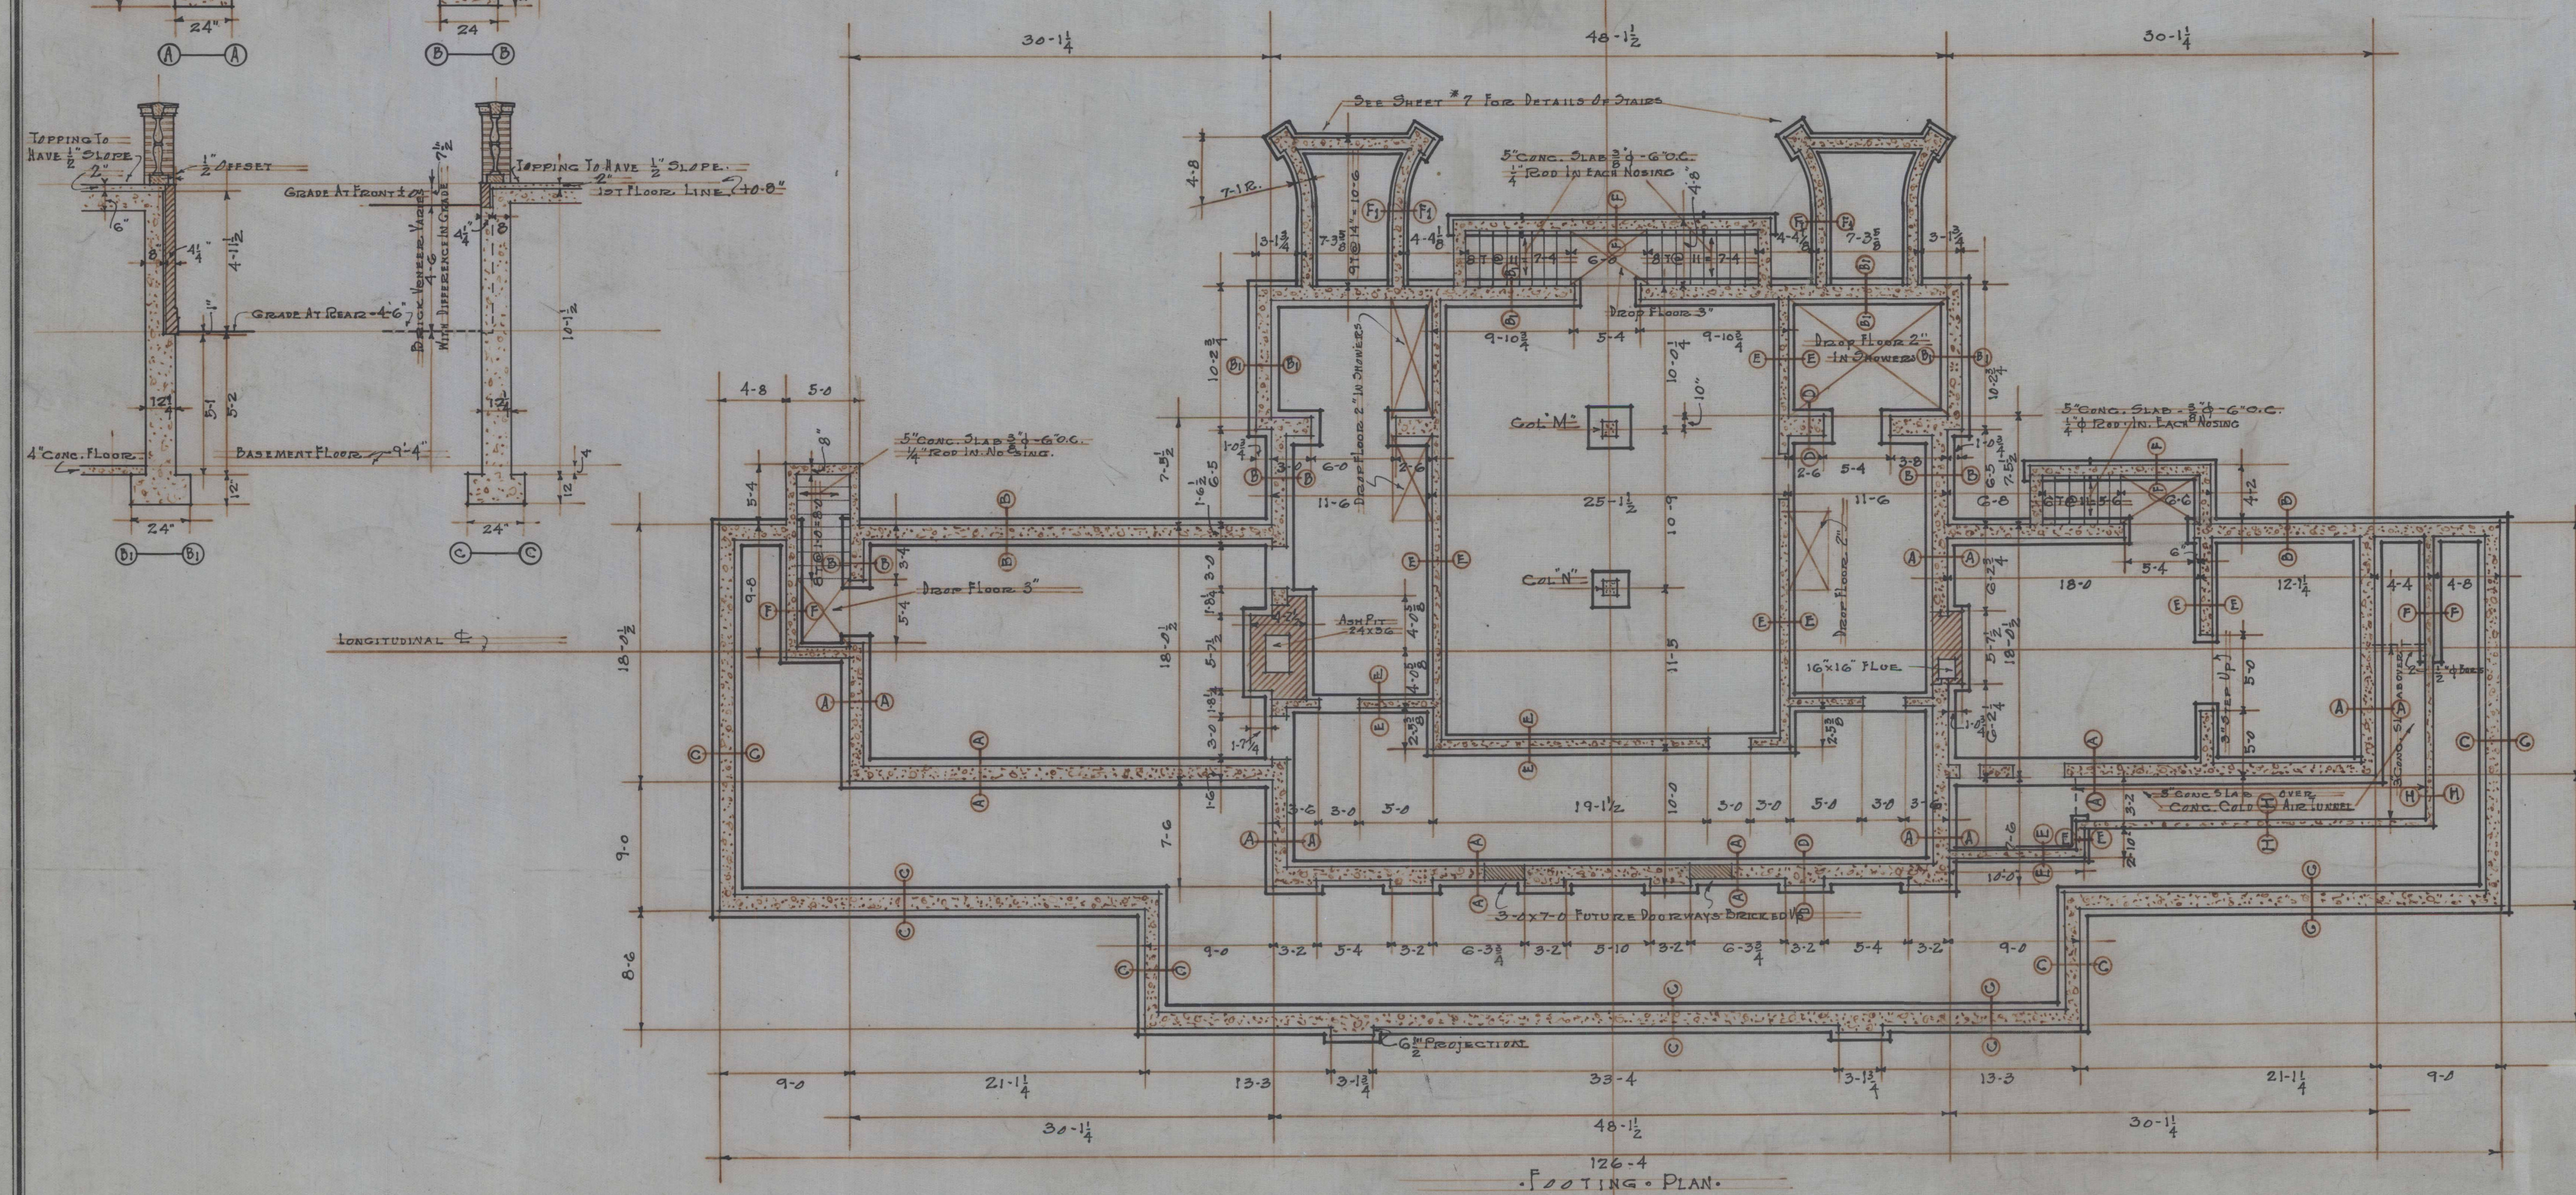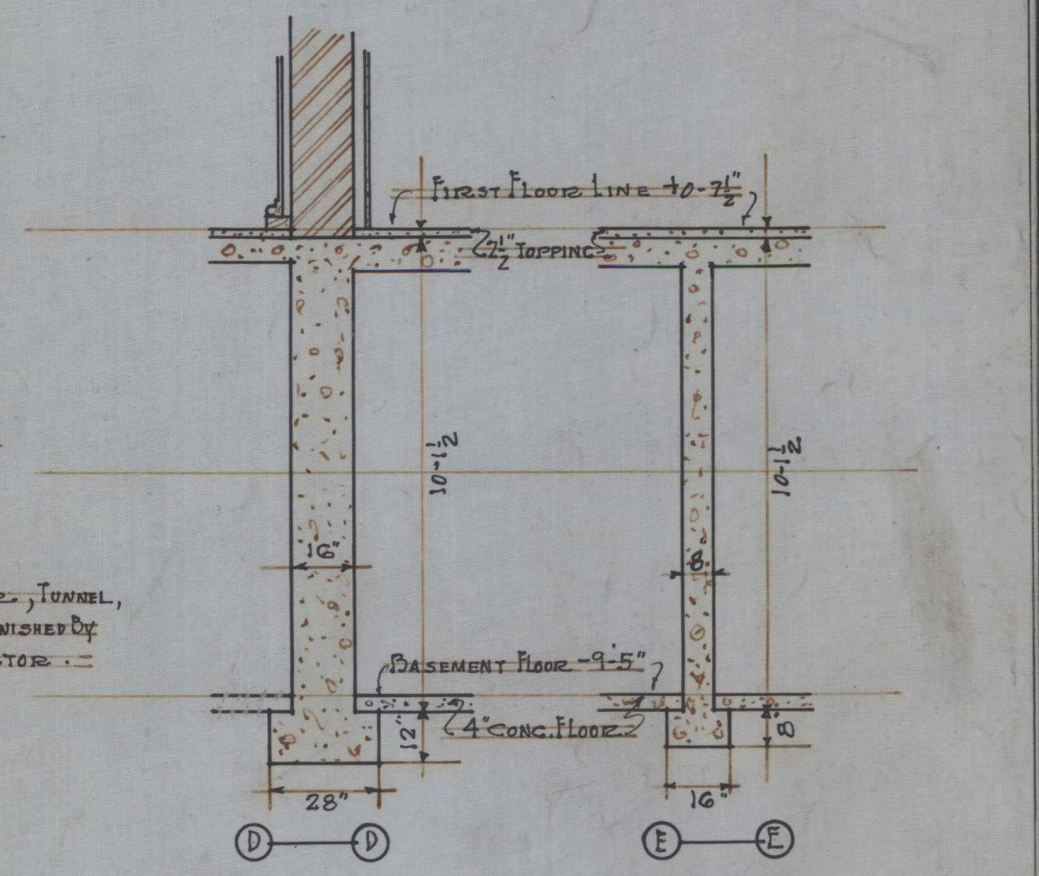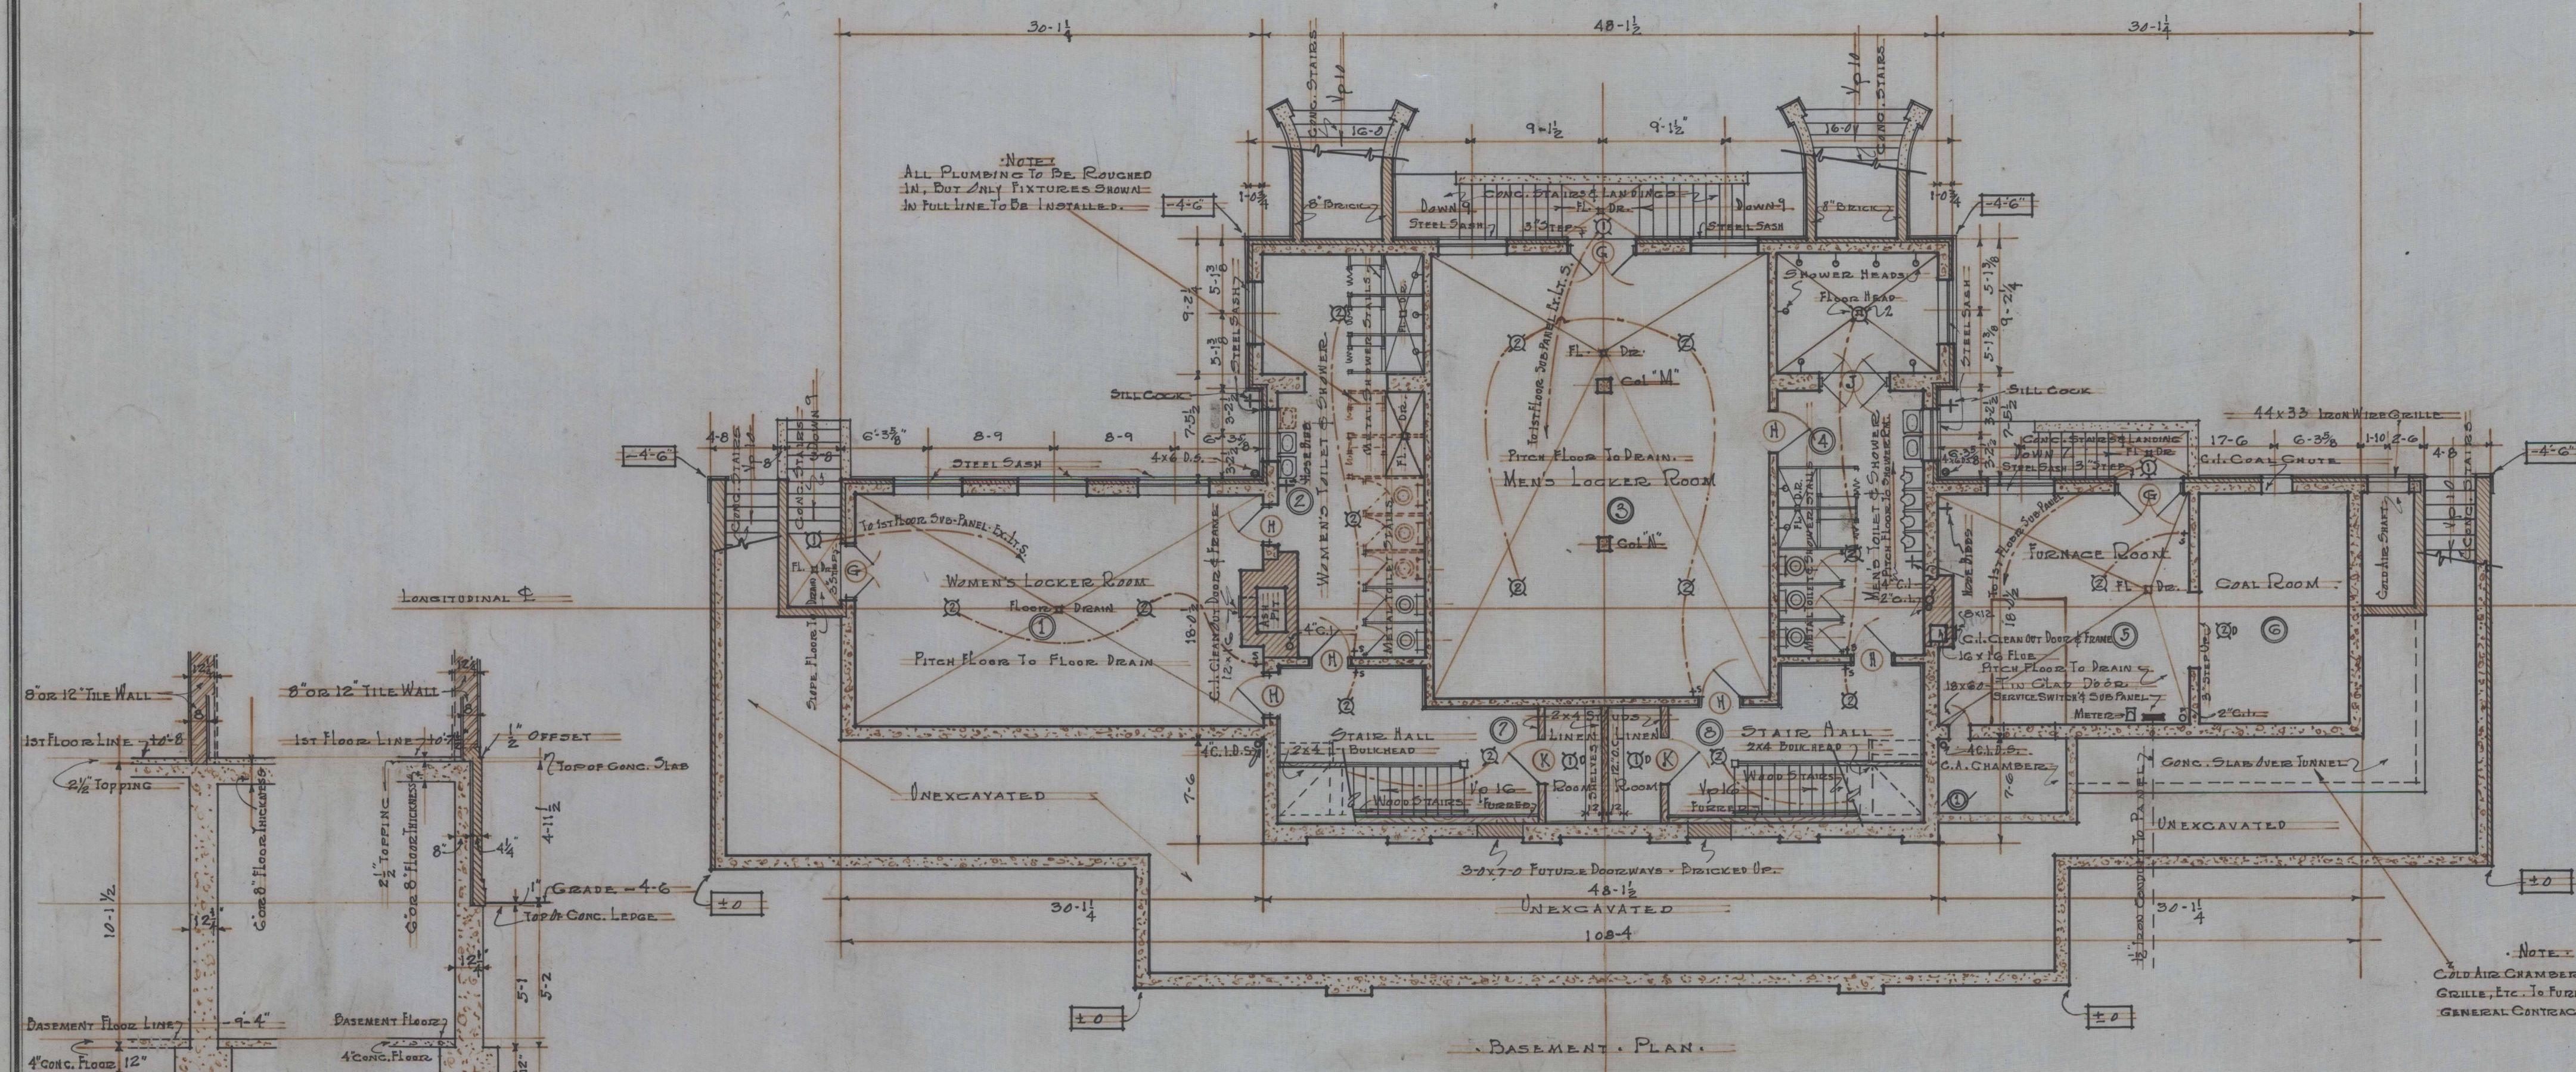

SCALE VARIES	FOOTING & BASEMENT PLANS	DATE 12-1-24
A.L.V. A.L.V.	CLV & HOVSE	JOB NO 800
D.O.V. W.D.M.	WILLIAM S. DEEA-PARL	SHEET 2
JOHNSON MILLER, MILLED & YEAGER, ARCHITECTS		
TERRE HAUTE, INDIANA		

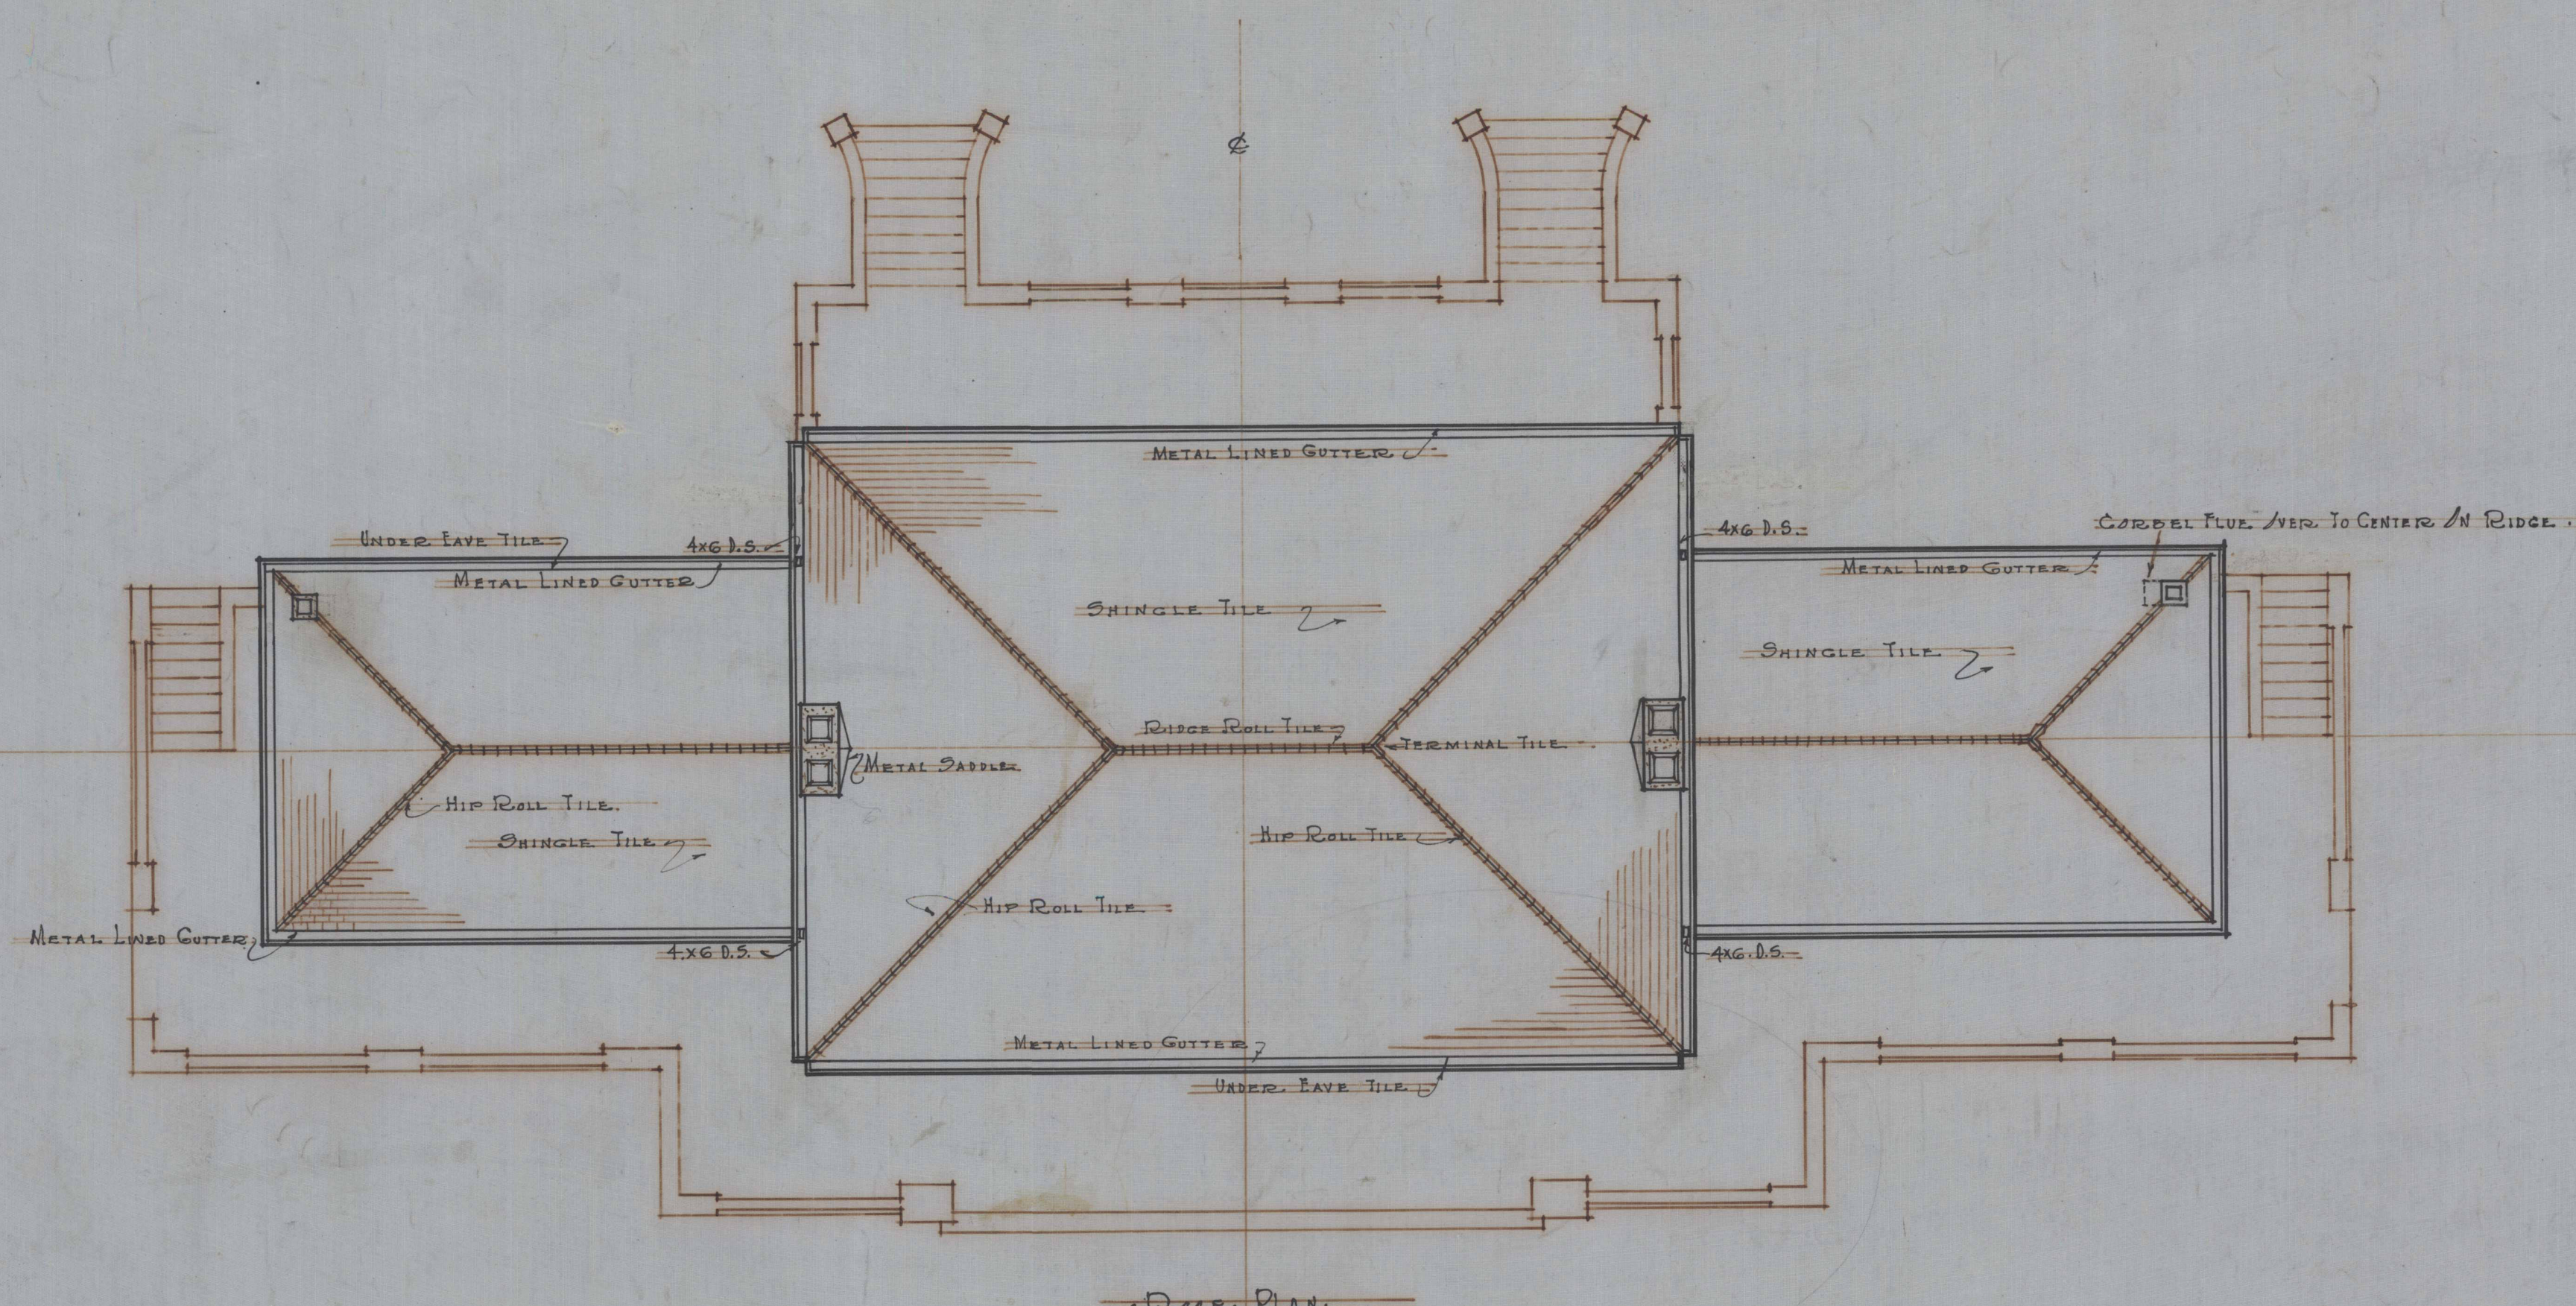


ROOF PLAN


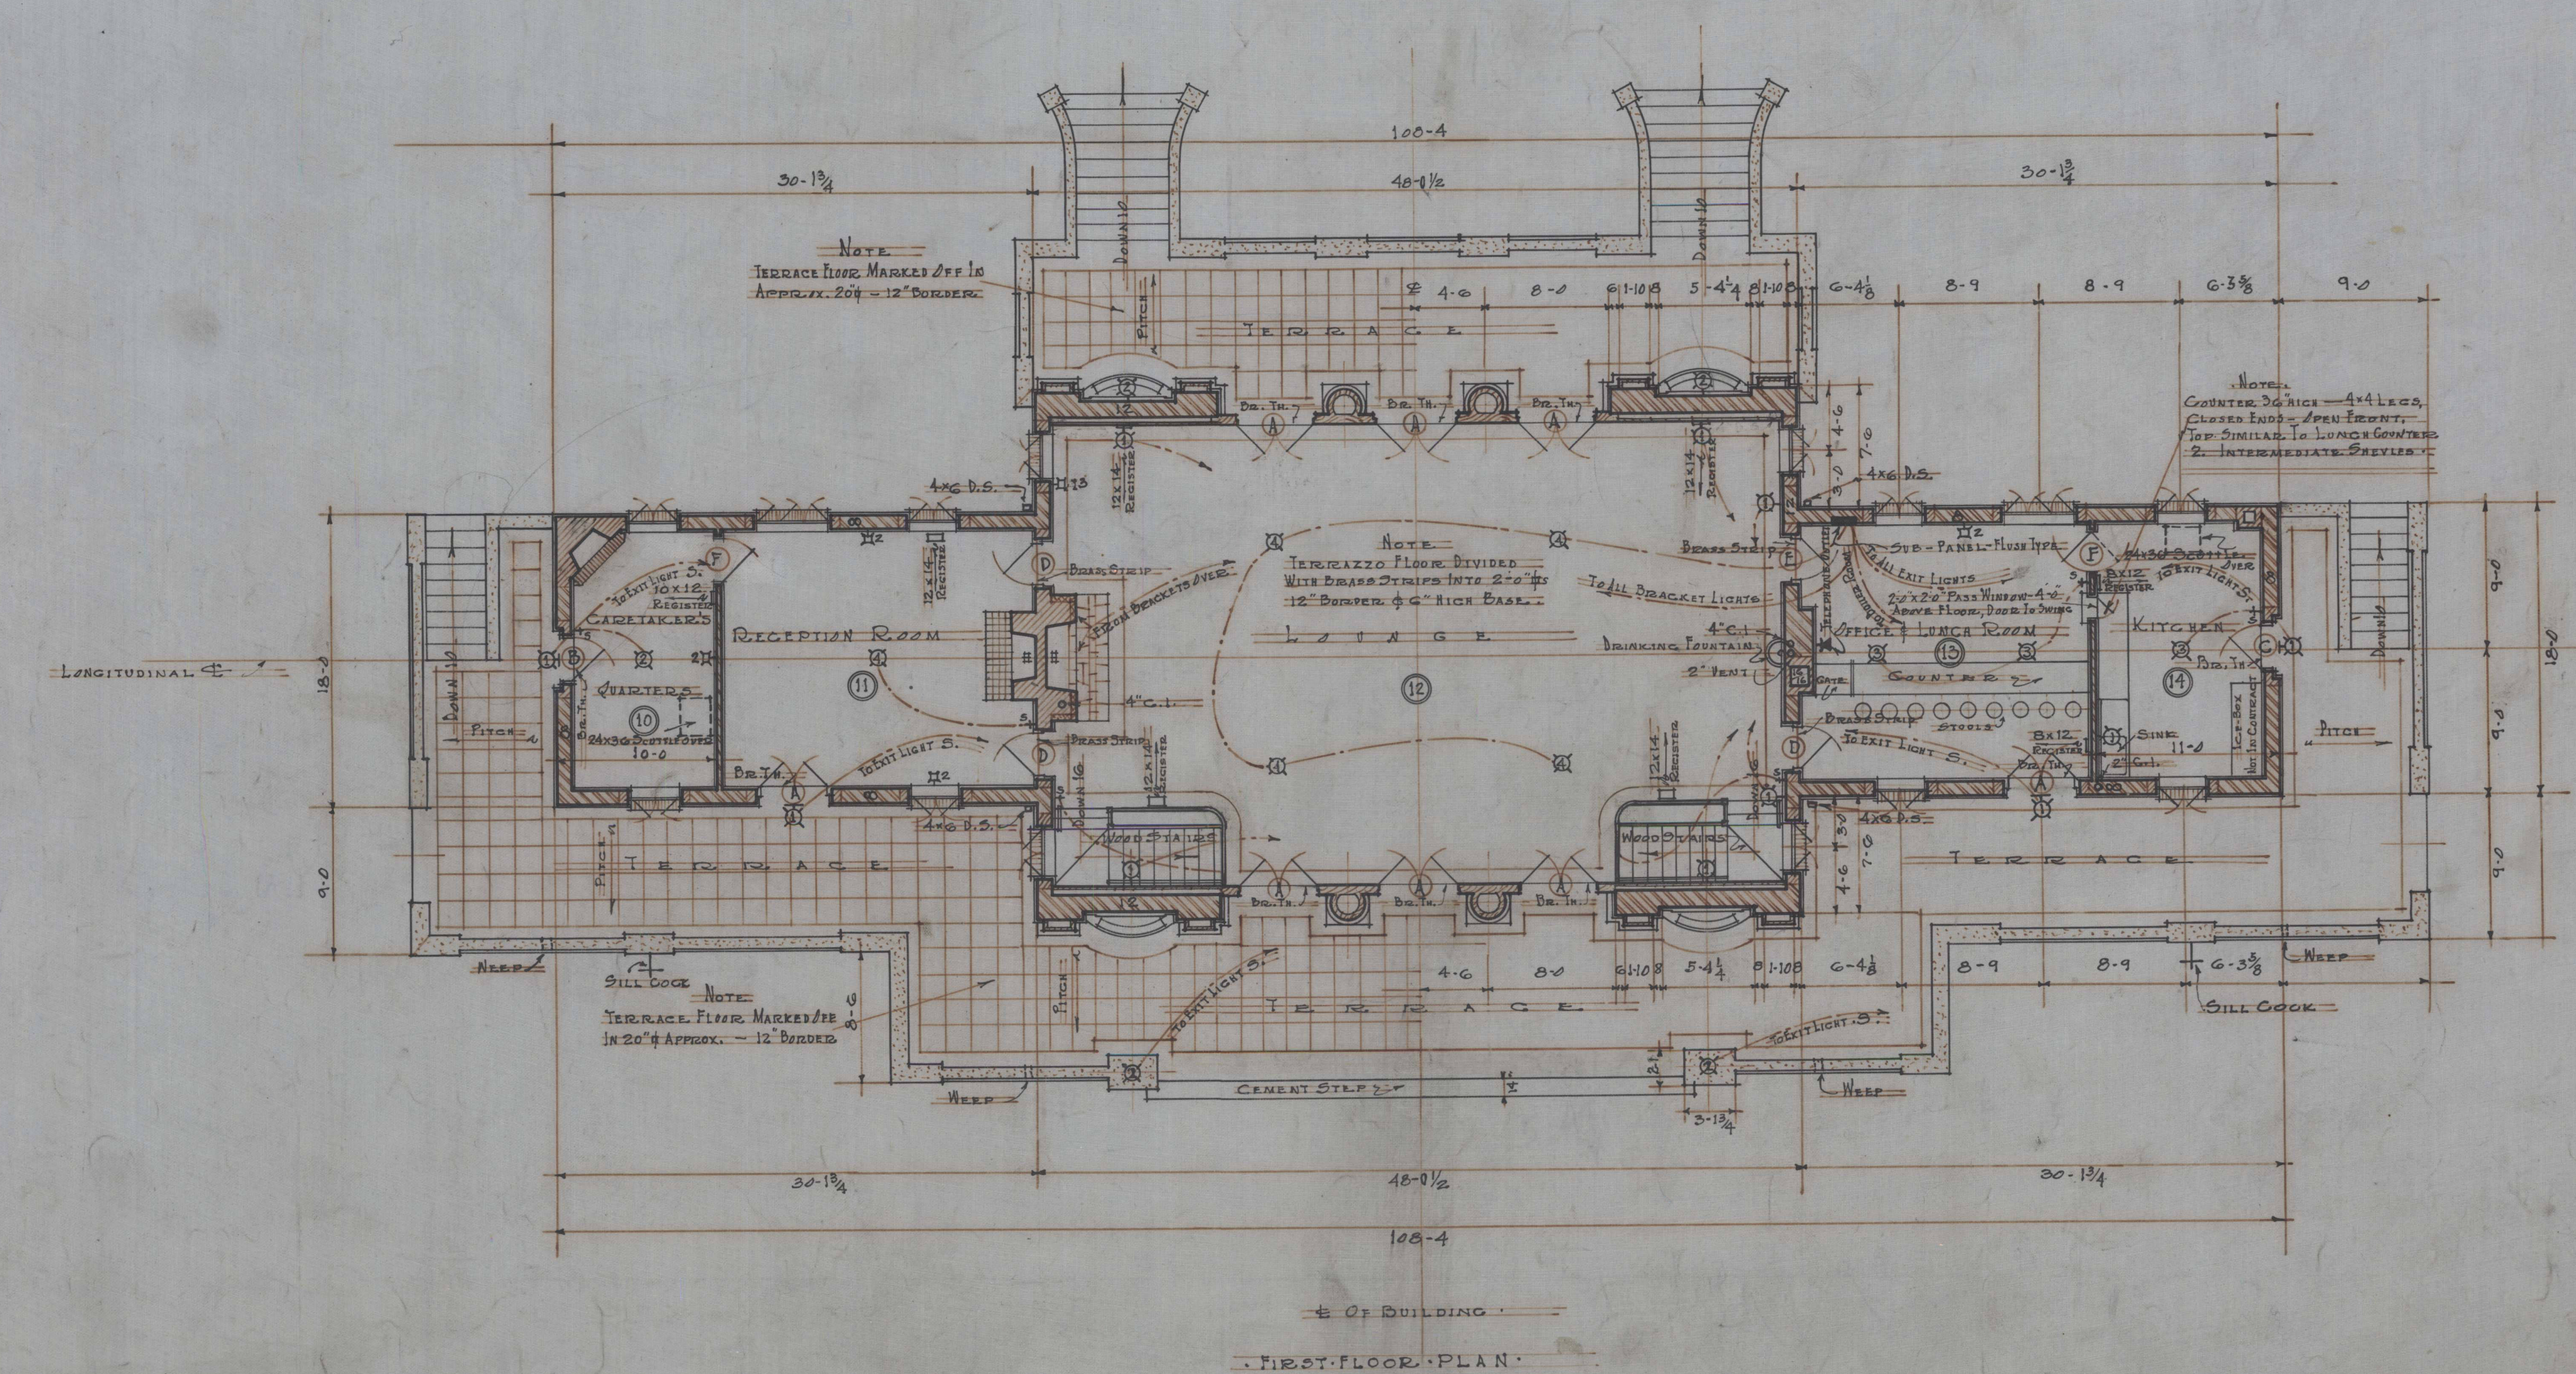


FIRST FLOOR PLAN


NOTE:
 ALL DIMENSIONS IN 1st FLOOR PLAN TAKEN IN
 FINISHED STUCCO LINE
 LIGHT STEEL OVER OPENINGS IN
 8" WALLS - 2" 3/4 x 3" 1/4
 IN 4" WALLS - 1" 3/4 x 3" 1/4
 EXCEPT AS NOTED.

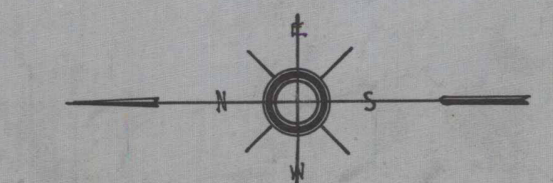

SCALE 1/4" = 1'-0"	FLOOR PLANS	DATE 12-1-24
ALY. ALY.	CLIVE HOUSE	JOB NO 500
R.H. #11	FOR WILLIAM S. DEA-PARK TERRY HAYTE	SHEET 3
JOHNSON MILLER MILLED, S. YEAGER, ARCHITECTS TERRY HAYTE, INDIANA		

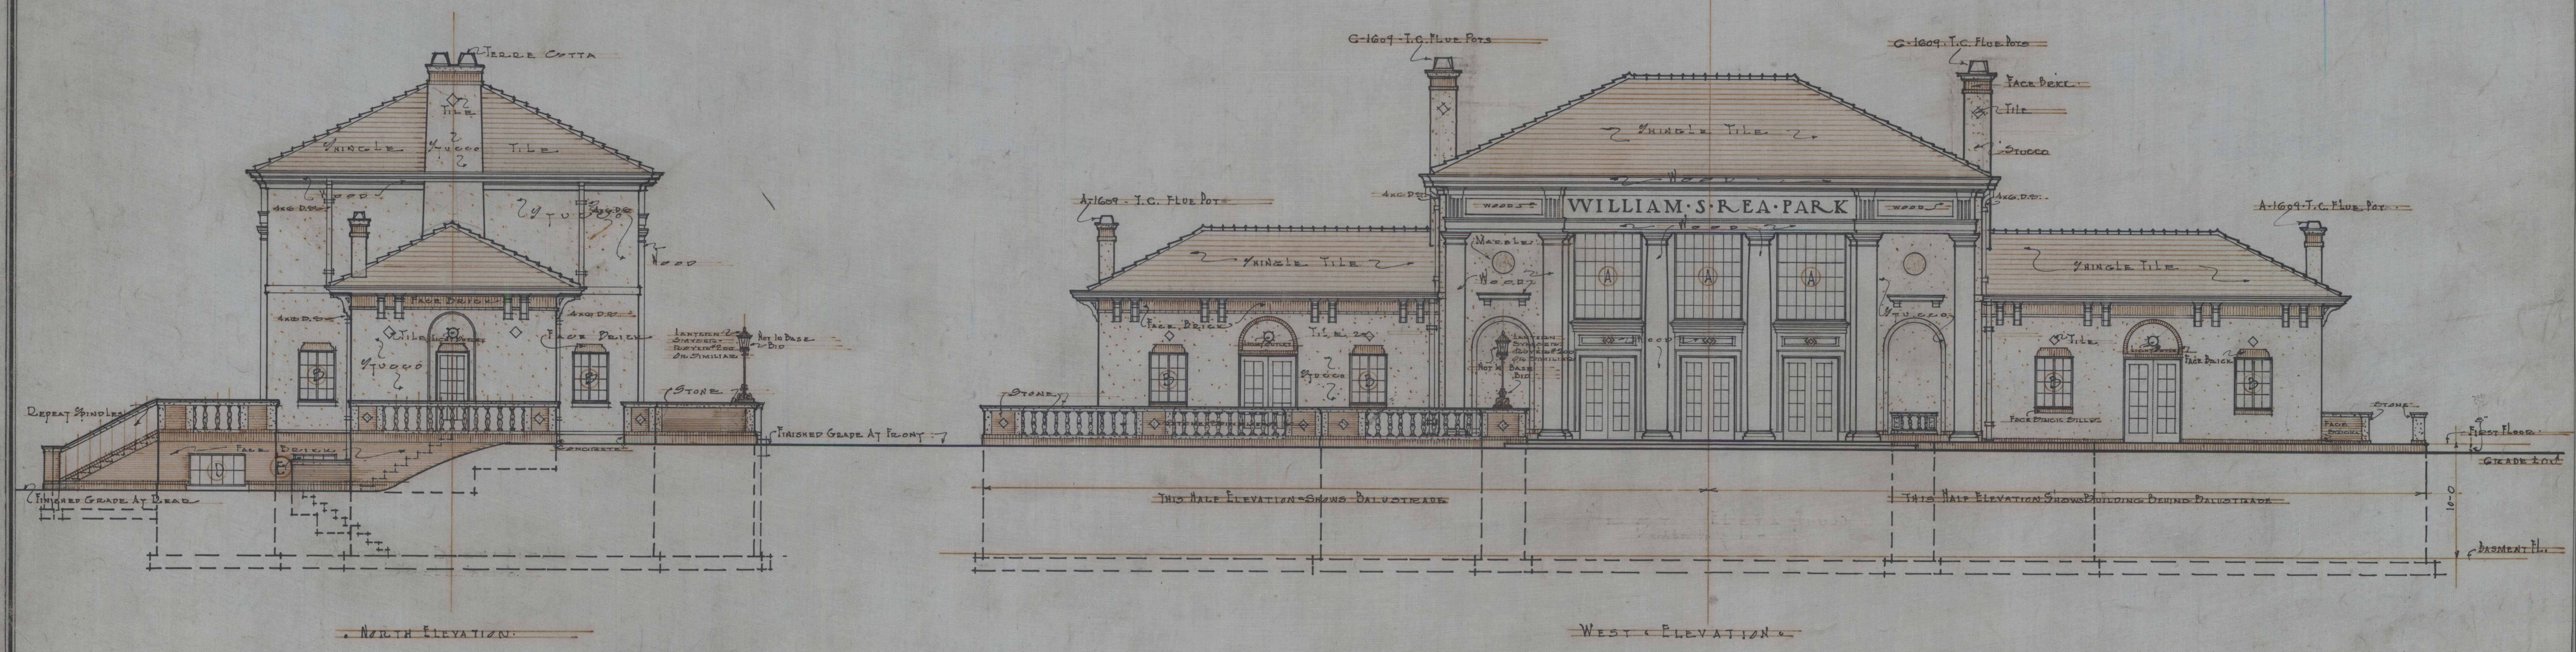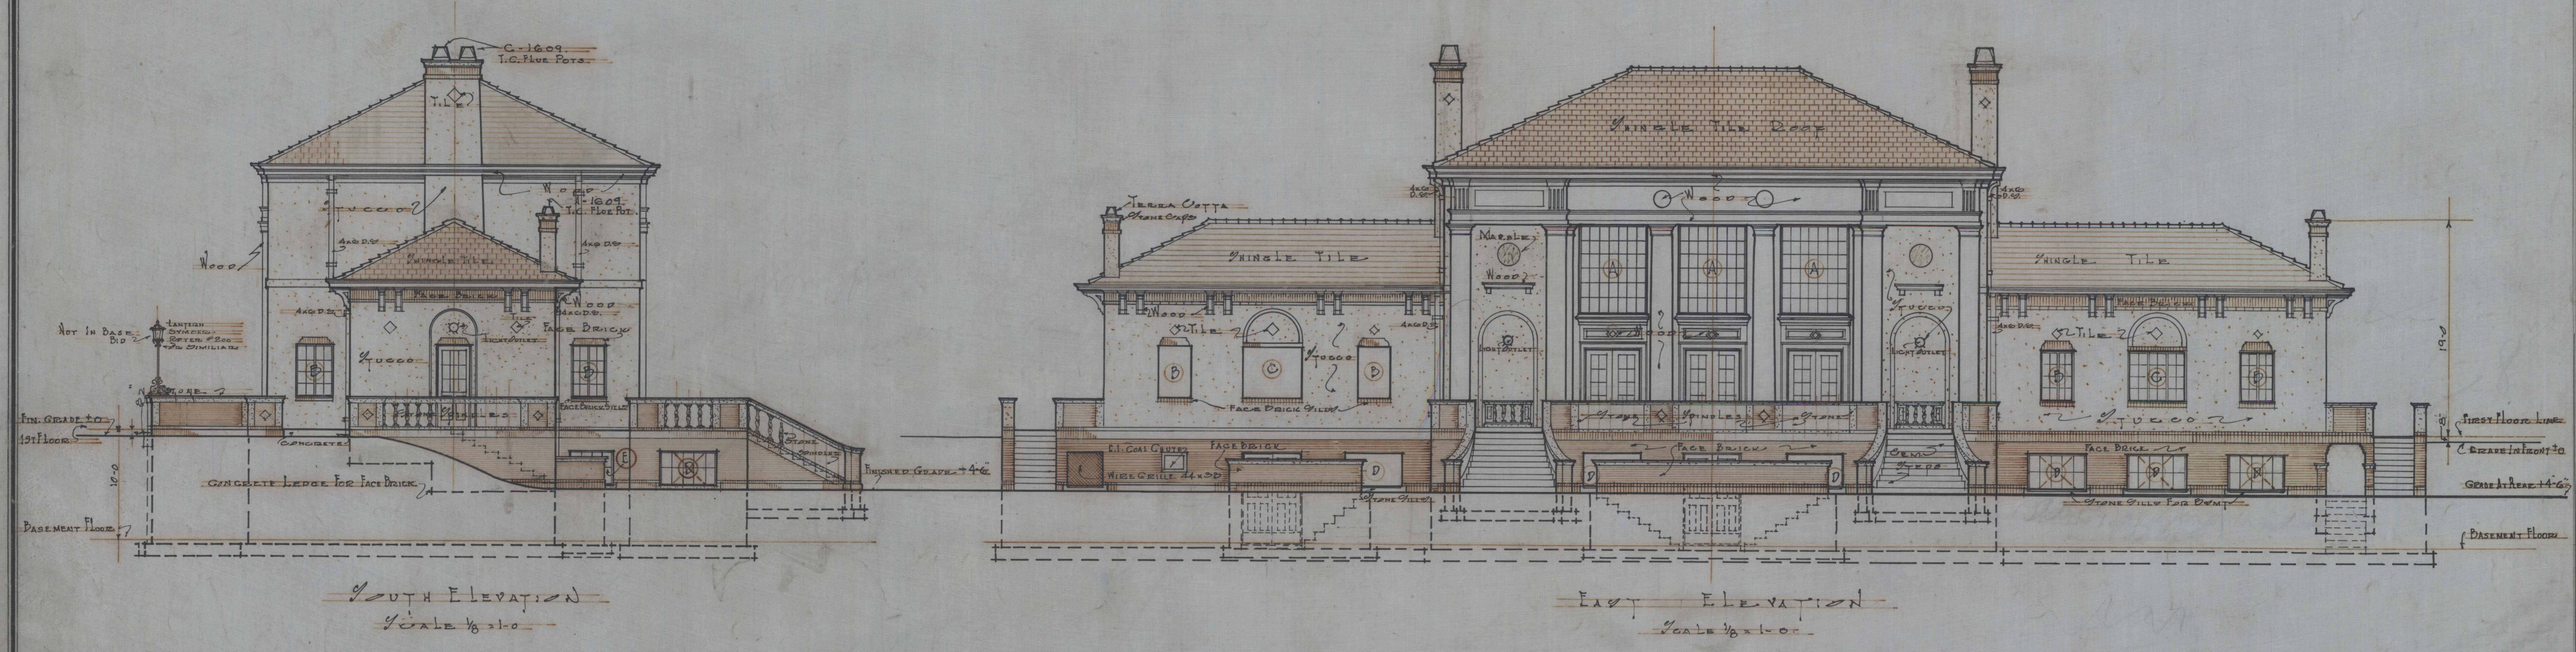




SCALE 1/8" = 1'-0"	ELEVATIONS	DATE 12-1-24
ROY-H-S	CLUB HOUSE	JOB NO 500
R.O.Y.-W.D.M.	FOR	SHEET 4
WILLIAM S. REA PARK		
TERRE HAUTE, INDIANA		
JOHNSON, MILLER, MILLER & YEAGER, ARCHTS		
TERRE HAUTE, INDIANA		

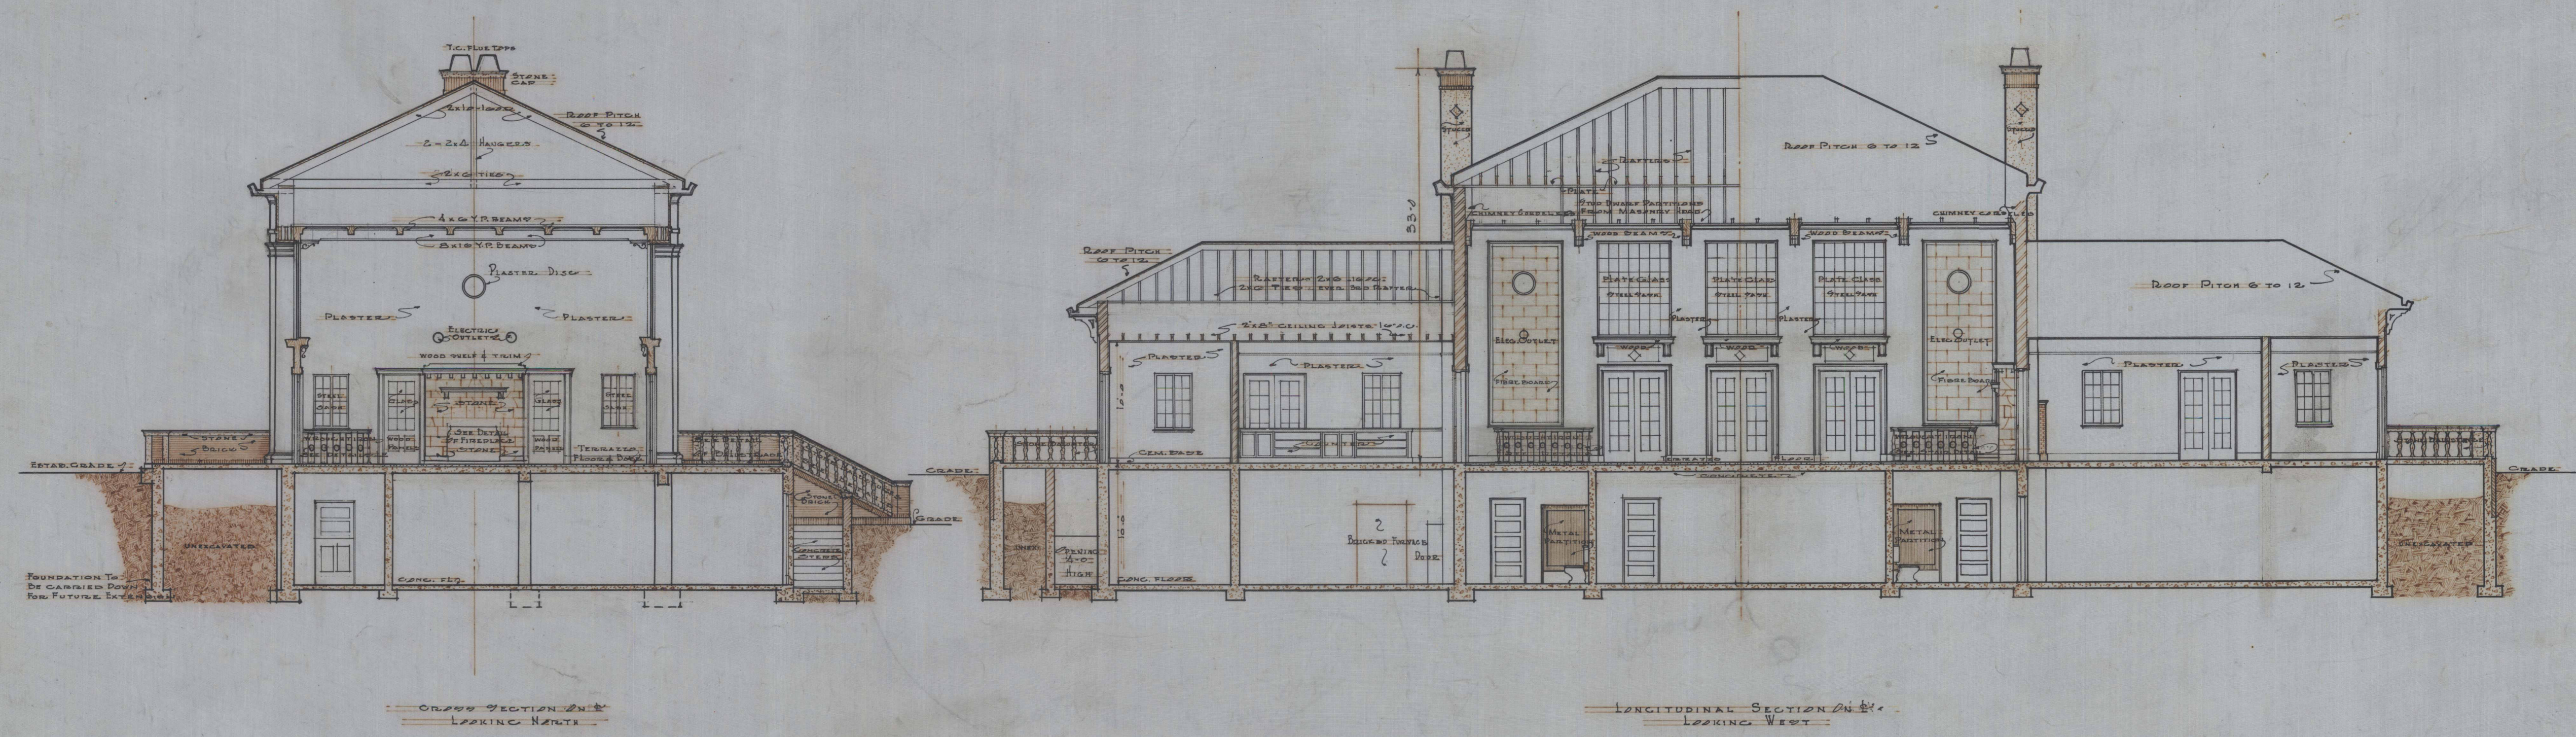

SCALE $\frac{1}{8}'' = 1'-0''$	• SECTIONS •	DATE 12-1-24
R.O.V. H.C.	CLIVE HOYSE	JOB NO 890
R.O.V. W.O.M.	WILLIAM S REA PARK	TERRACE HAVEN
JOHNSON MILLER MILLER & YEAGER, ARCHITECTS		SHEET 5
TERRACE HAVEN, INDIANA		



A PARK
 BRONZE LETTERS OR WOOD - SEE WEST ELEVATION

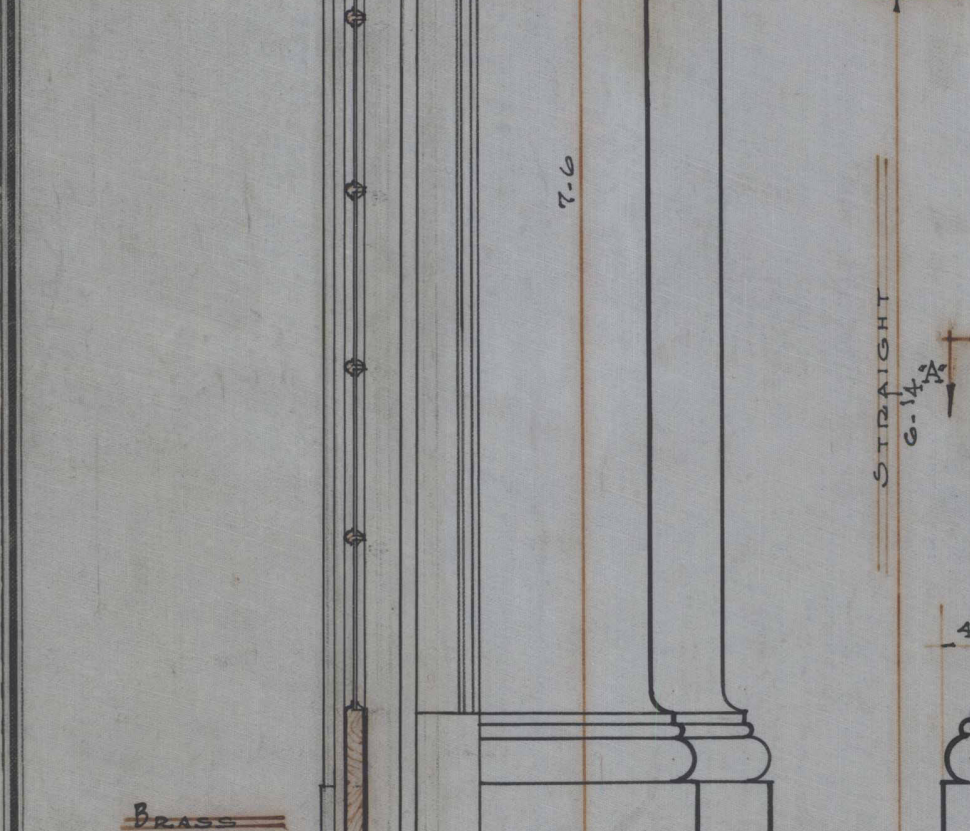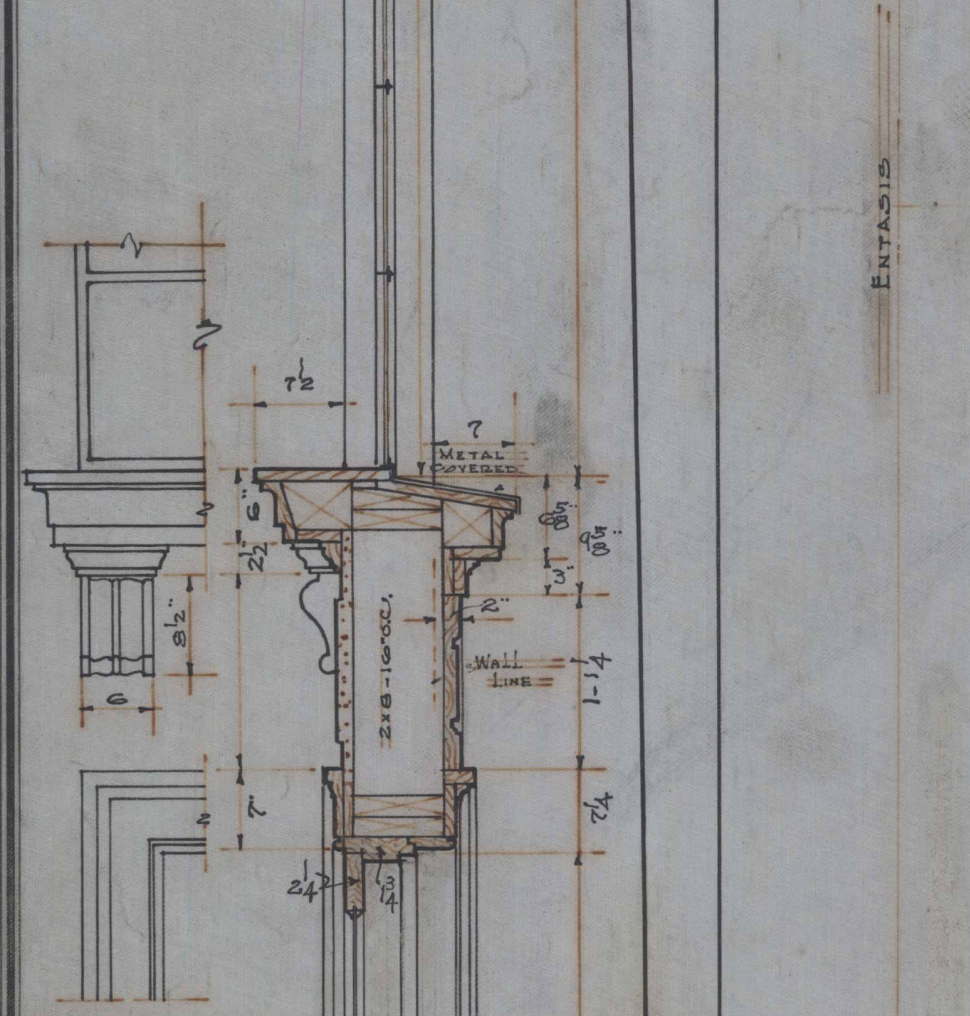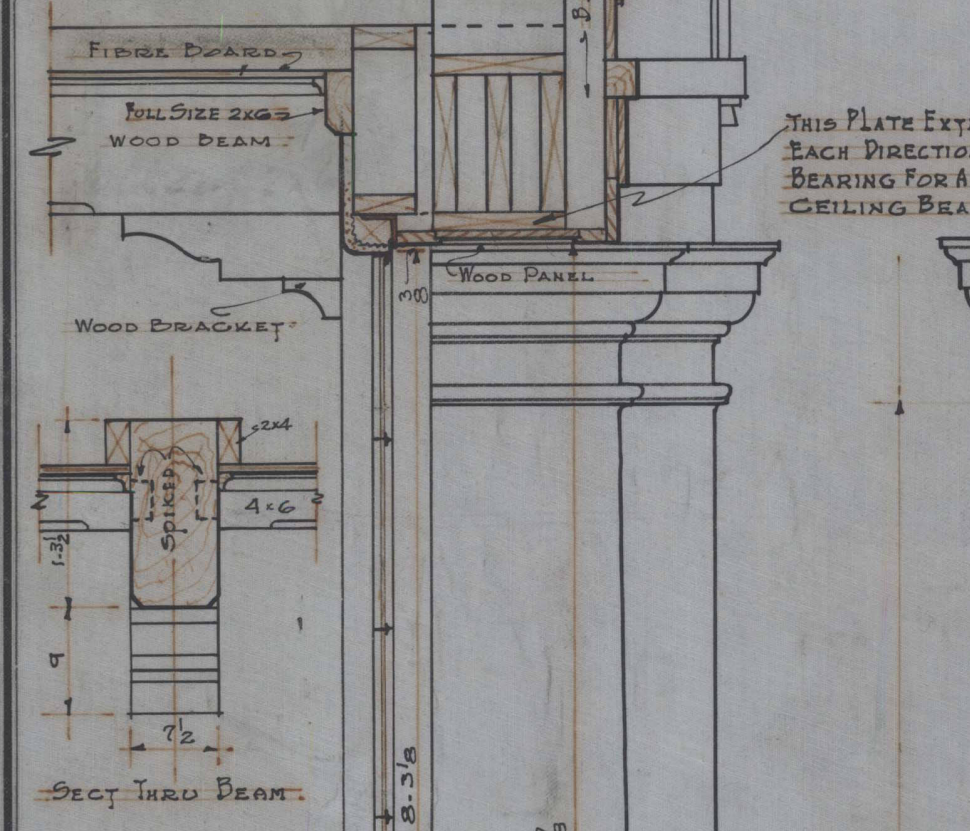


THIS PLATE EXTENDS IN EACH DIRECTION TO FORM BEARING FOR ALL 2x16 CEILING BEAMS.

TILE STEPS UP AT THIS POINT TO HEIGHT SHOWN ON DET. B.B.

Stucco
 Marble
 Stucco Panel

BRONZE TABLETS ARE NOT TO BE INCLUDED IN CONTRACT UNLESS TO BE DETERMINED BY THE ARCHITECTS.


SECTION THIRD OF FRONT DOORS - SECTION C-C - SCALE 2 1/2" = 1'-0"

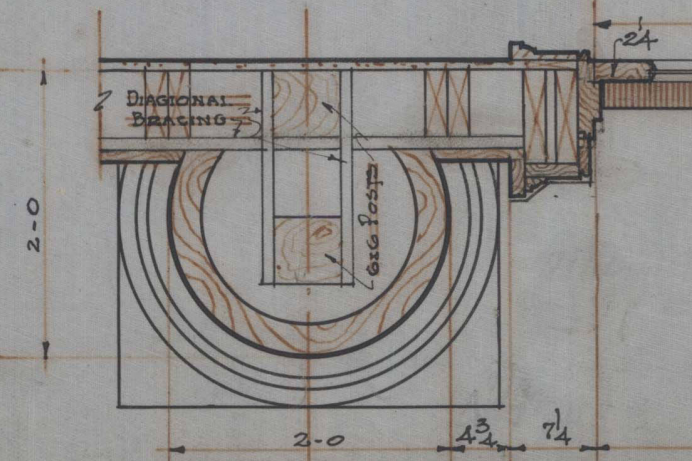

PLAN ON LINE A-A

TYPICAL DETAIL FOR ENGAGED COLUMNS

SECTION THIRD OF STUCCO PANEL - B-B



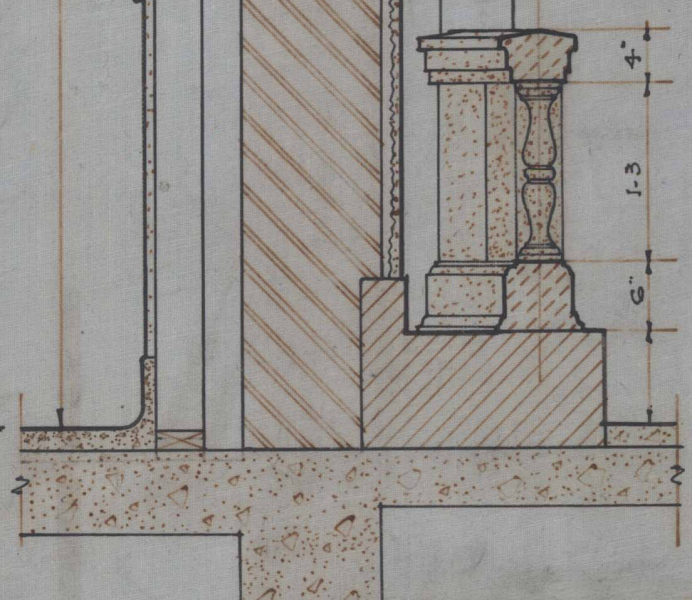


DETAIL OF WOOD MOLDING AROUND FIRE PLACE PANELS IN LOUNGE. Scale 3 1/2" = 1'-0"


SCALE VARIES	*SECTIONS, * ETC.*	DATE 12-1-24
R.G.G. A.G.G.	*CLVD. HOUSE -	JOB NO 890.
ROY. W.P.M.	*WILLIAM S. REA PARK -	SHEET 6
	*TERRE-HAUTE -	
	JOHNSON, MILLER, MILLER & YEAGER, ARCHTS.	
	TERRE-HAUTE, INDIANA.	

PLAN OF CORNER OF ROOF - C-C


REFLECTED PLAN OF CORNICHE TAKEN THROUGH FIREPLACE ON LINE F-F

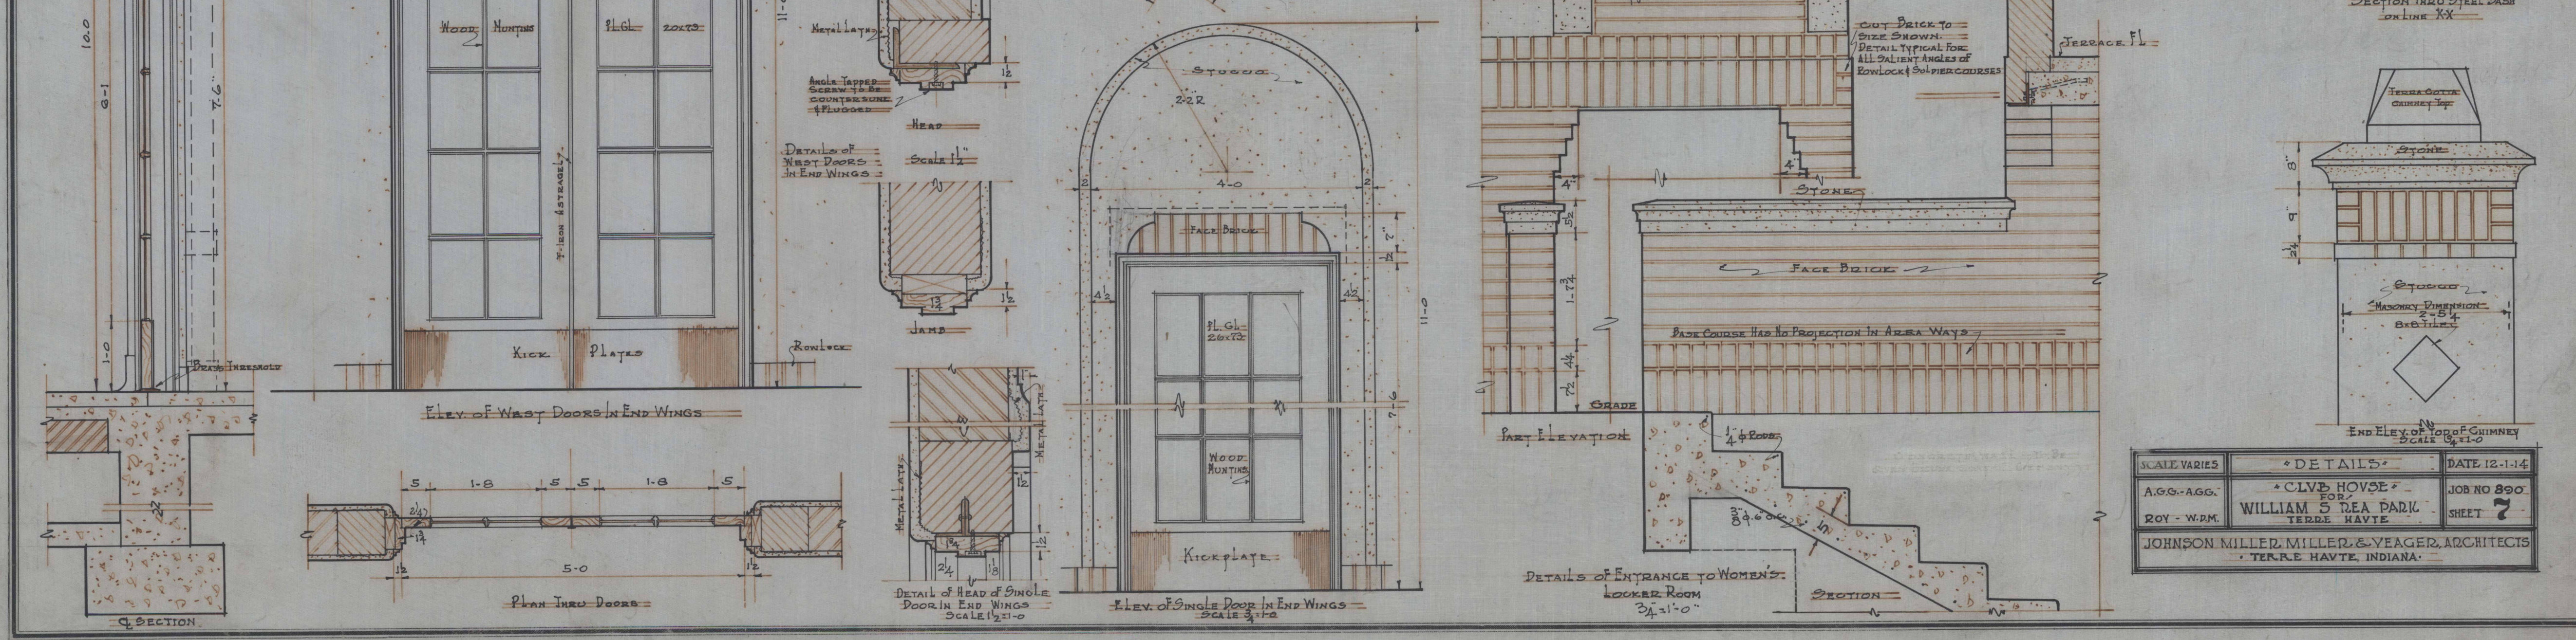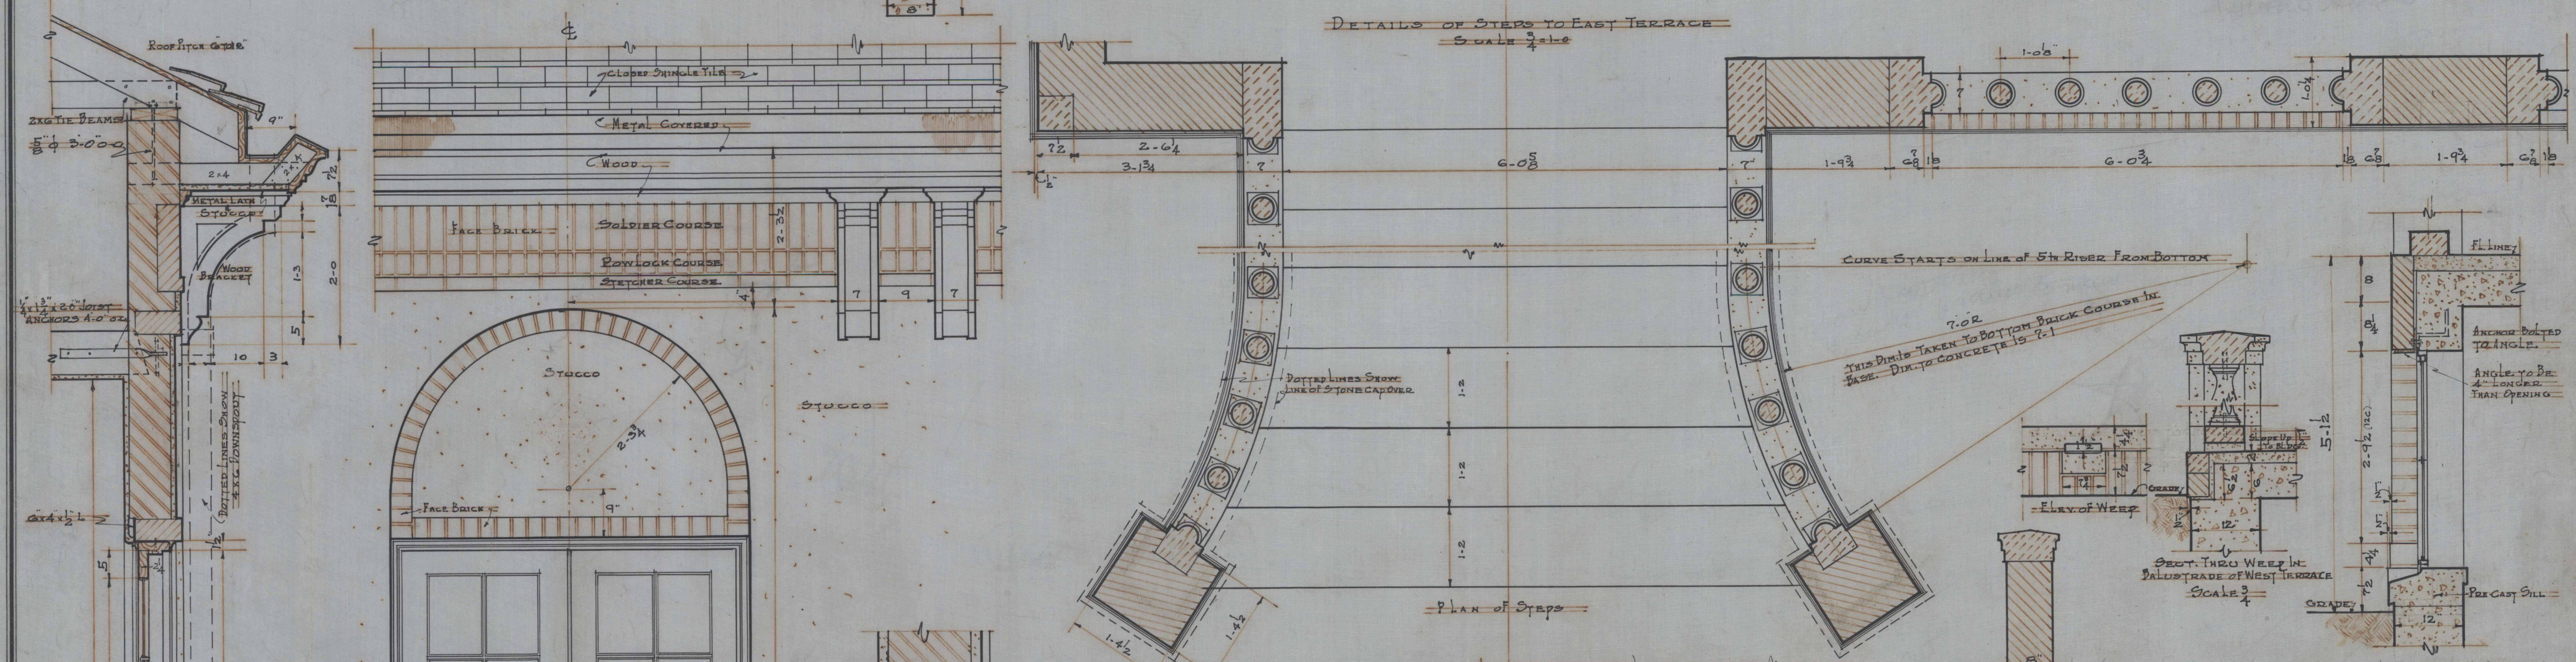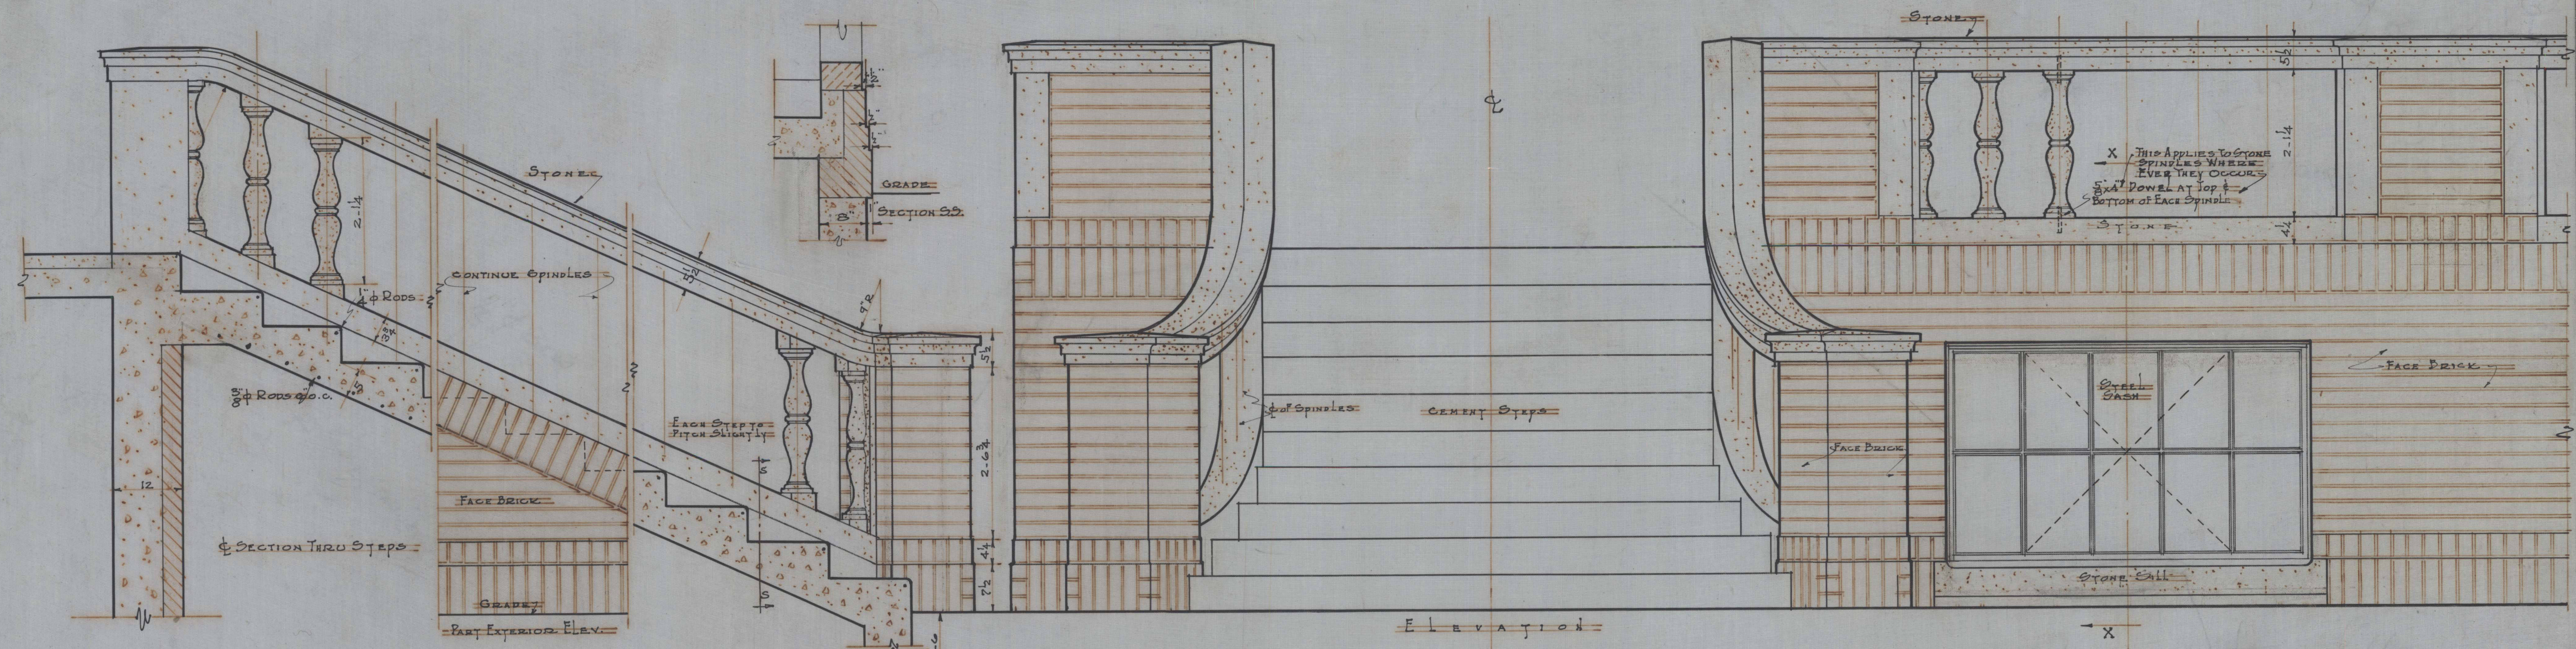


SCALE VARIES	* DETAILS *	DATE 12-1-14
A.G.C. AGG.	* CLIVE HOUSE *	JOB NO 890
ROY - W.P.M.	WILLIAM S. REA PARK	SHEET 7
	TERRE HAUTE	
JOHNSON MILLER, MILLER & YEAGER, ARCHITECTS		
TERRE HAUTE, INDIANA		

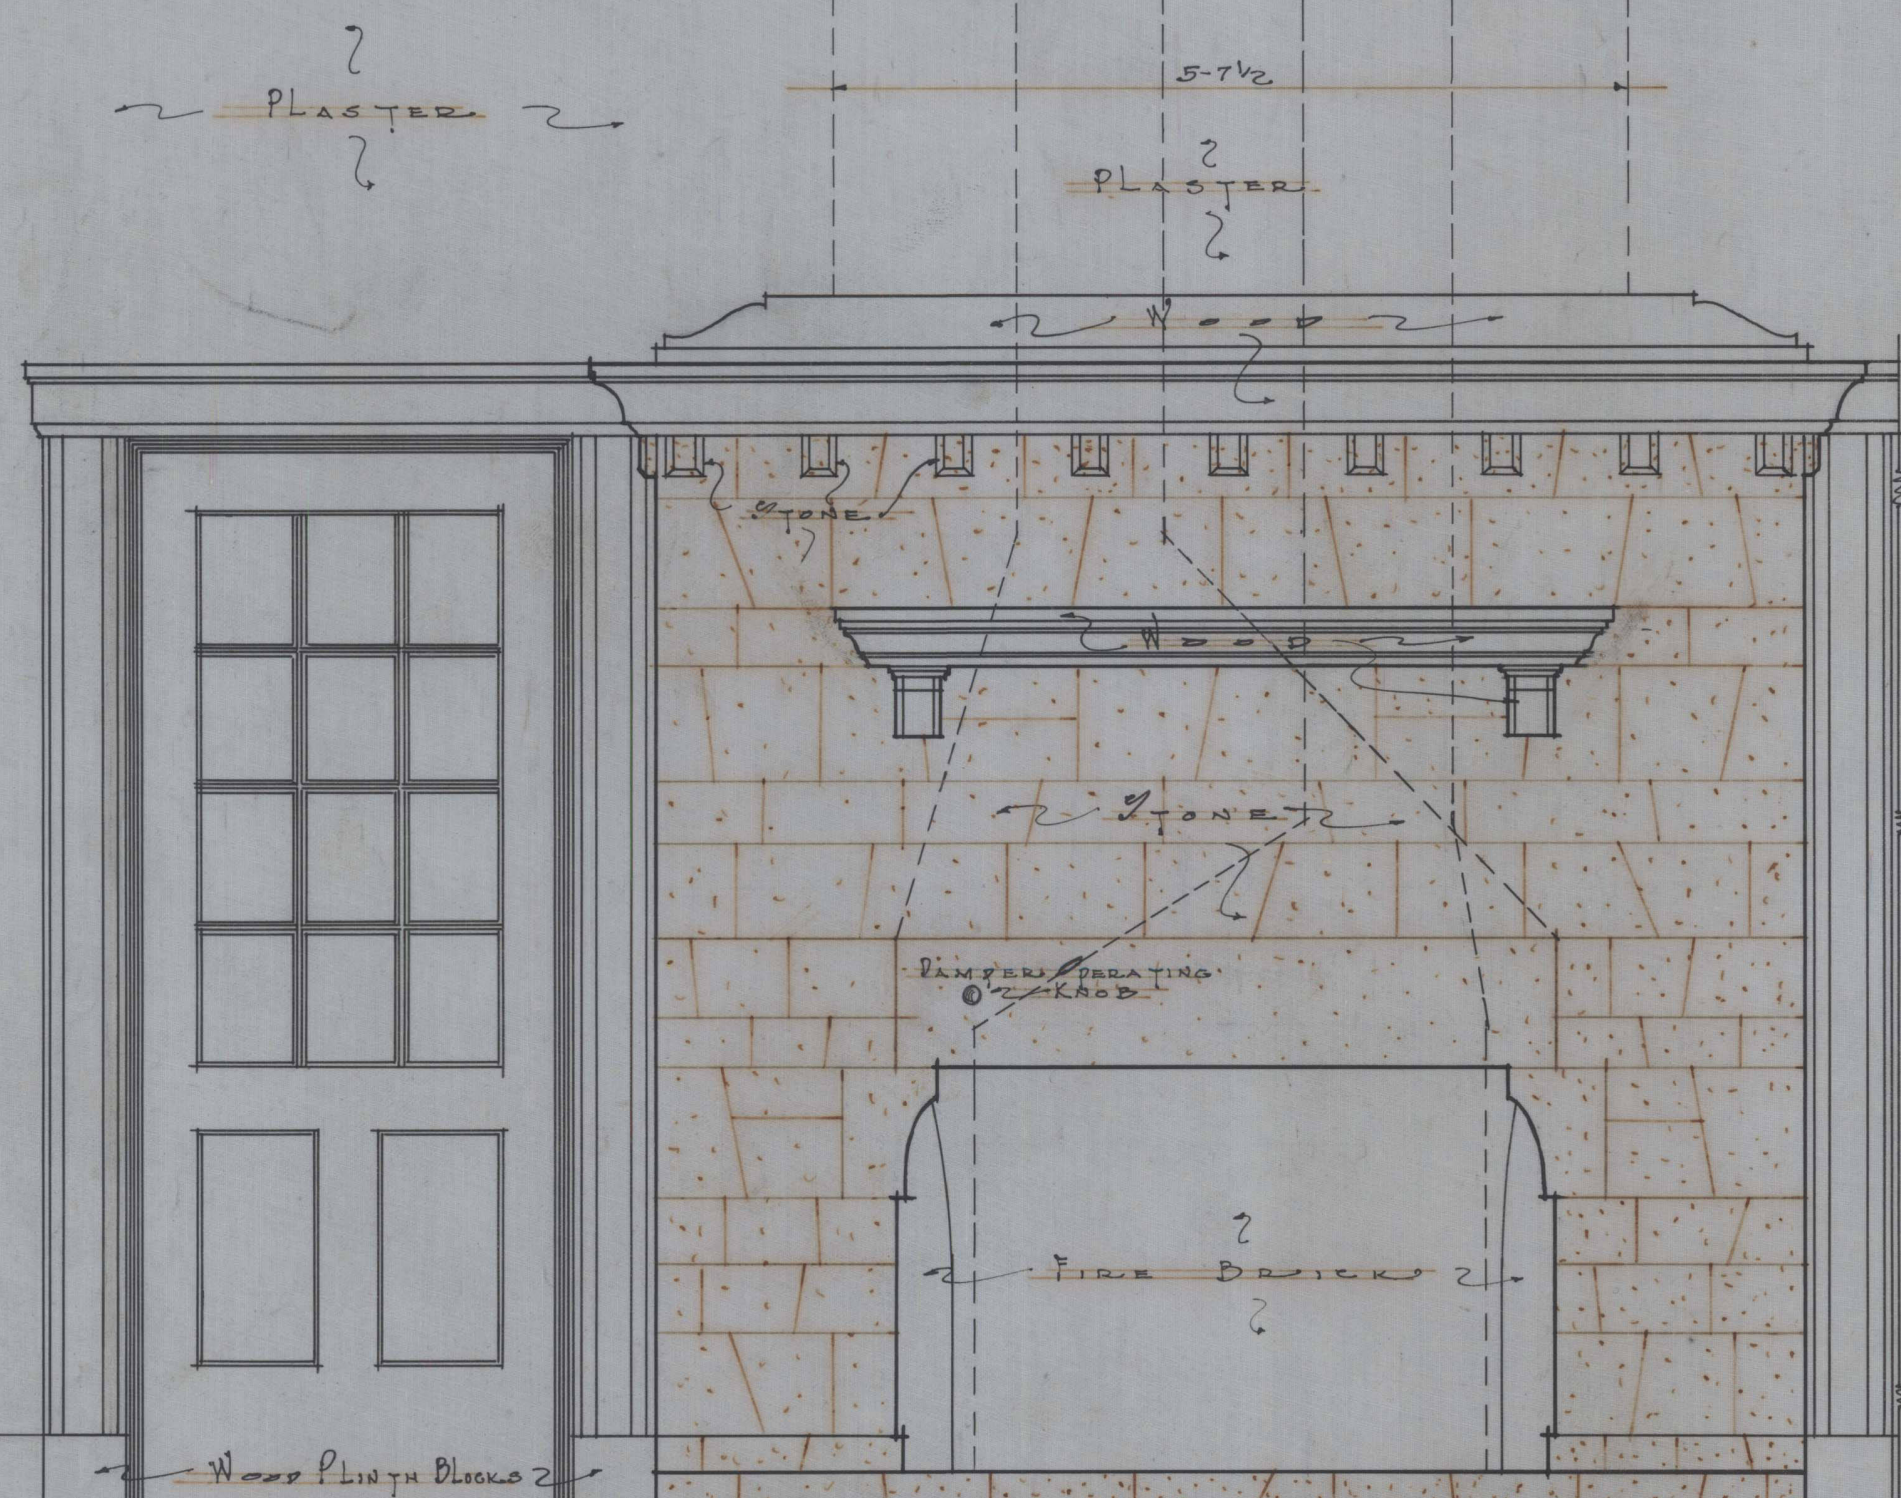


ELEVATION OF LOUNGE FIREPLACE

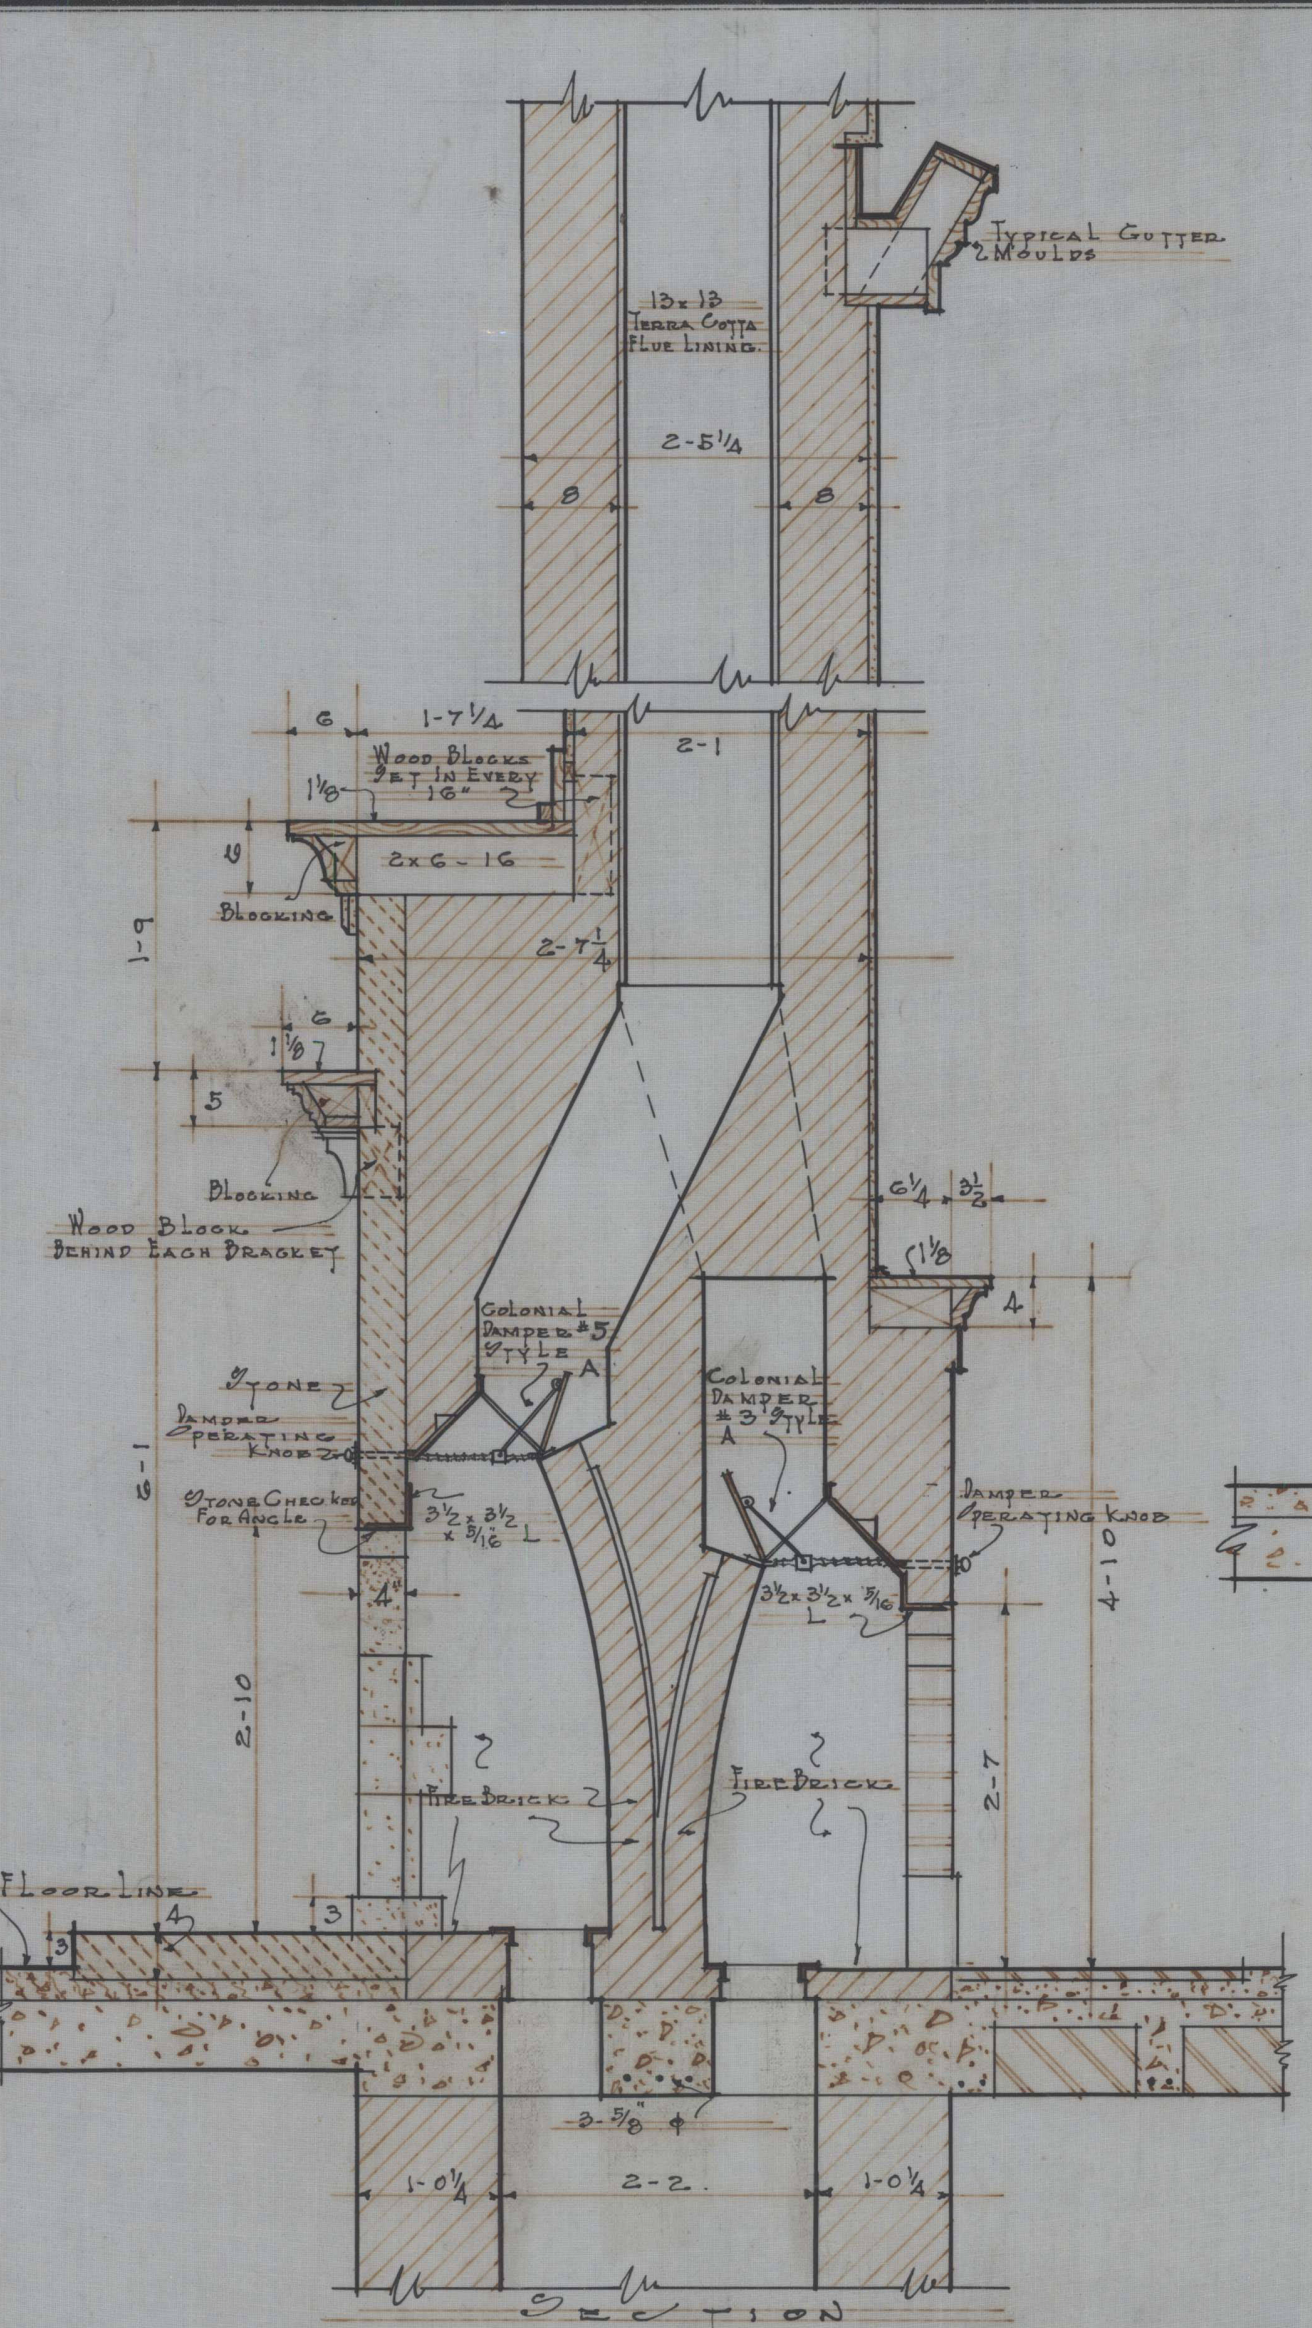


SECTION

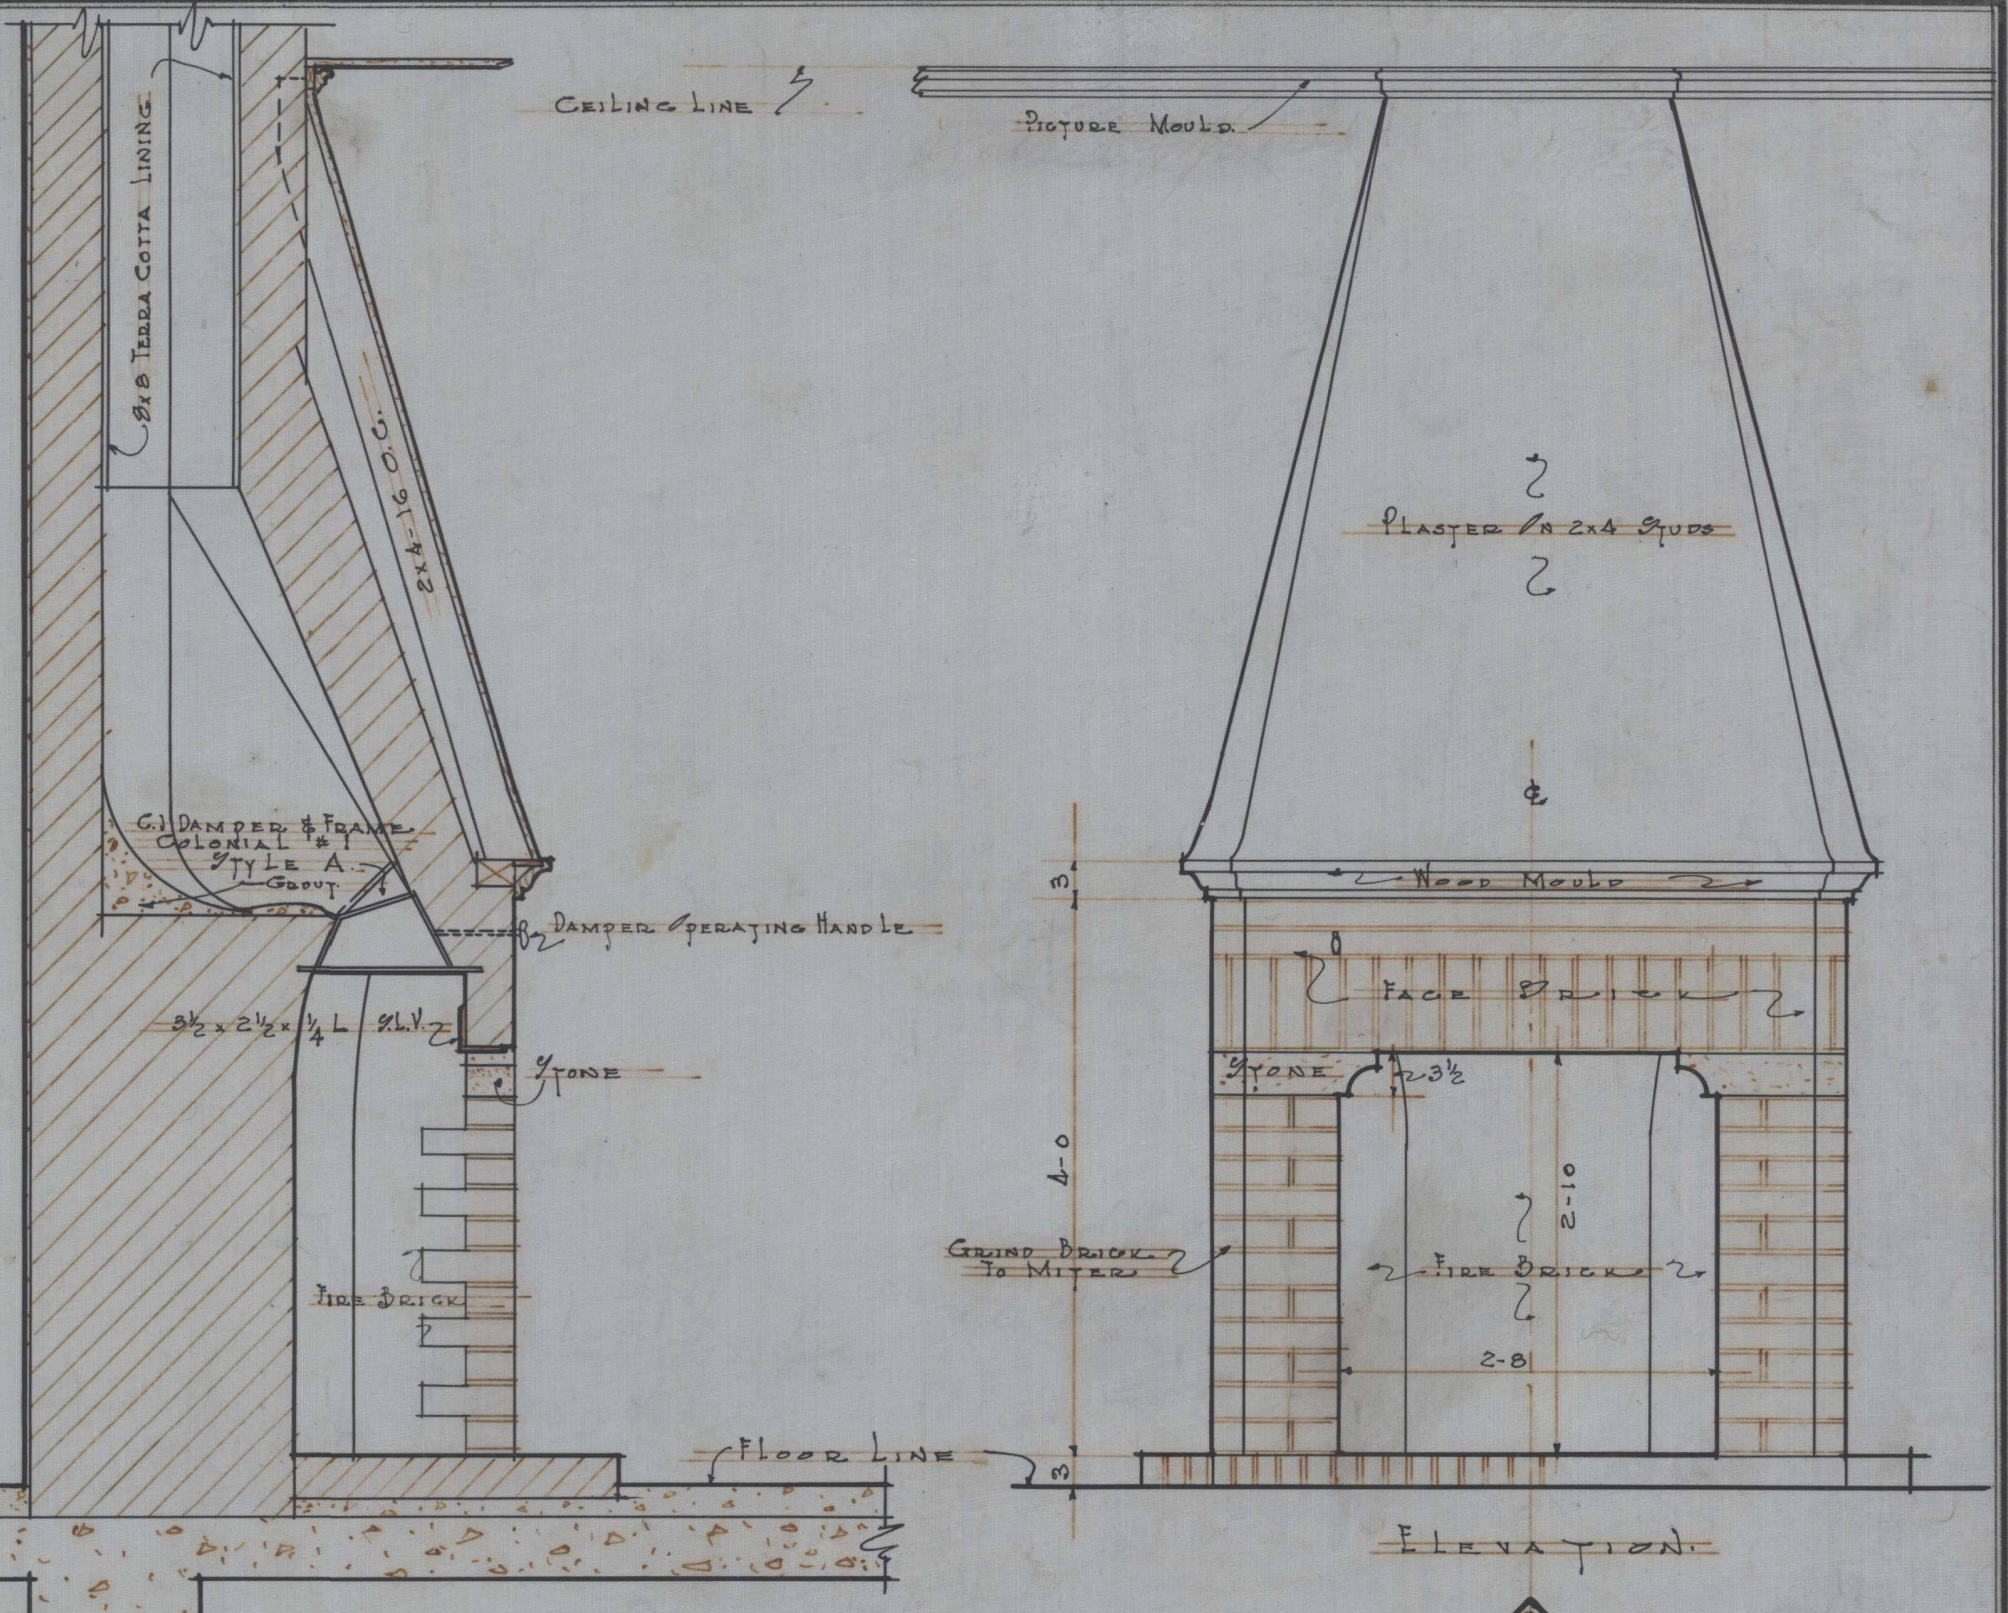


SECTION A-C

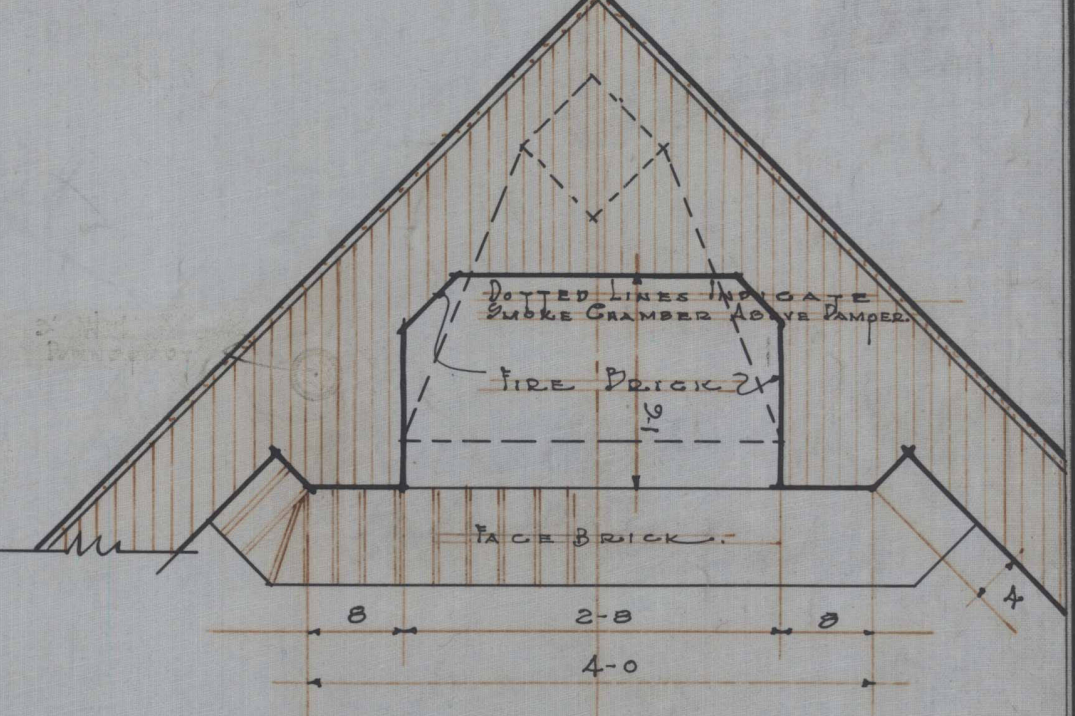

PLAN

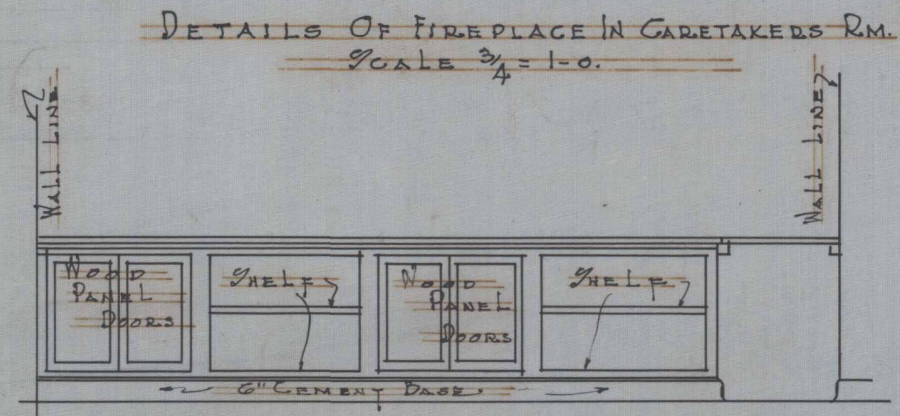


DETAILS OF FIREPLACE IN CARETAKER'S RM. Scale 3/4"=1'-0"

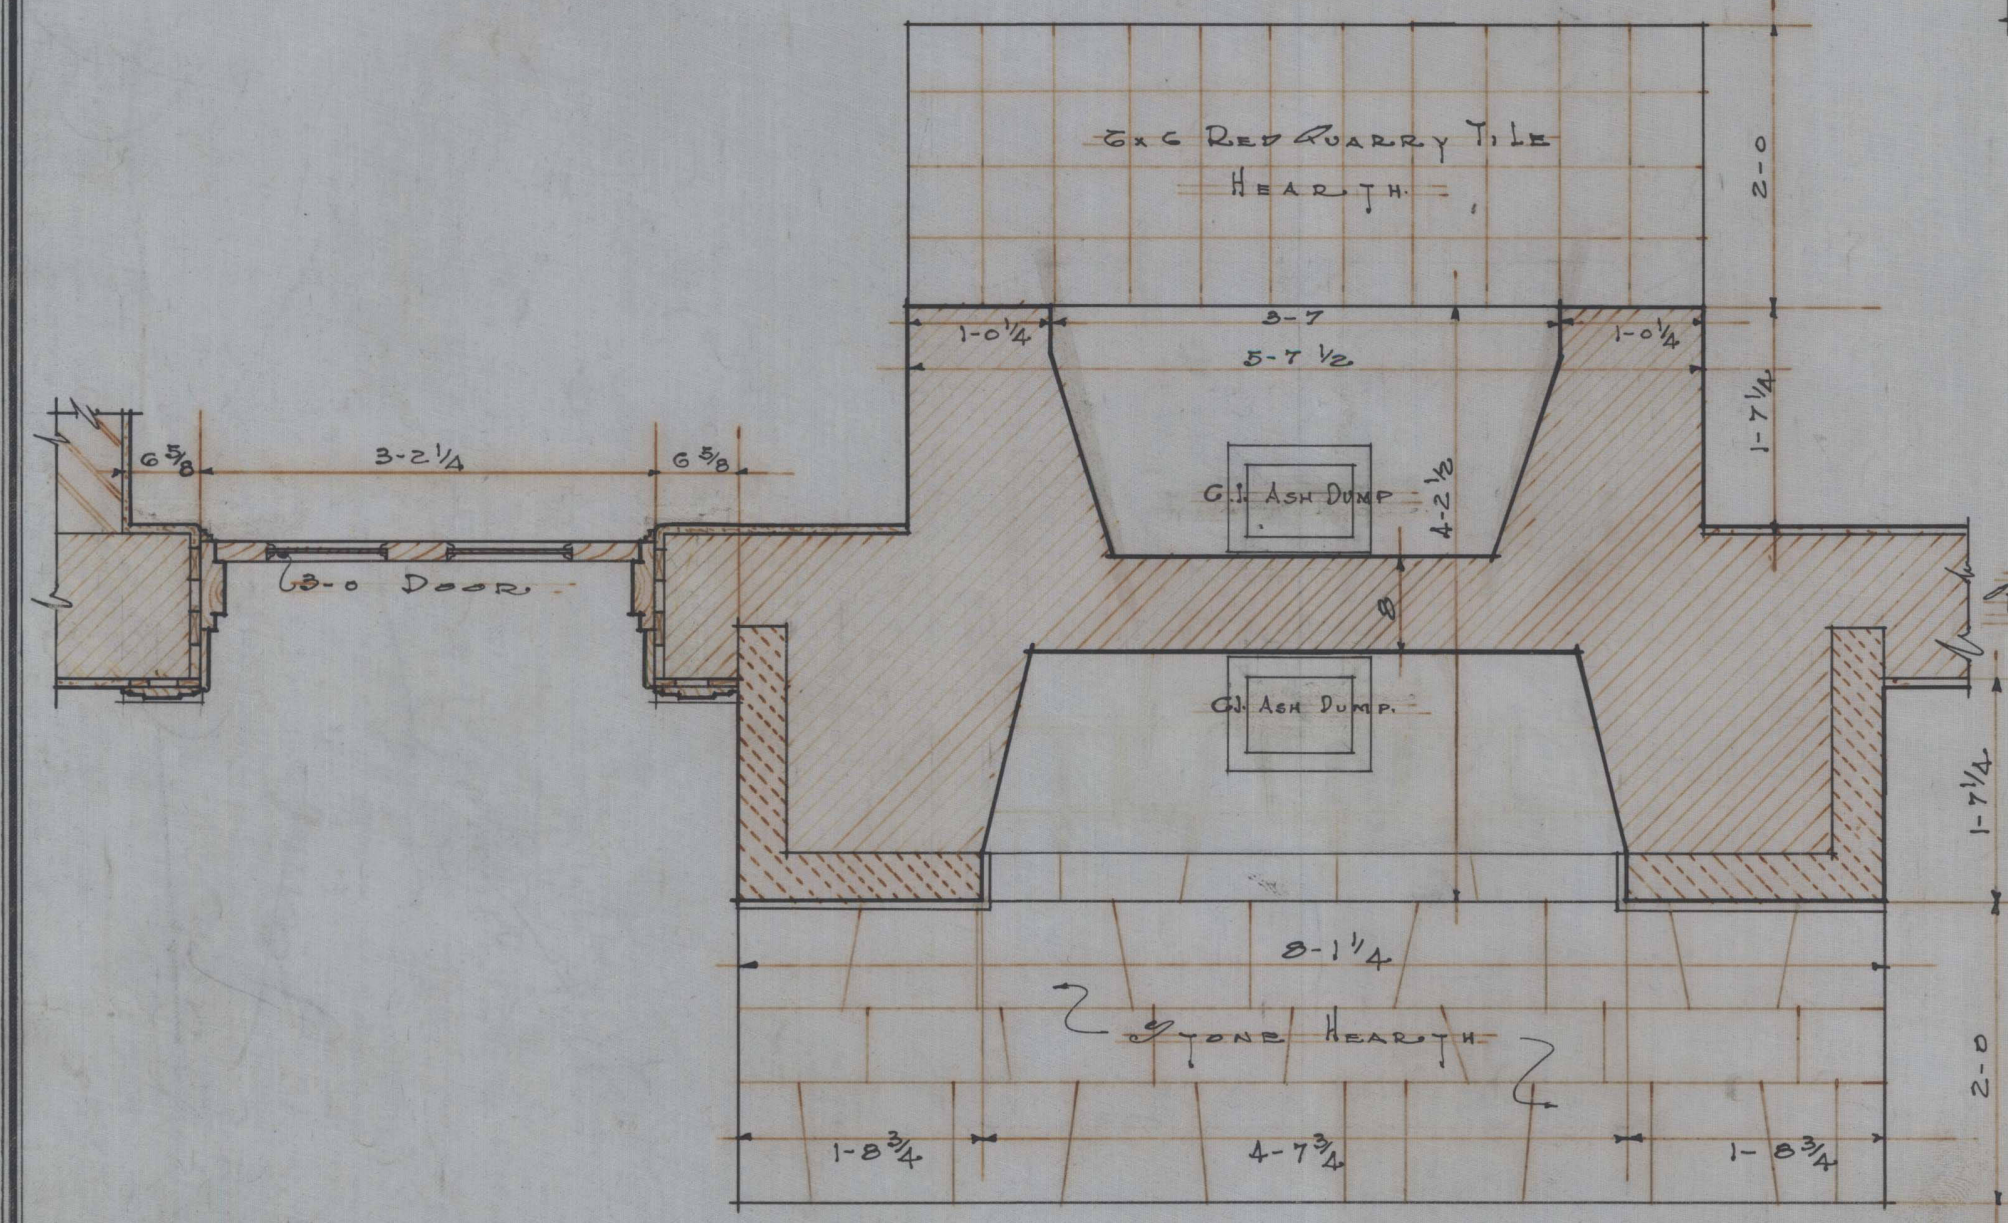


PLAN

FIREPLACE DETAILS Scale 3/4"=1'-0"







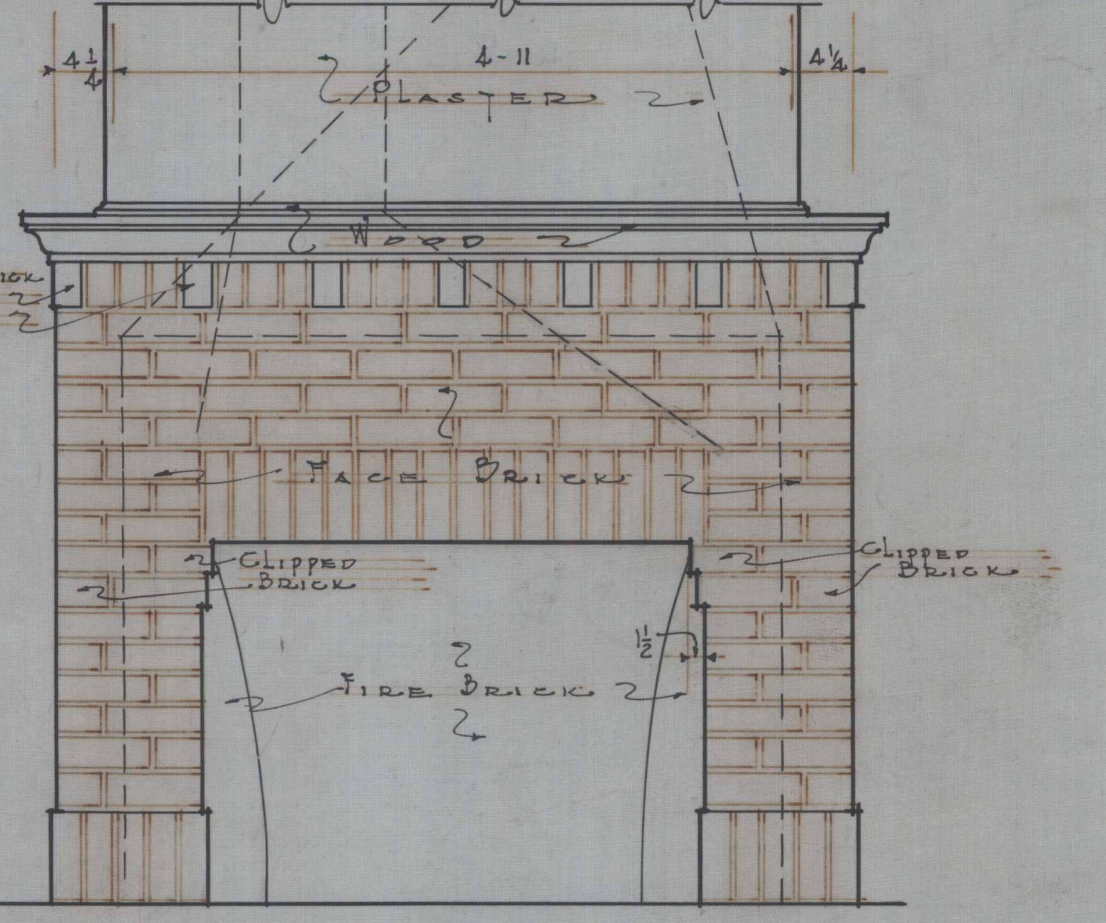


ELEVATION OF RECEPTION ROOM FIREPLACE




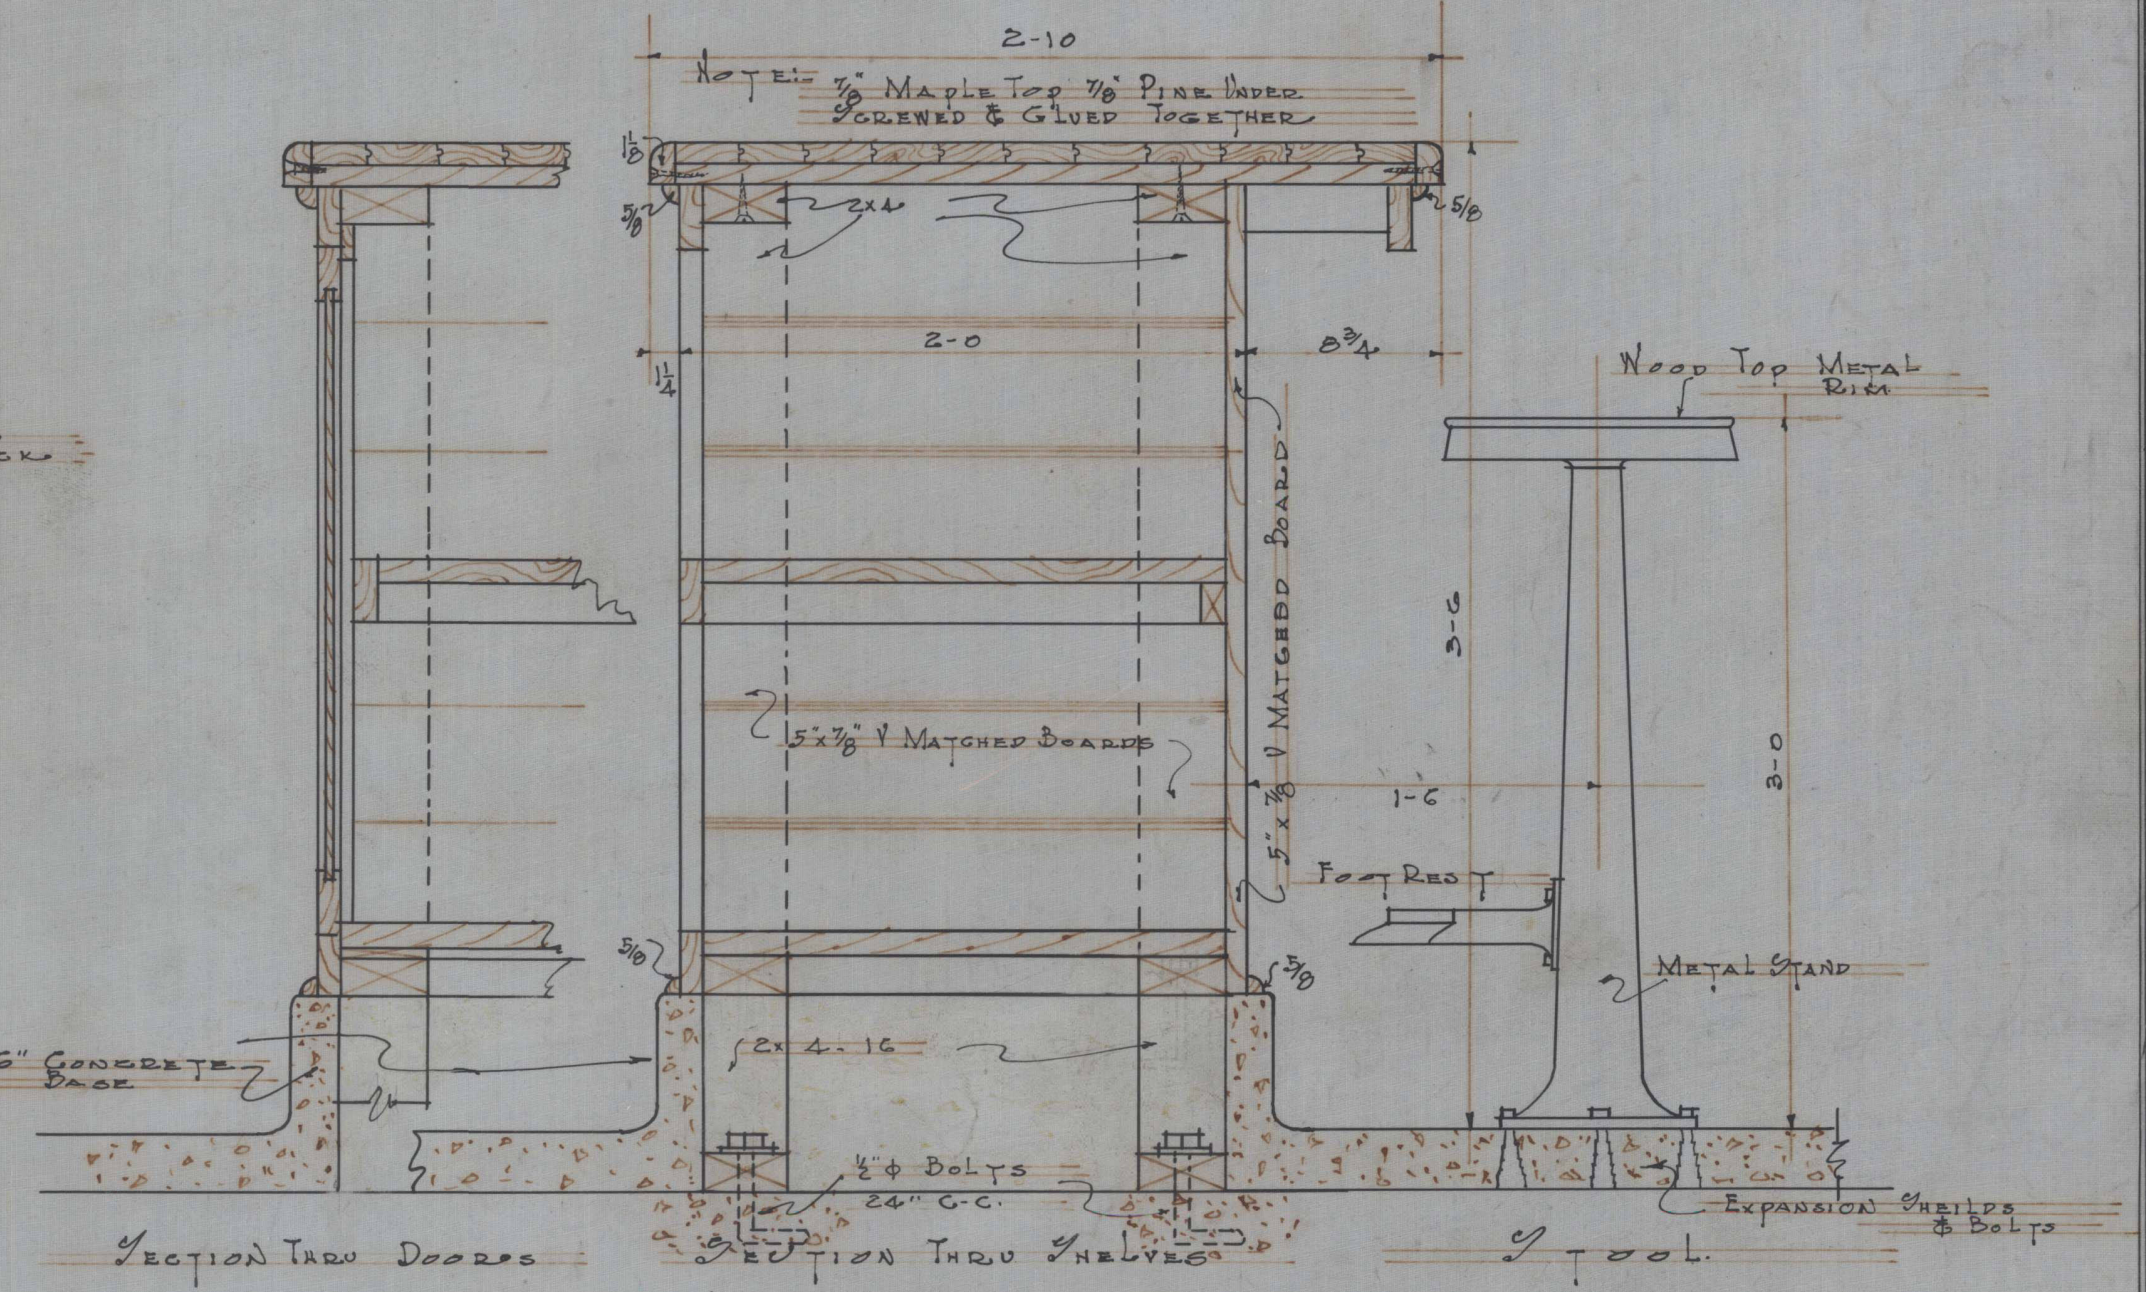


DETAILS OF COUNTER IN LUNCH ROOM Scale 1/2"=1'-0"

SCALE/REV	DETAILS	DATE
H.E.S. H.E.S.	CLUB HOUSE	11-24
D.W. W.D.M.	FOR WILLIAM'S DEAR-PARZ	JOB NO 090
	TERRE HAUTE	SHEET 8
JOHNSON MILLER MILLER & YEAGER - ARCHITECTS		
TERRE HAUTE, INDIANA		

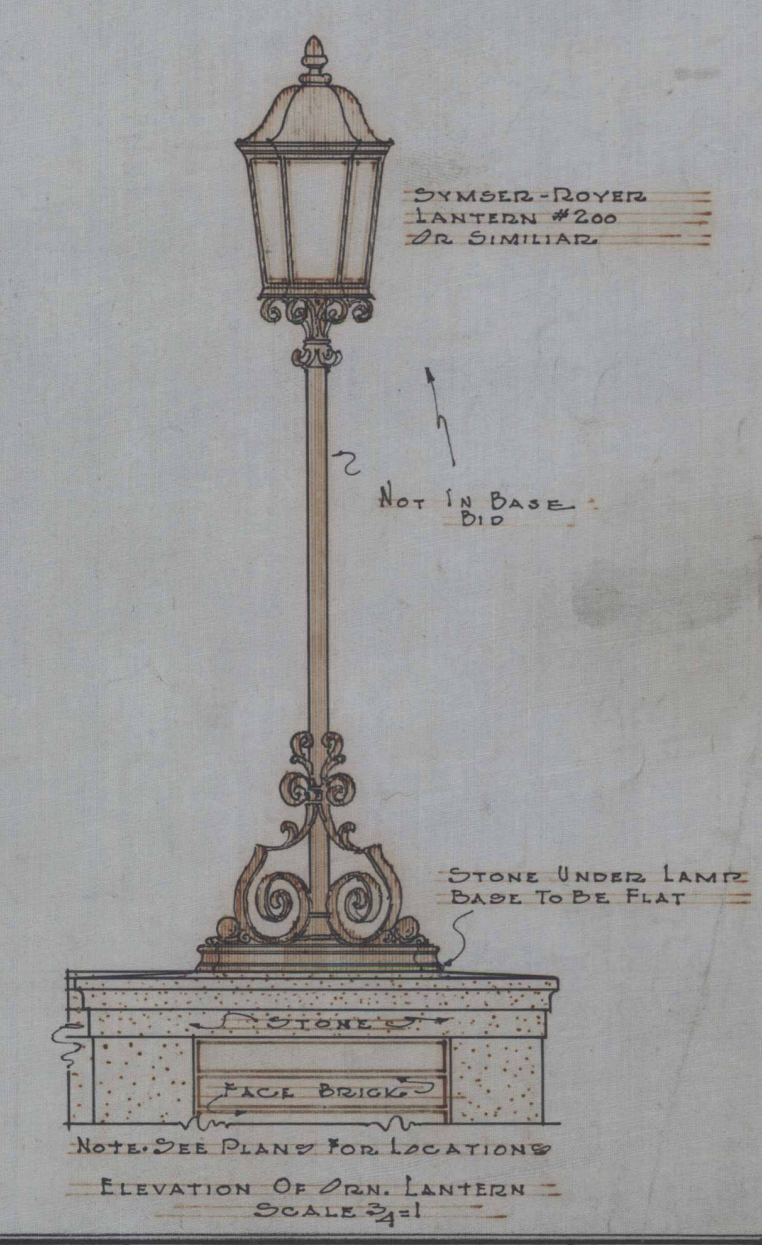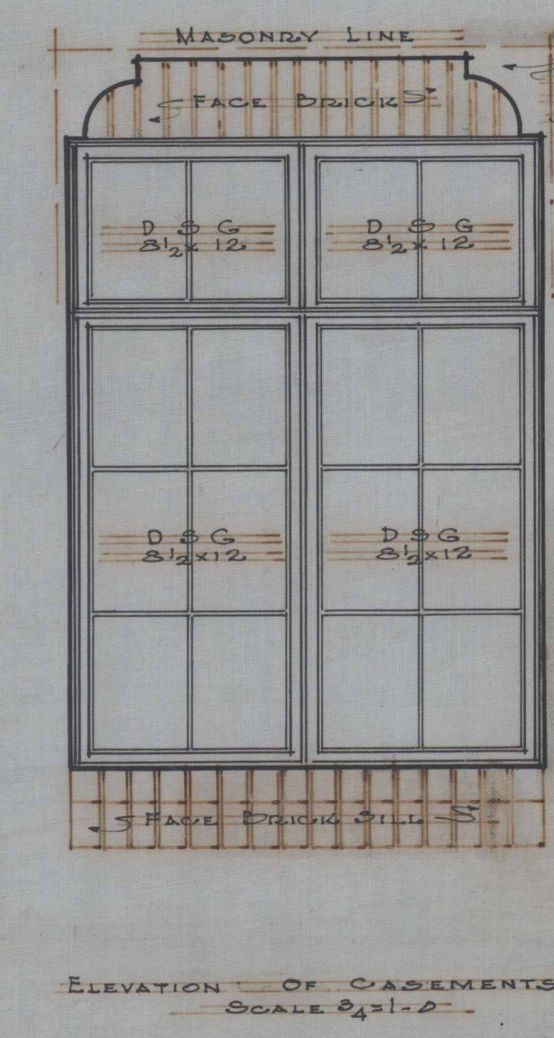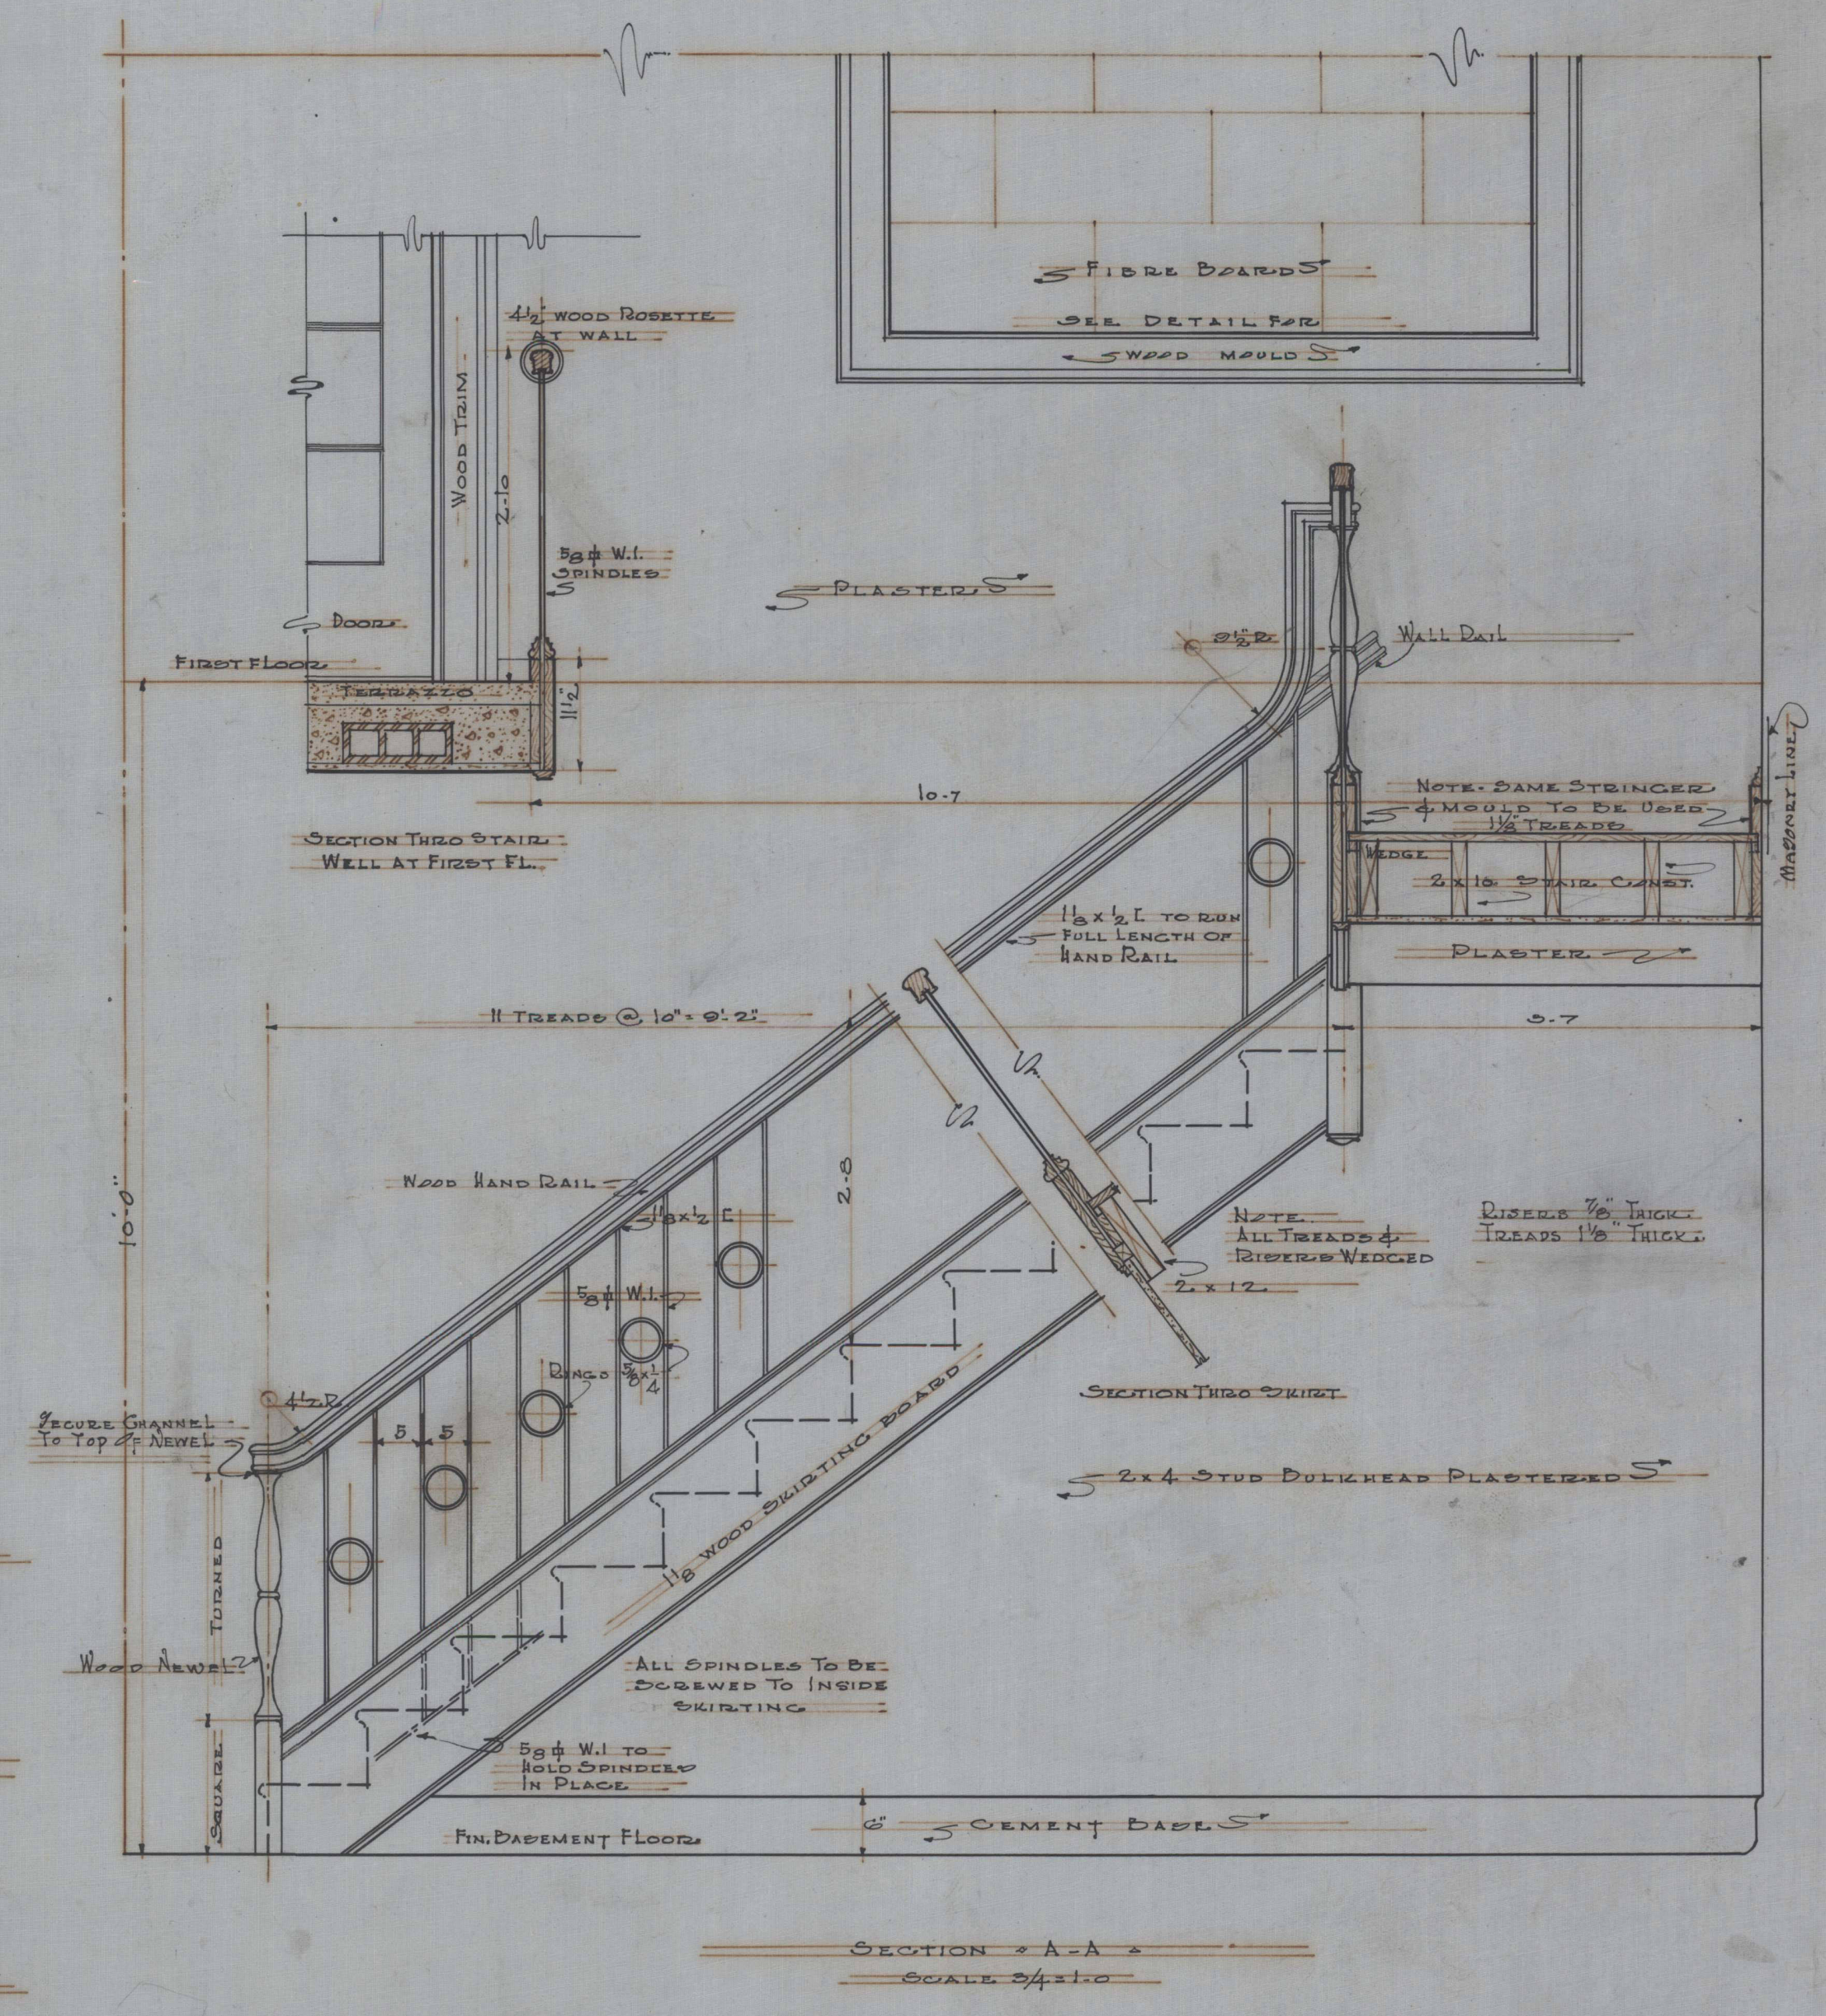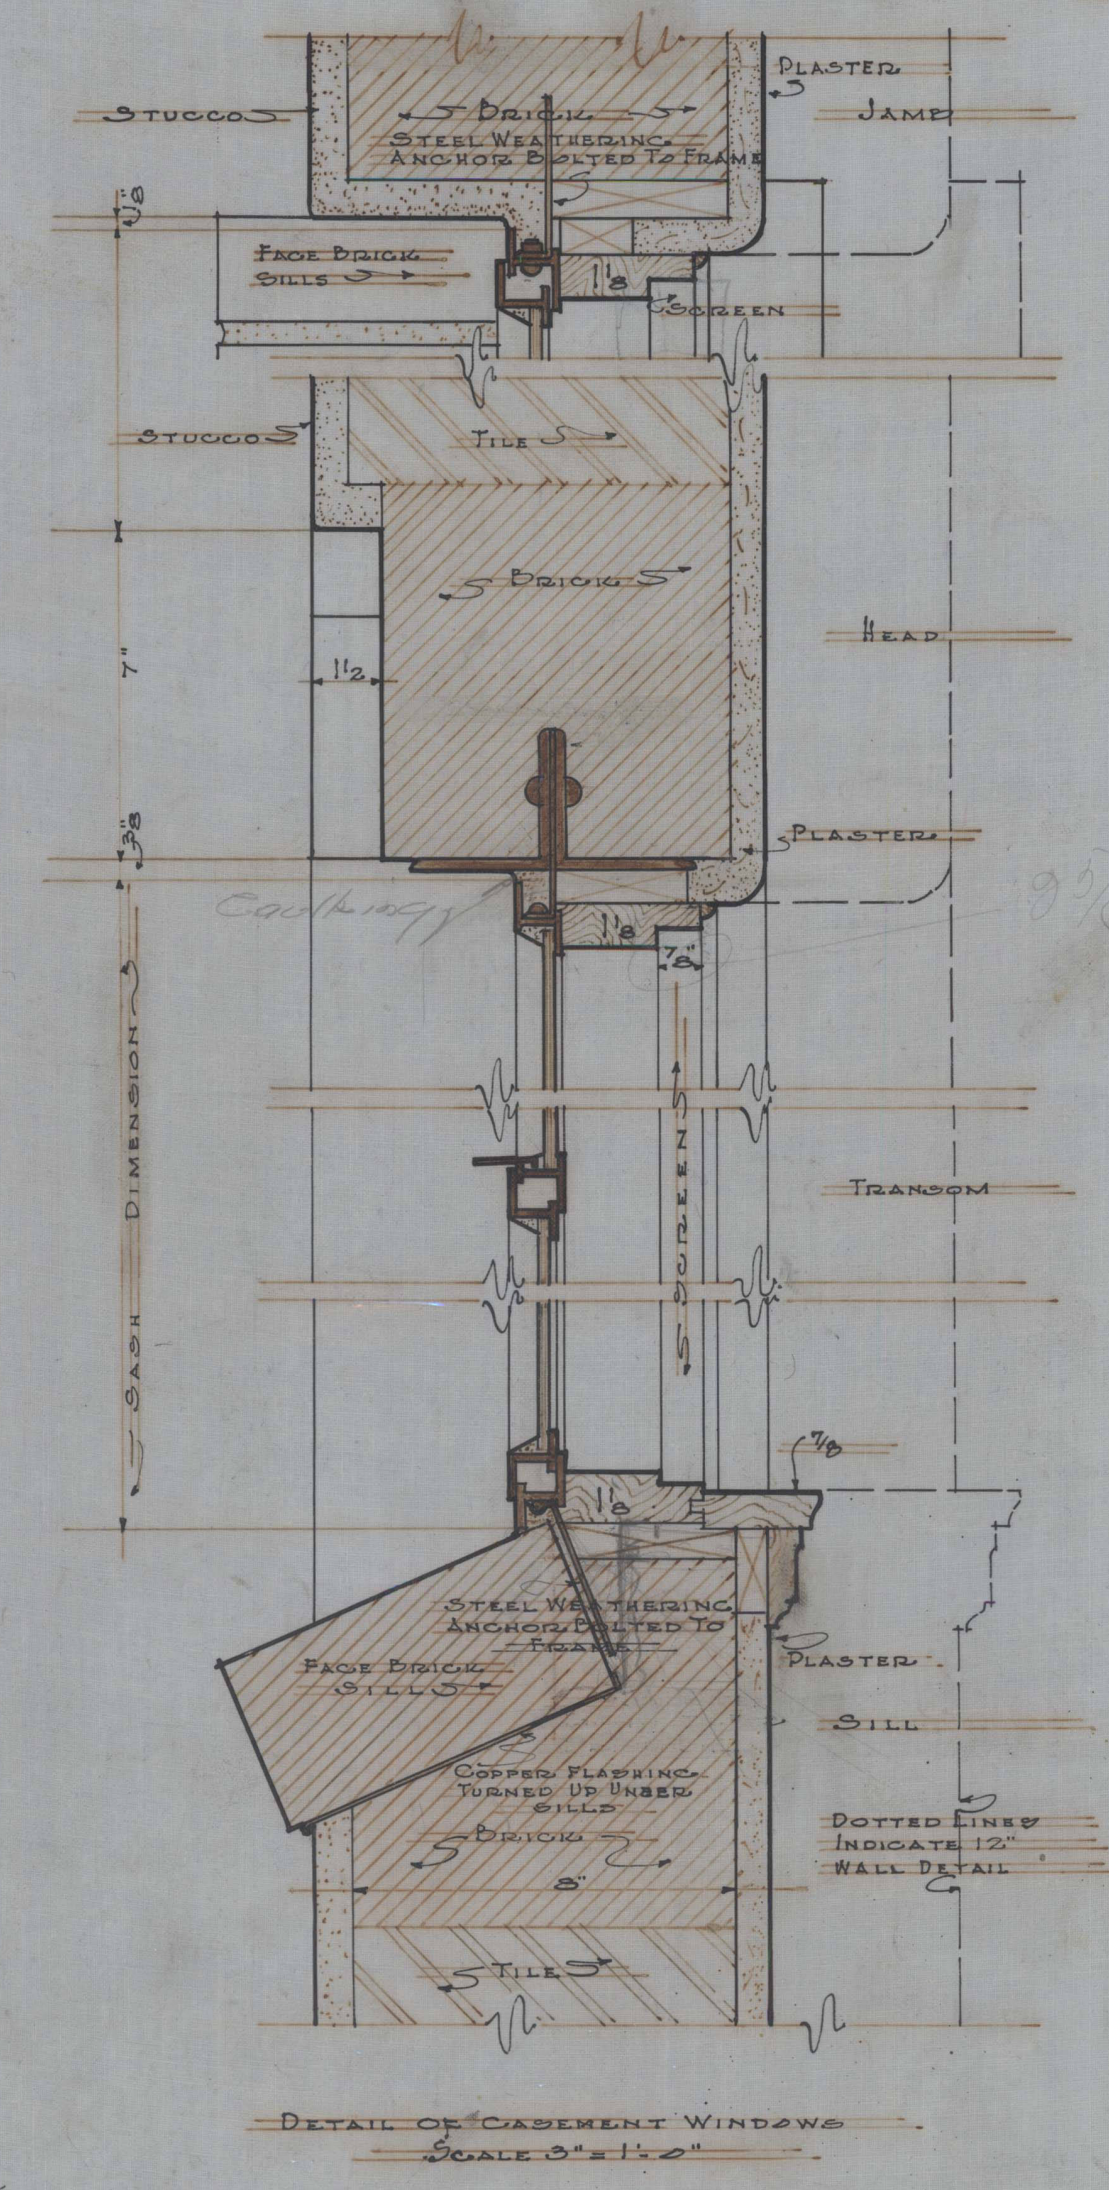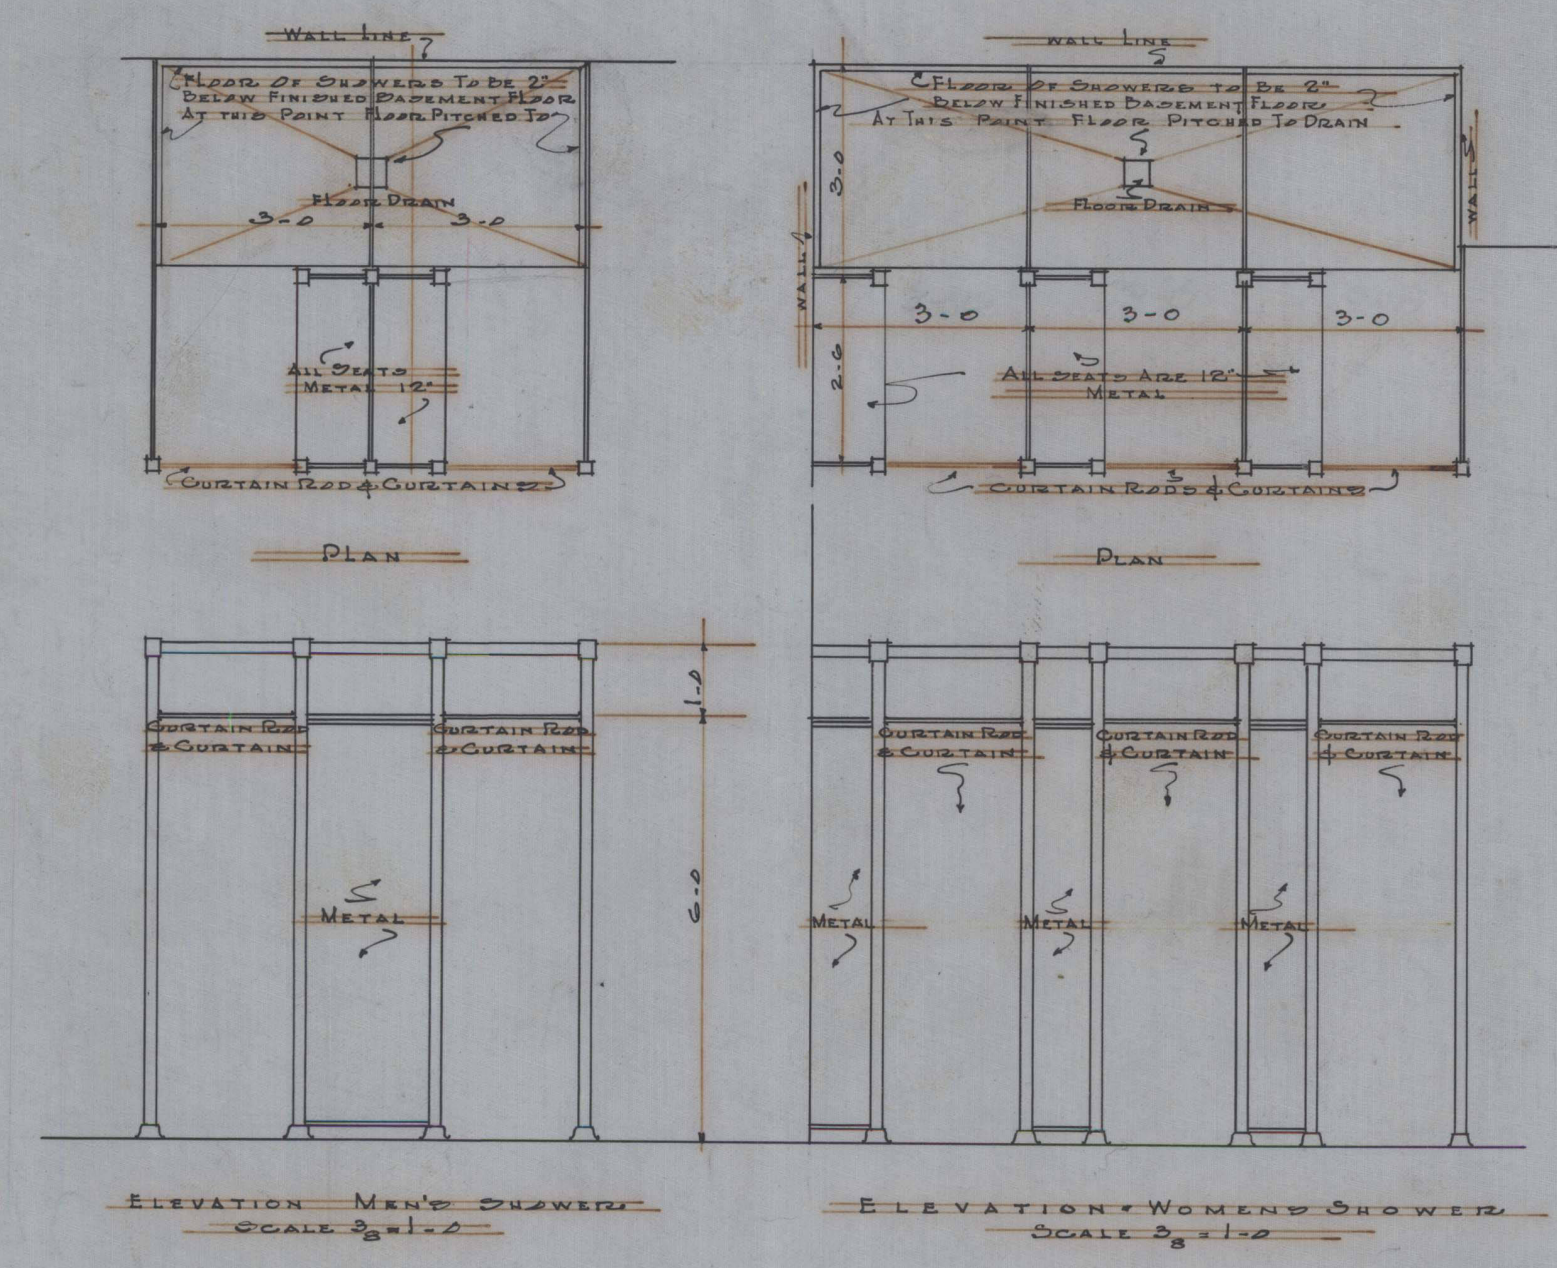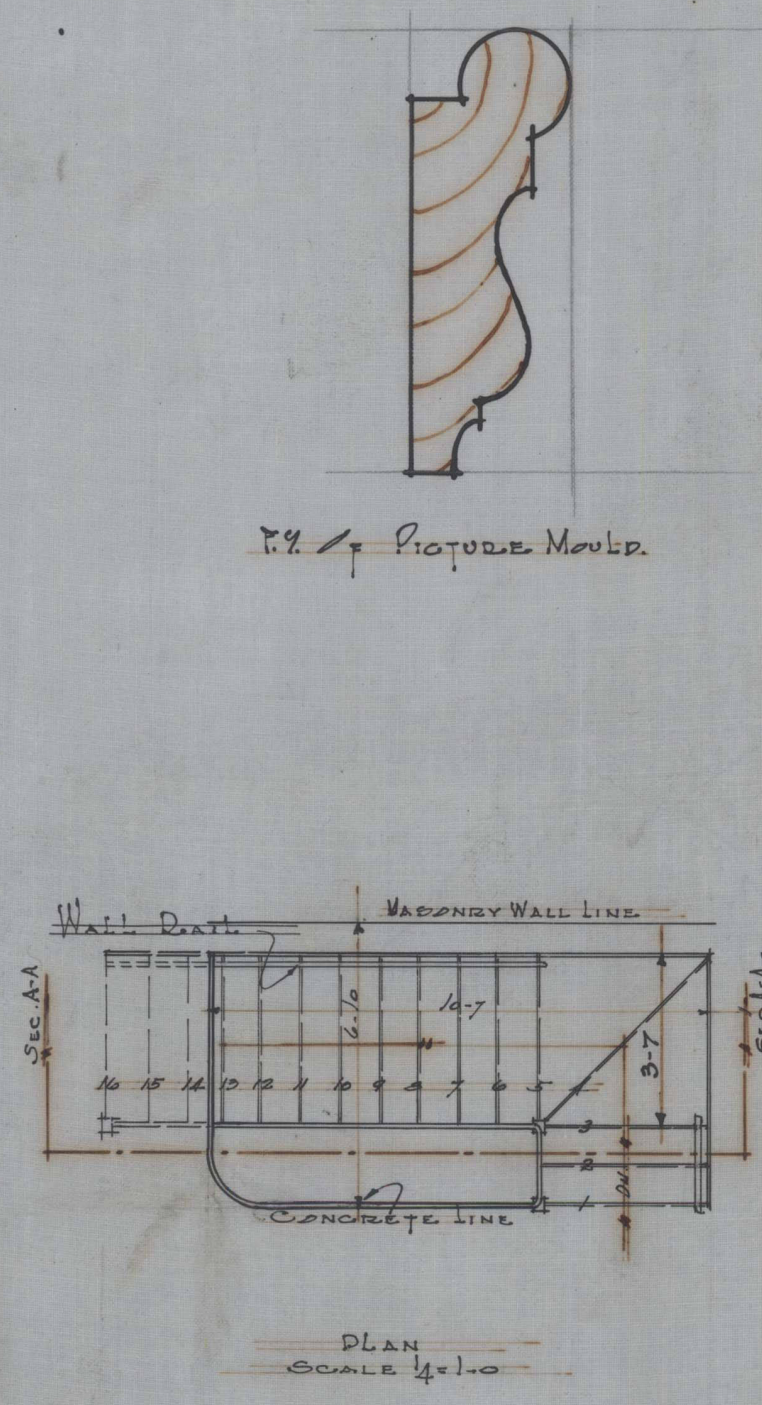
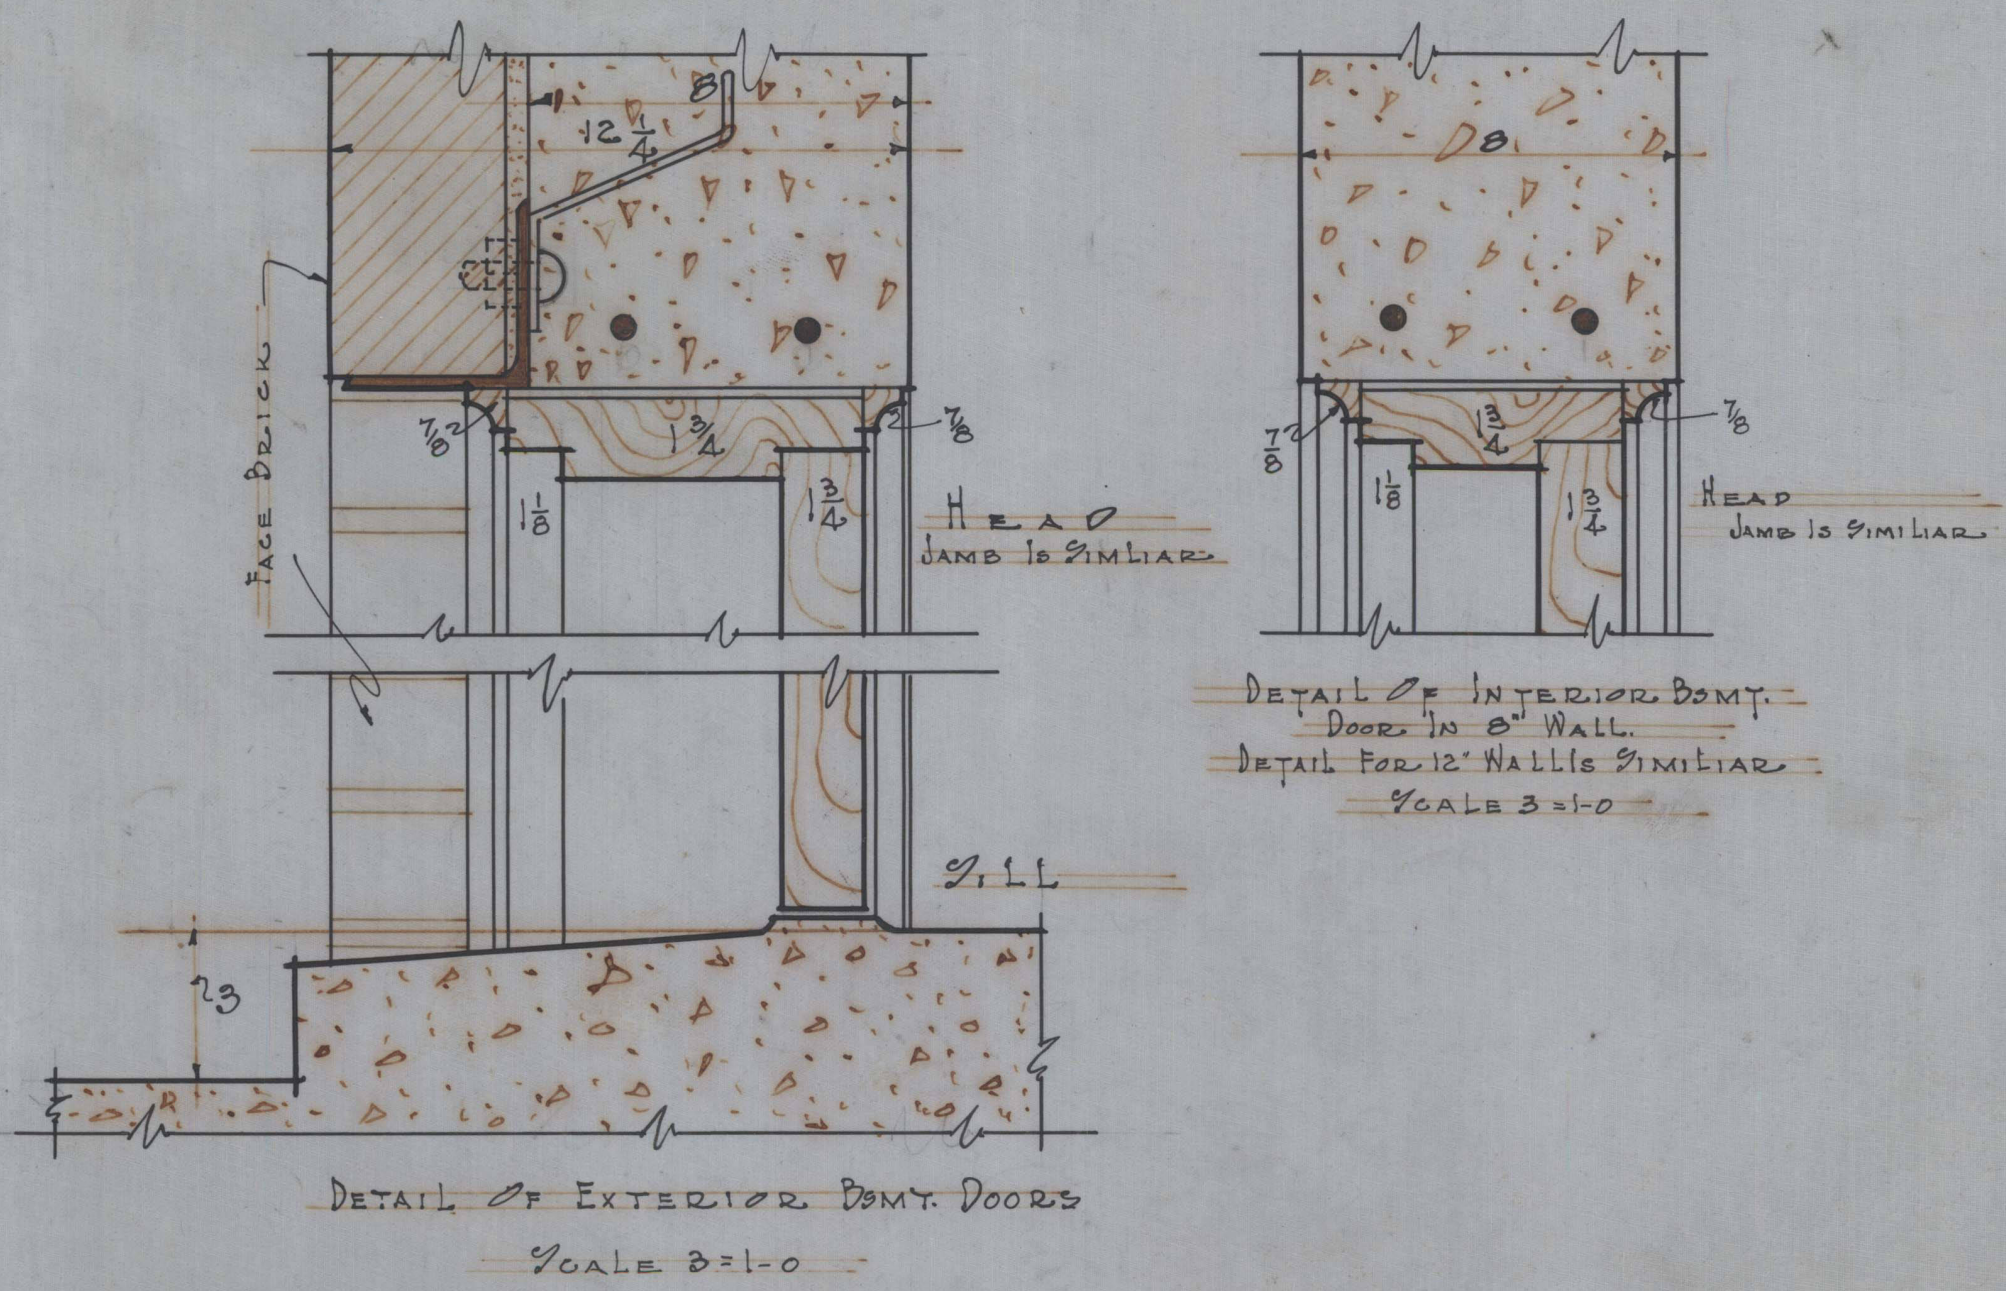


SCALE VARIES	DETAILS	DATE 12-1-24
A.L.V. ARCH	CLYD HOYSE	JOB NO 890
REV. WDM	WILLIAM S. DEAN ARCHT	SHEET 9
JOHNSON MILLED MILLER & VEATCH ARCHTGTES 1 - TERRE HAUTE, INDIANA		

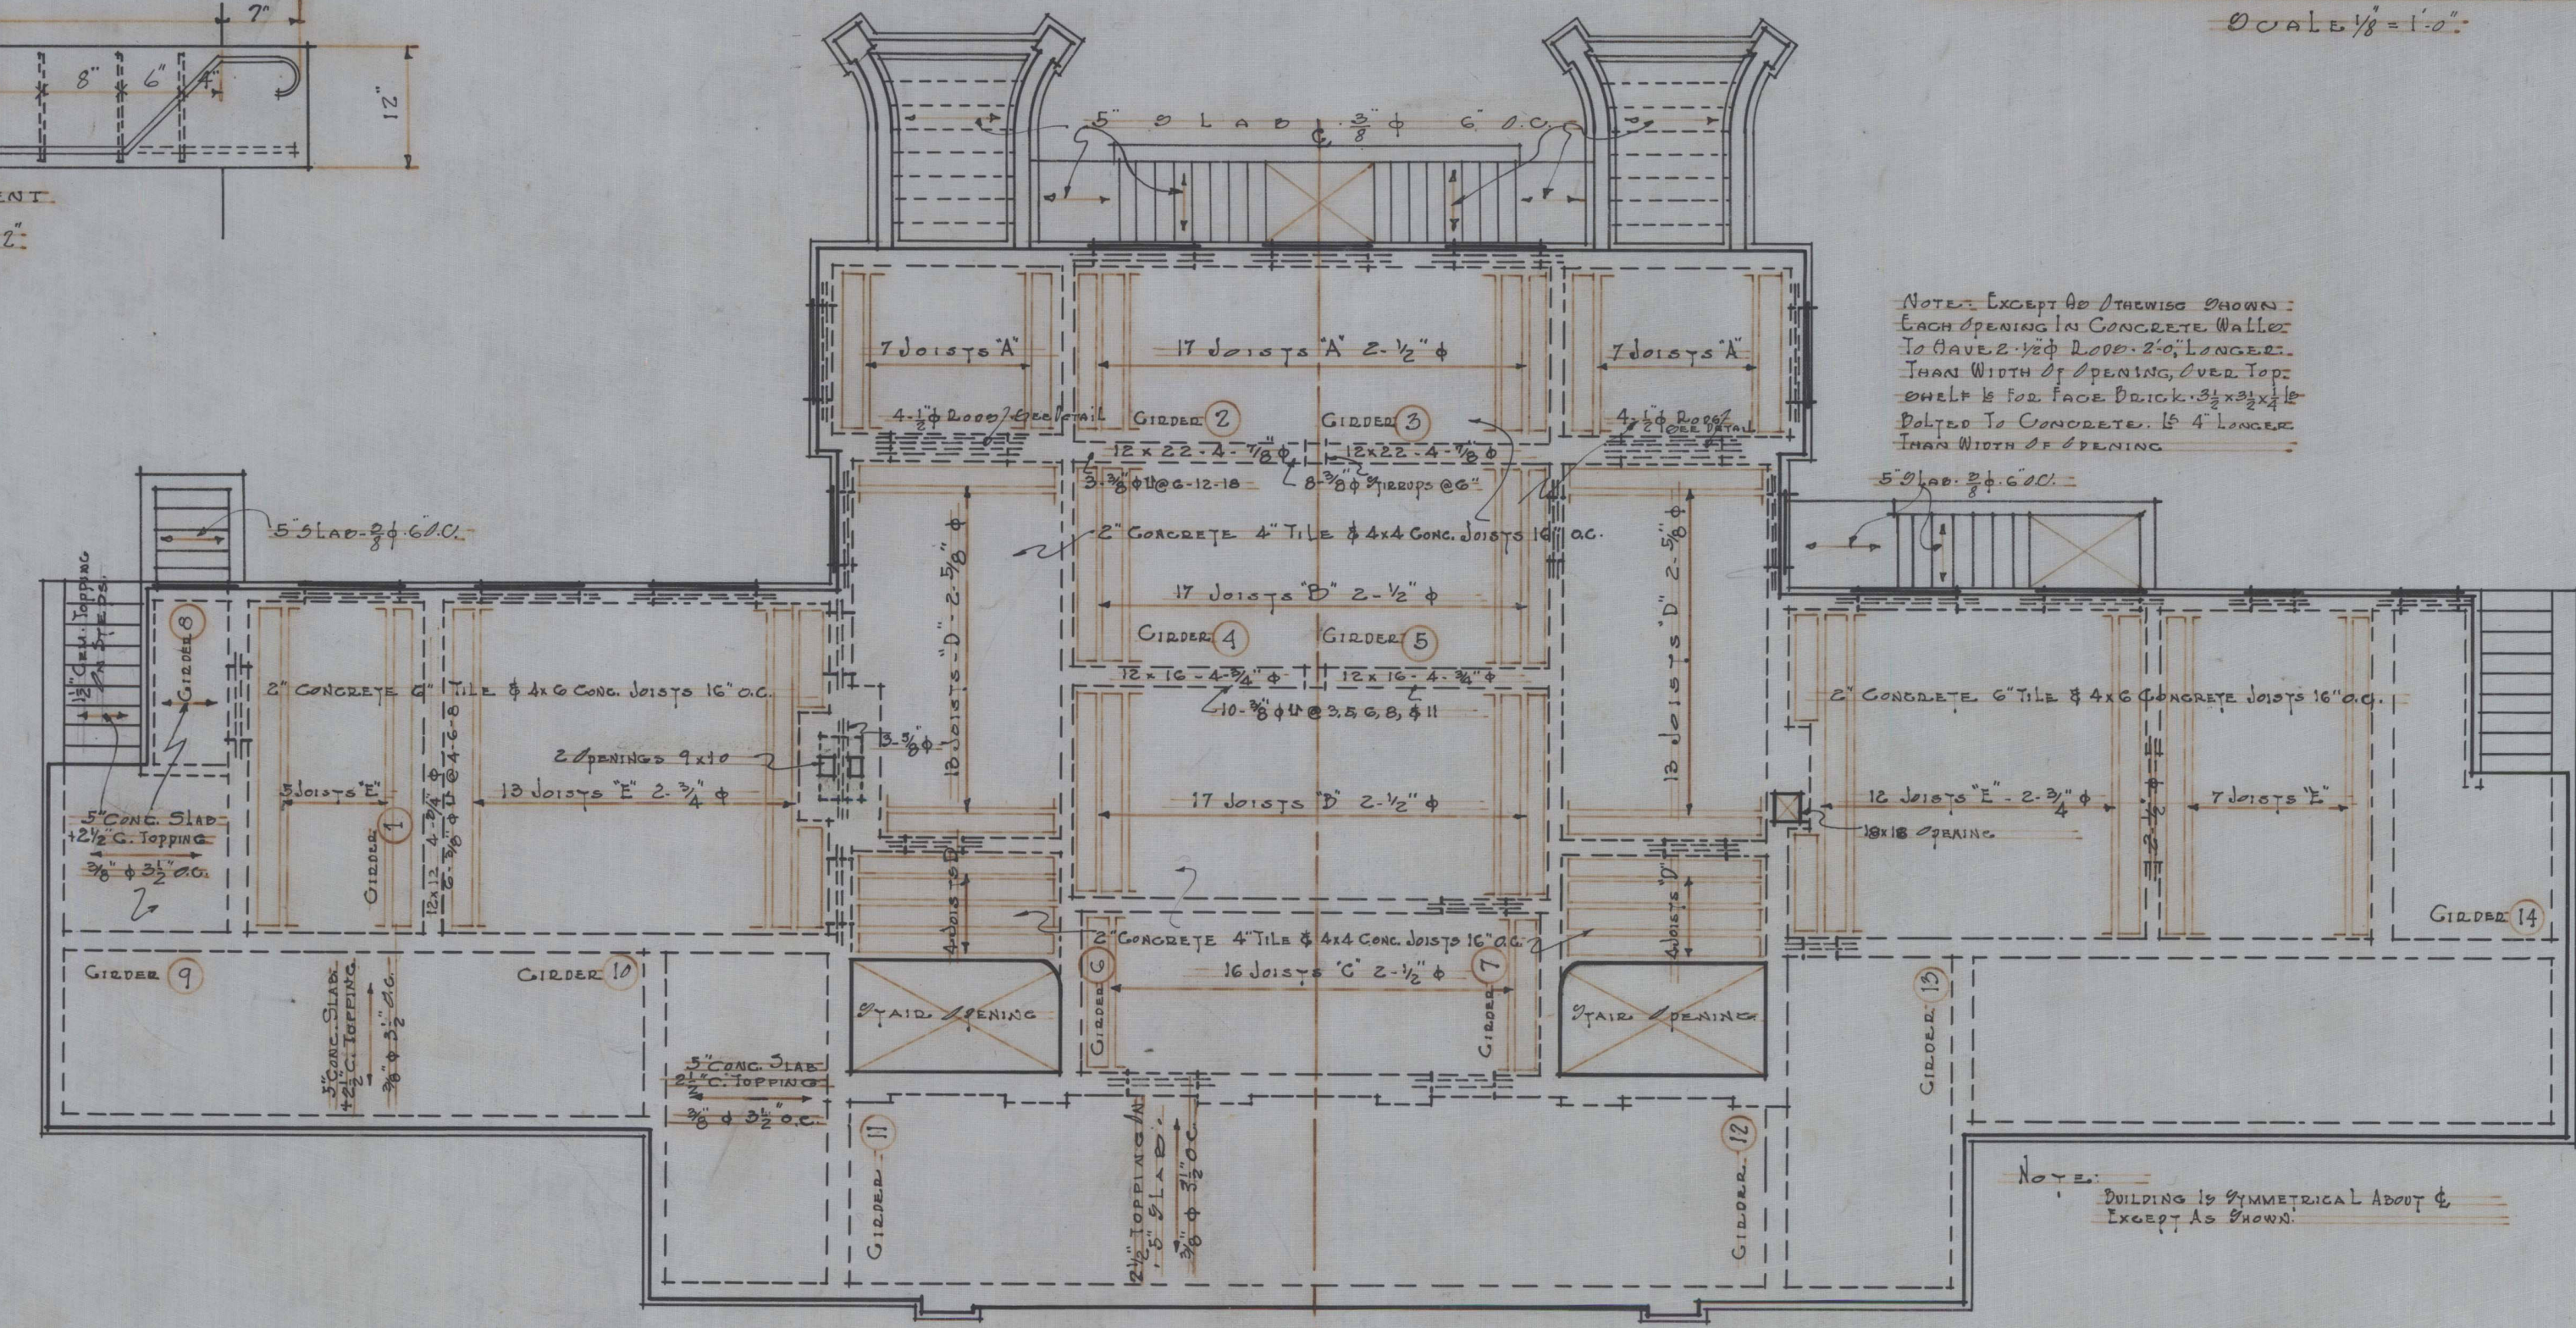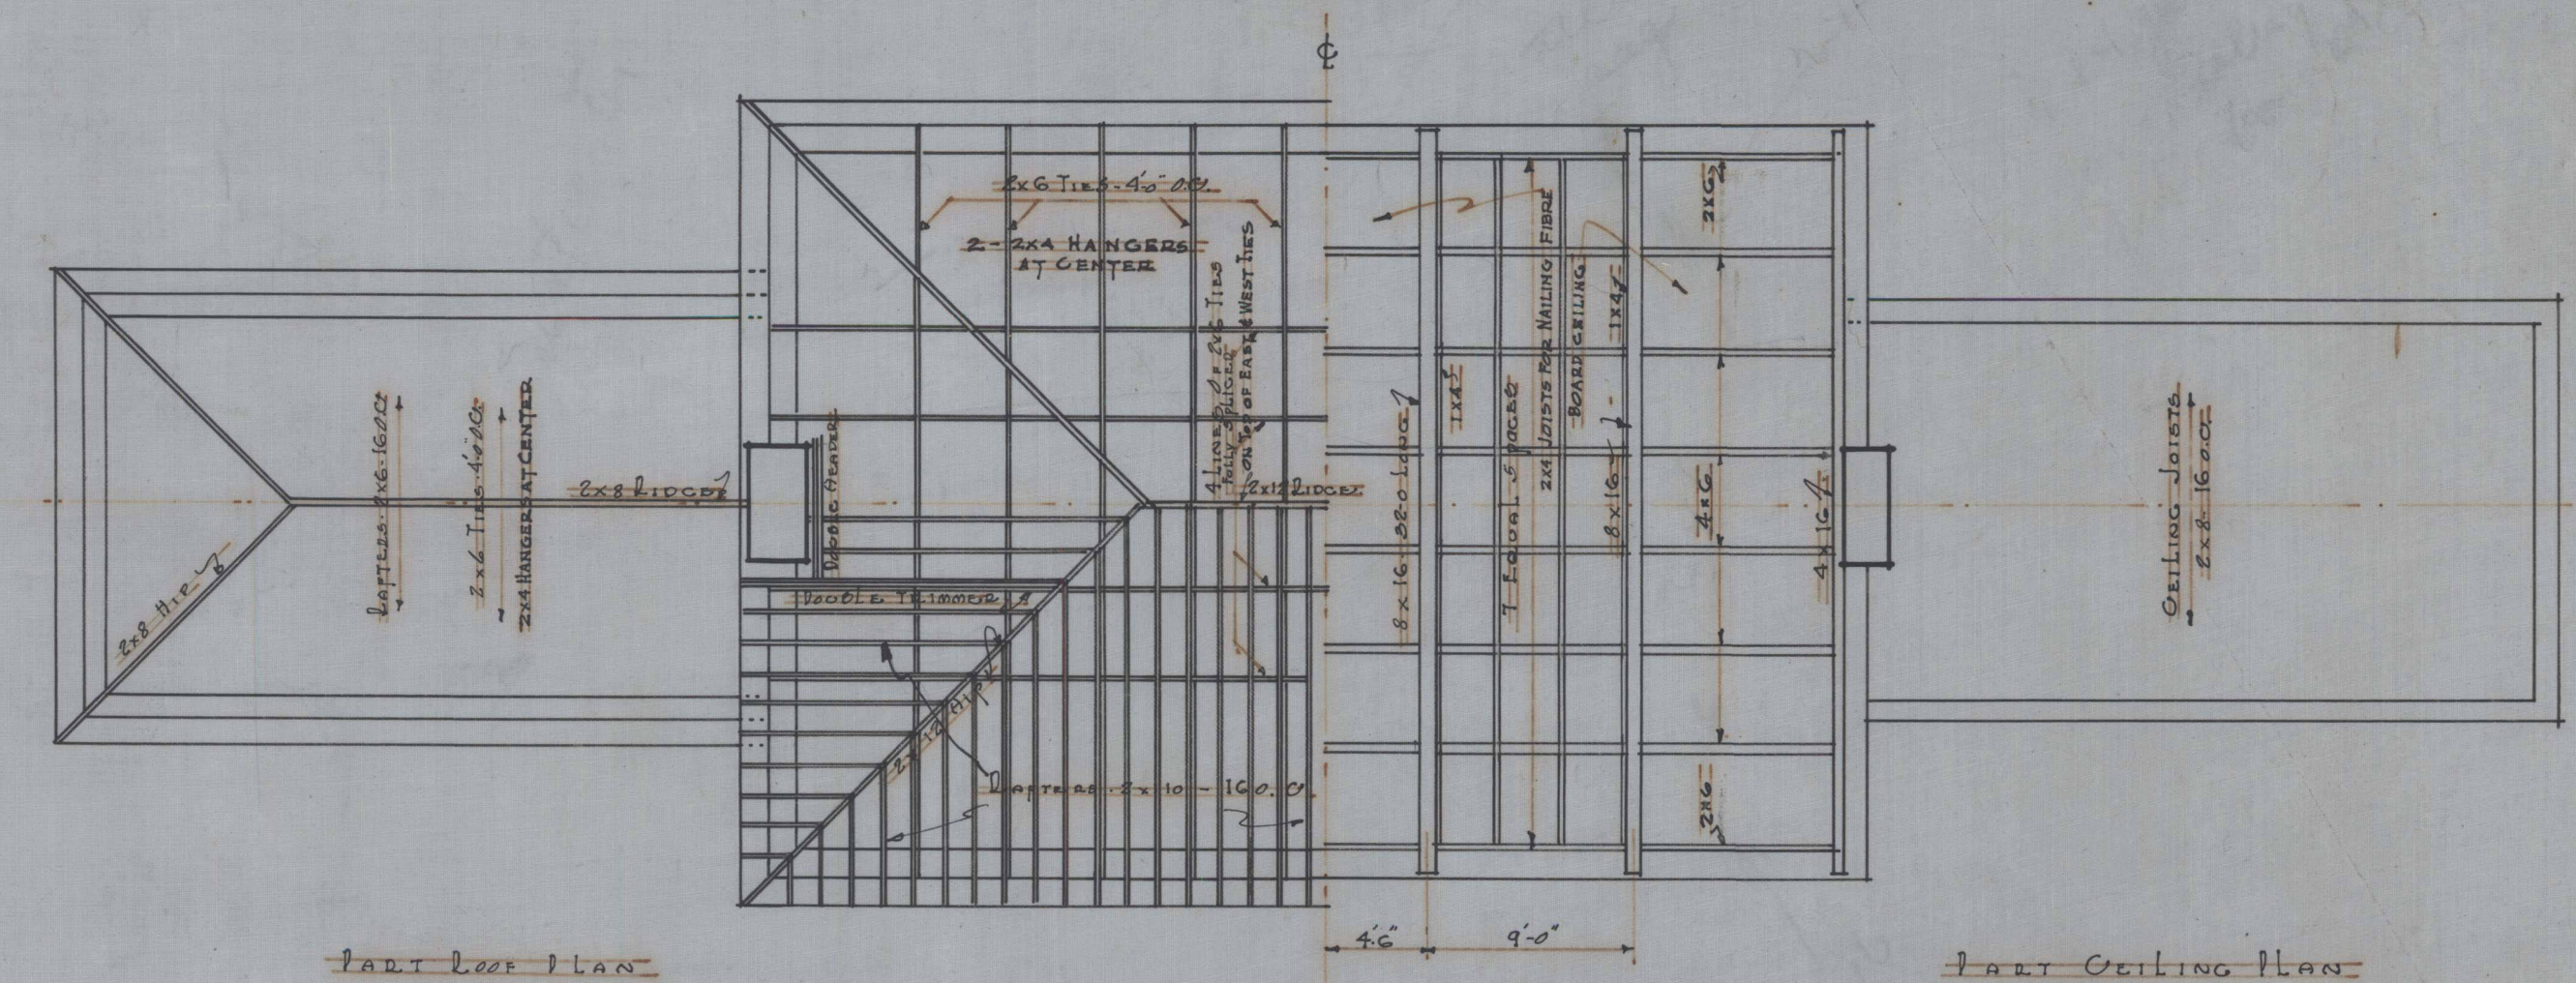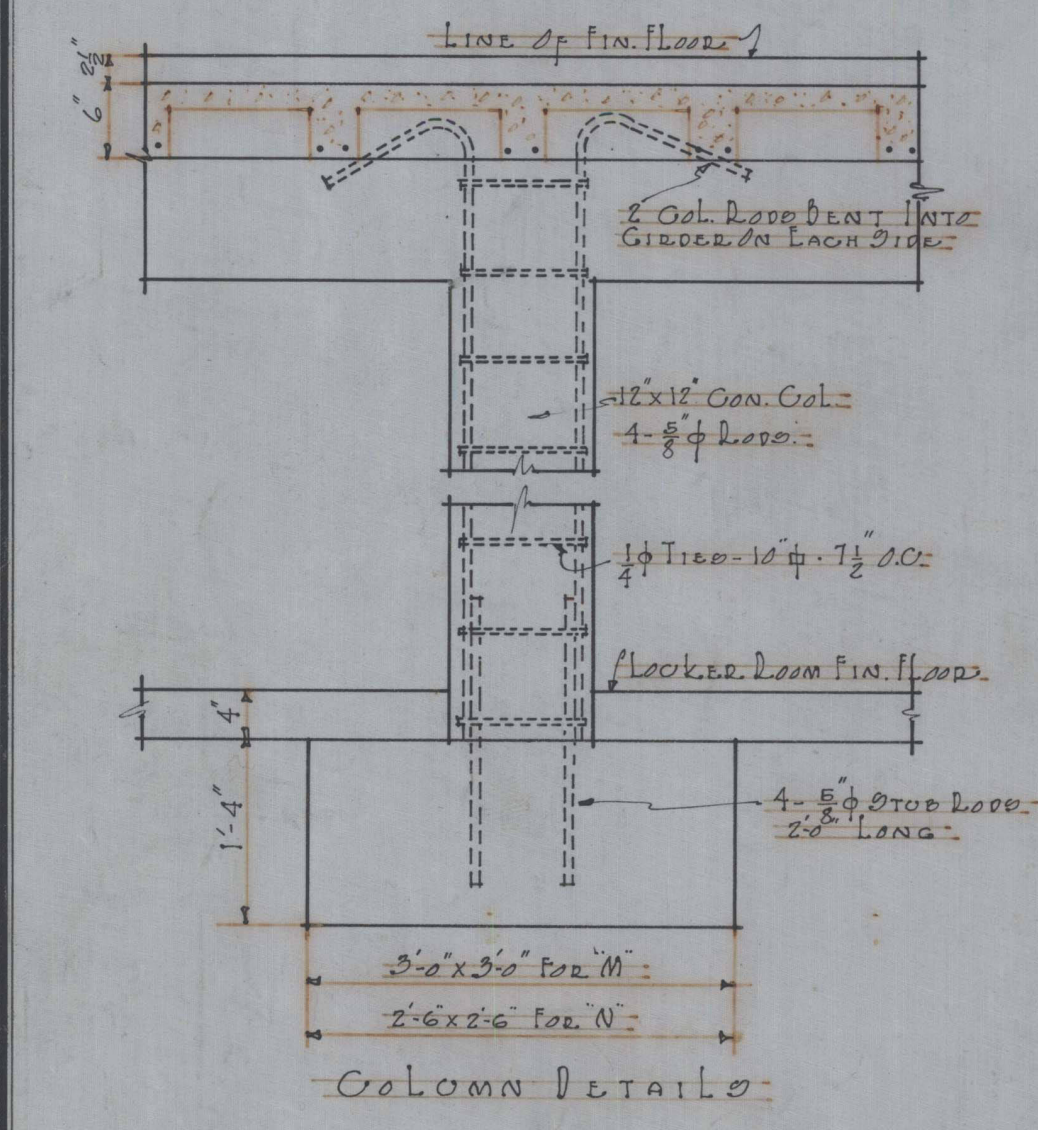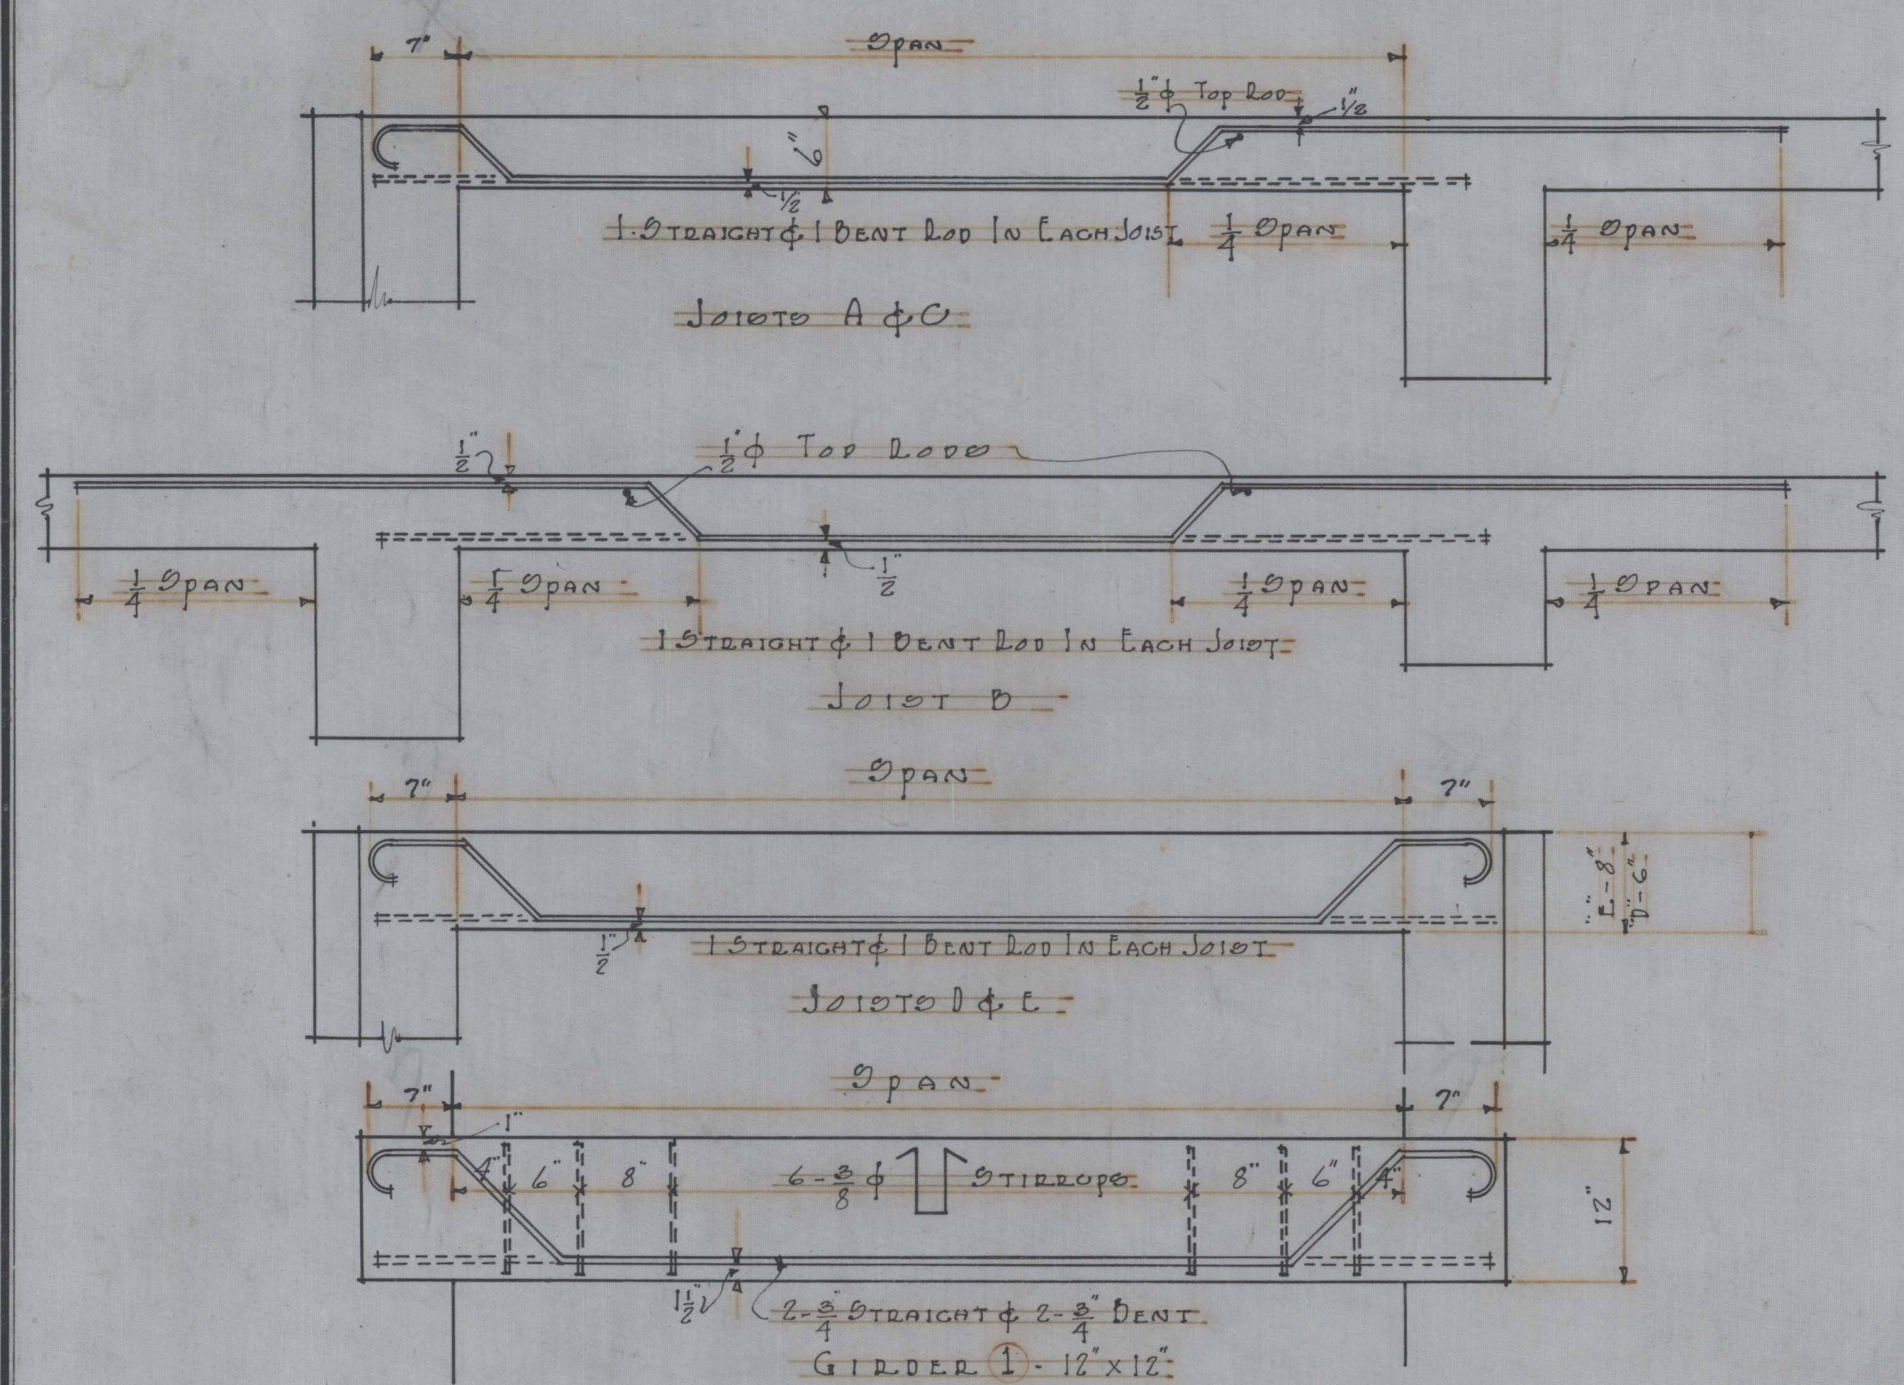


NOTE: EXCEPT FOR ANCHORS SHOWN:
LAP SPACING IN CONCRETE WALLS
TO BE AS SHOWN IN DETAIL 10, 11, 12, 13, 14
AND WITH SPACING OVER TOP
OF WALL TO FACE DETAIL 10, 11, 12, 13, 14
POLYMER PORTLAND CEMENT - 4 LBS PER
CUBIC FOOT OF CONCRETE


NOTE: BUILDING IS SYMMETRICAL ABOUT &
EXCEPT AS SHOWN

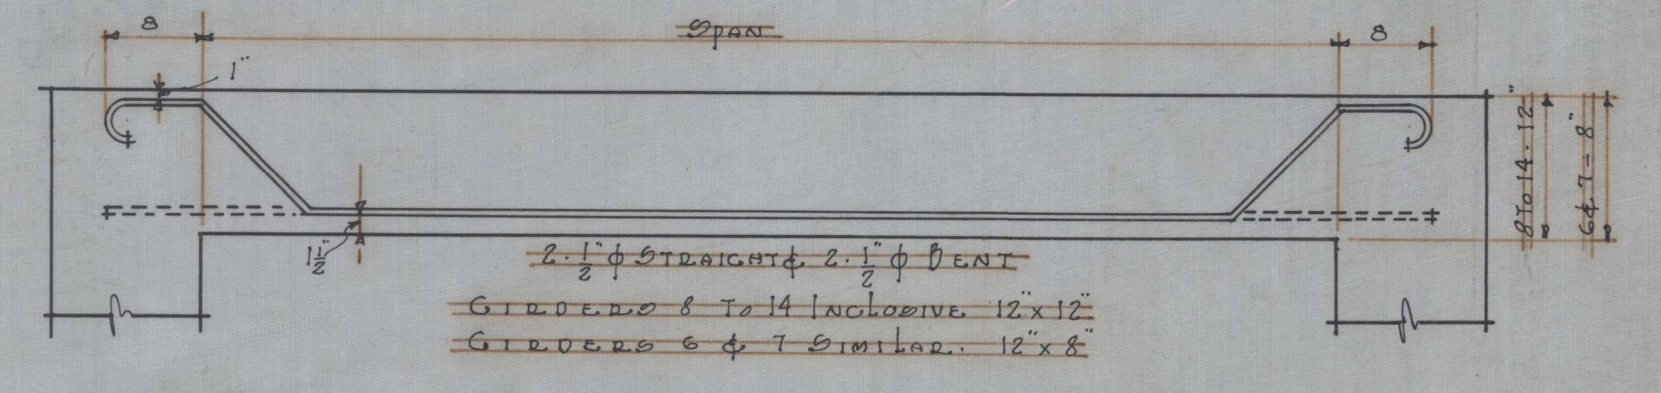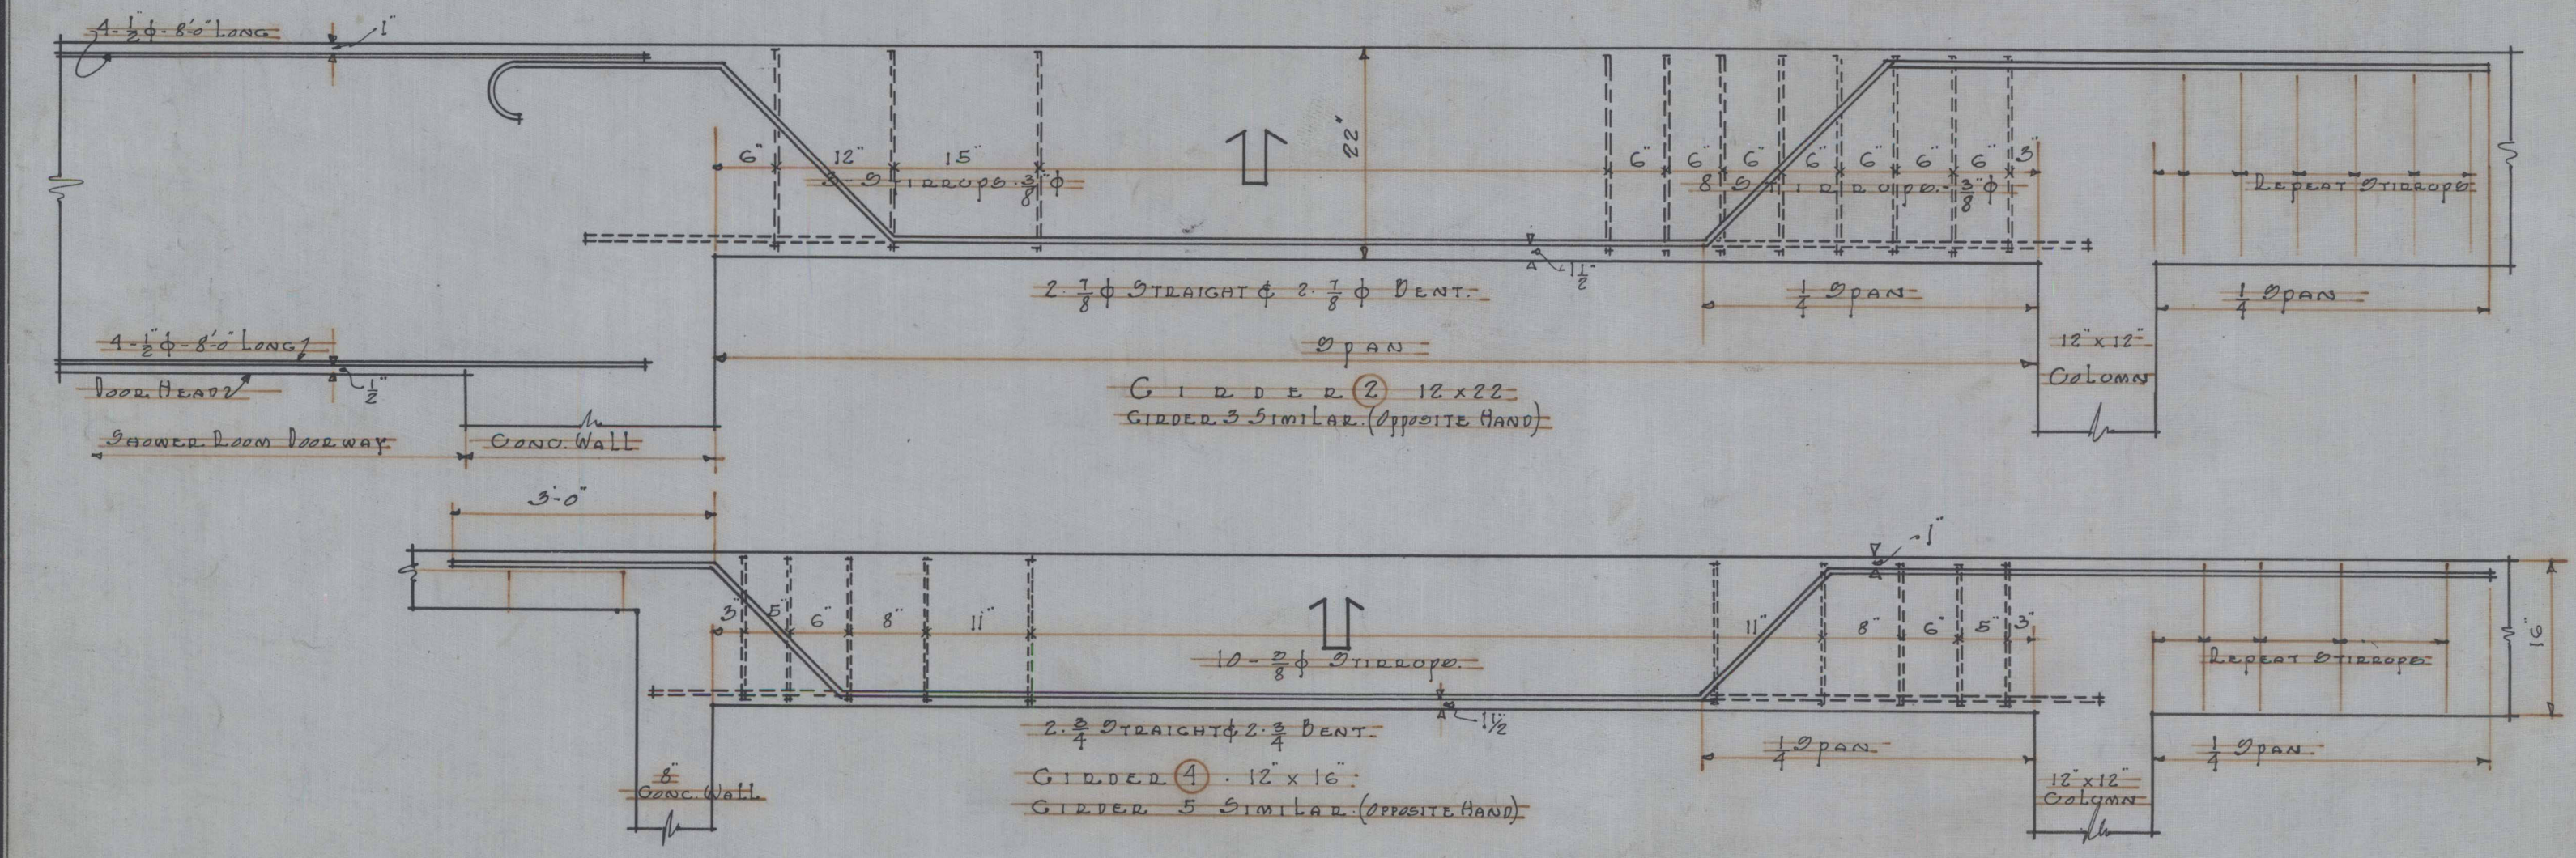




SCALE: VARIOUS	FRAMING PLANS & DETAILS	DATE: 12-1-24
BY: ROY	CLUB HOUSE	JOB NO. 890
BY: WDM	WILLIAM C. DEAR & PARTNERS	SHEET 10
JOHNSON MILLER MILLER & VEAGER, ARCHT. ENGRS. TERRE HAUTE, INDIANA		

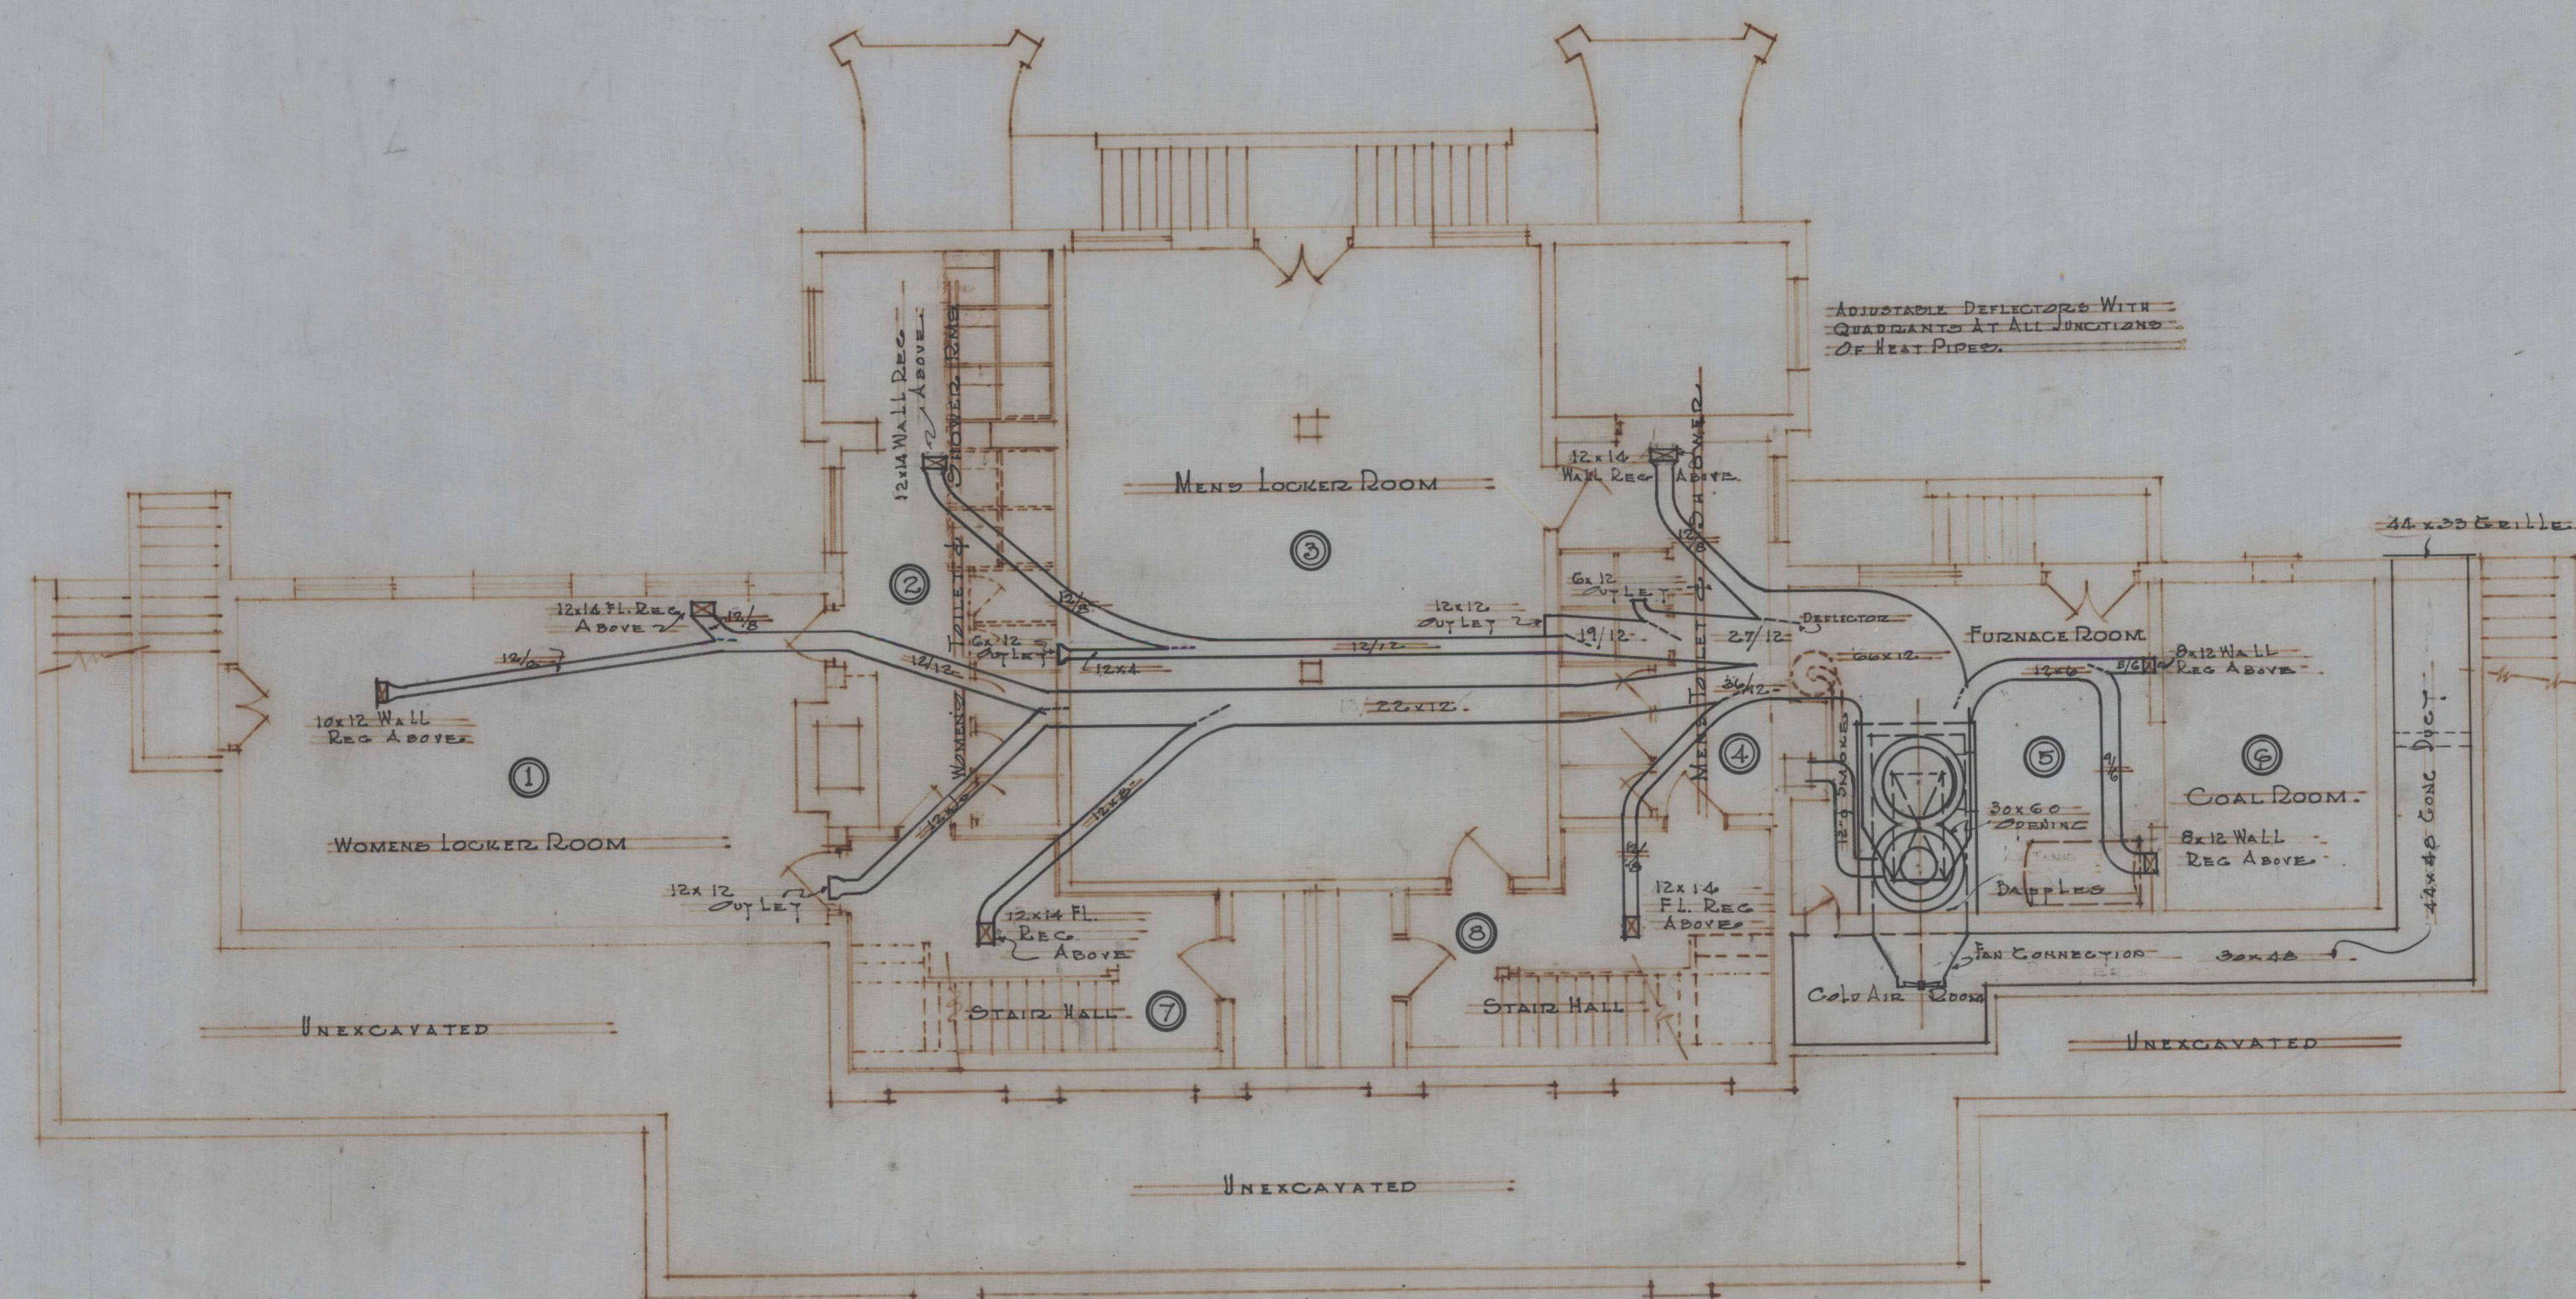

BASEMENT PLAN SHOWING LAYOUT OF WARM AIR PIPES.

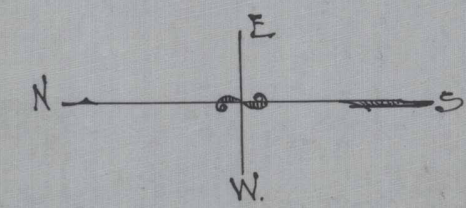


SCALE 1/8" = 1'-0"	HEATING PLAN	DATE 12-1-24
REC'D BY W.D.M. DEY	CLUB HOUSE WILLIAM S. DIA-PARK TENN. HAYTE	JOB No 930 SHEET II
JOHNSON MILLED, MILLED & VEACHER, ARCHITECTS TENN. HAYTE, INDIANA		

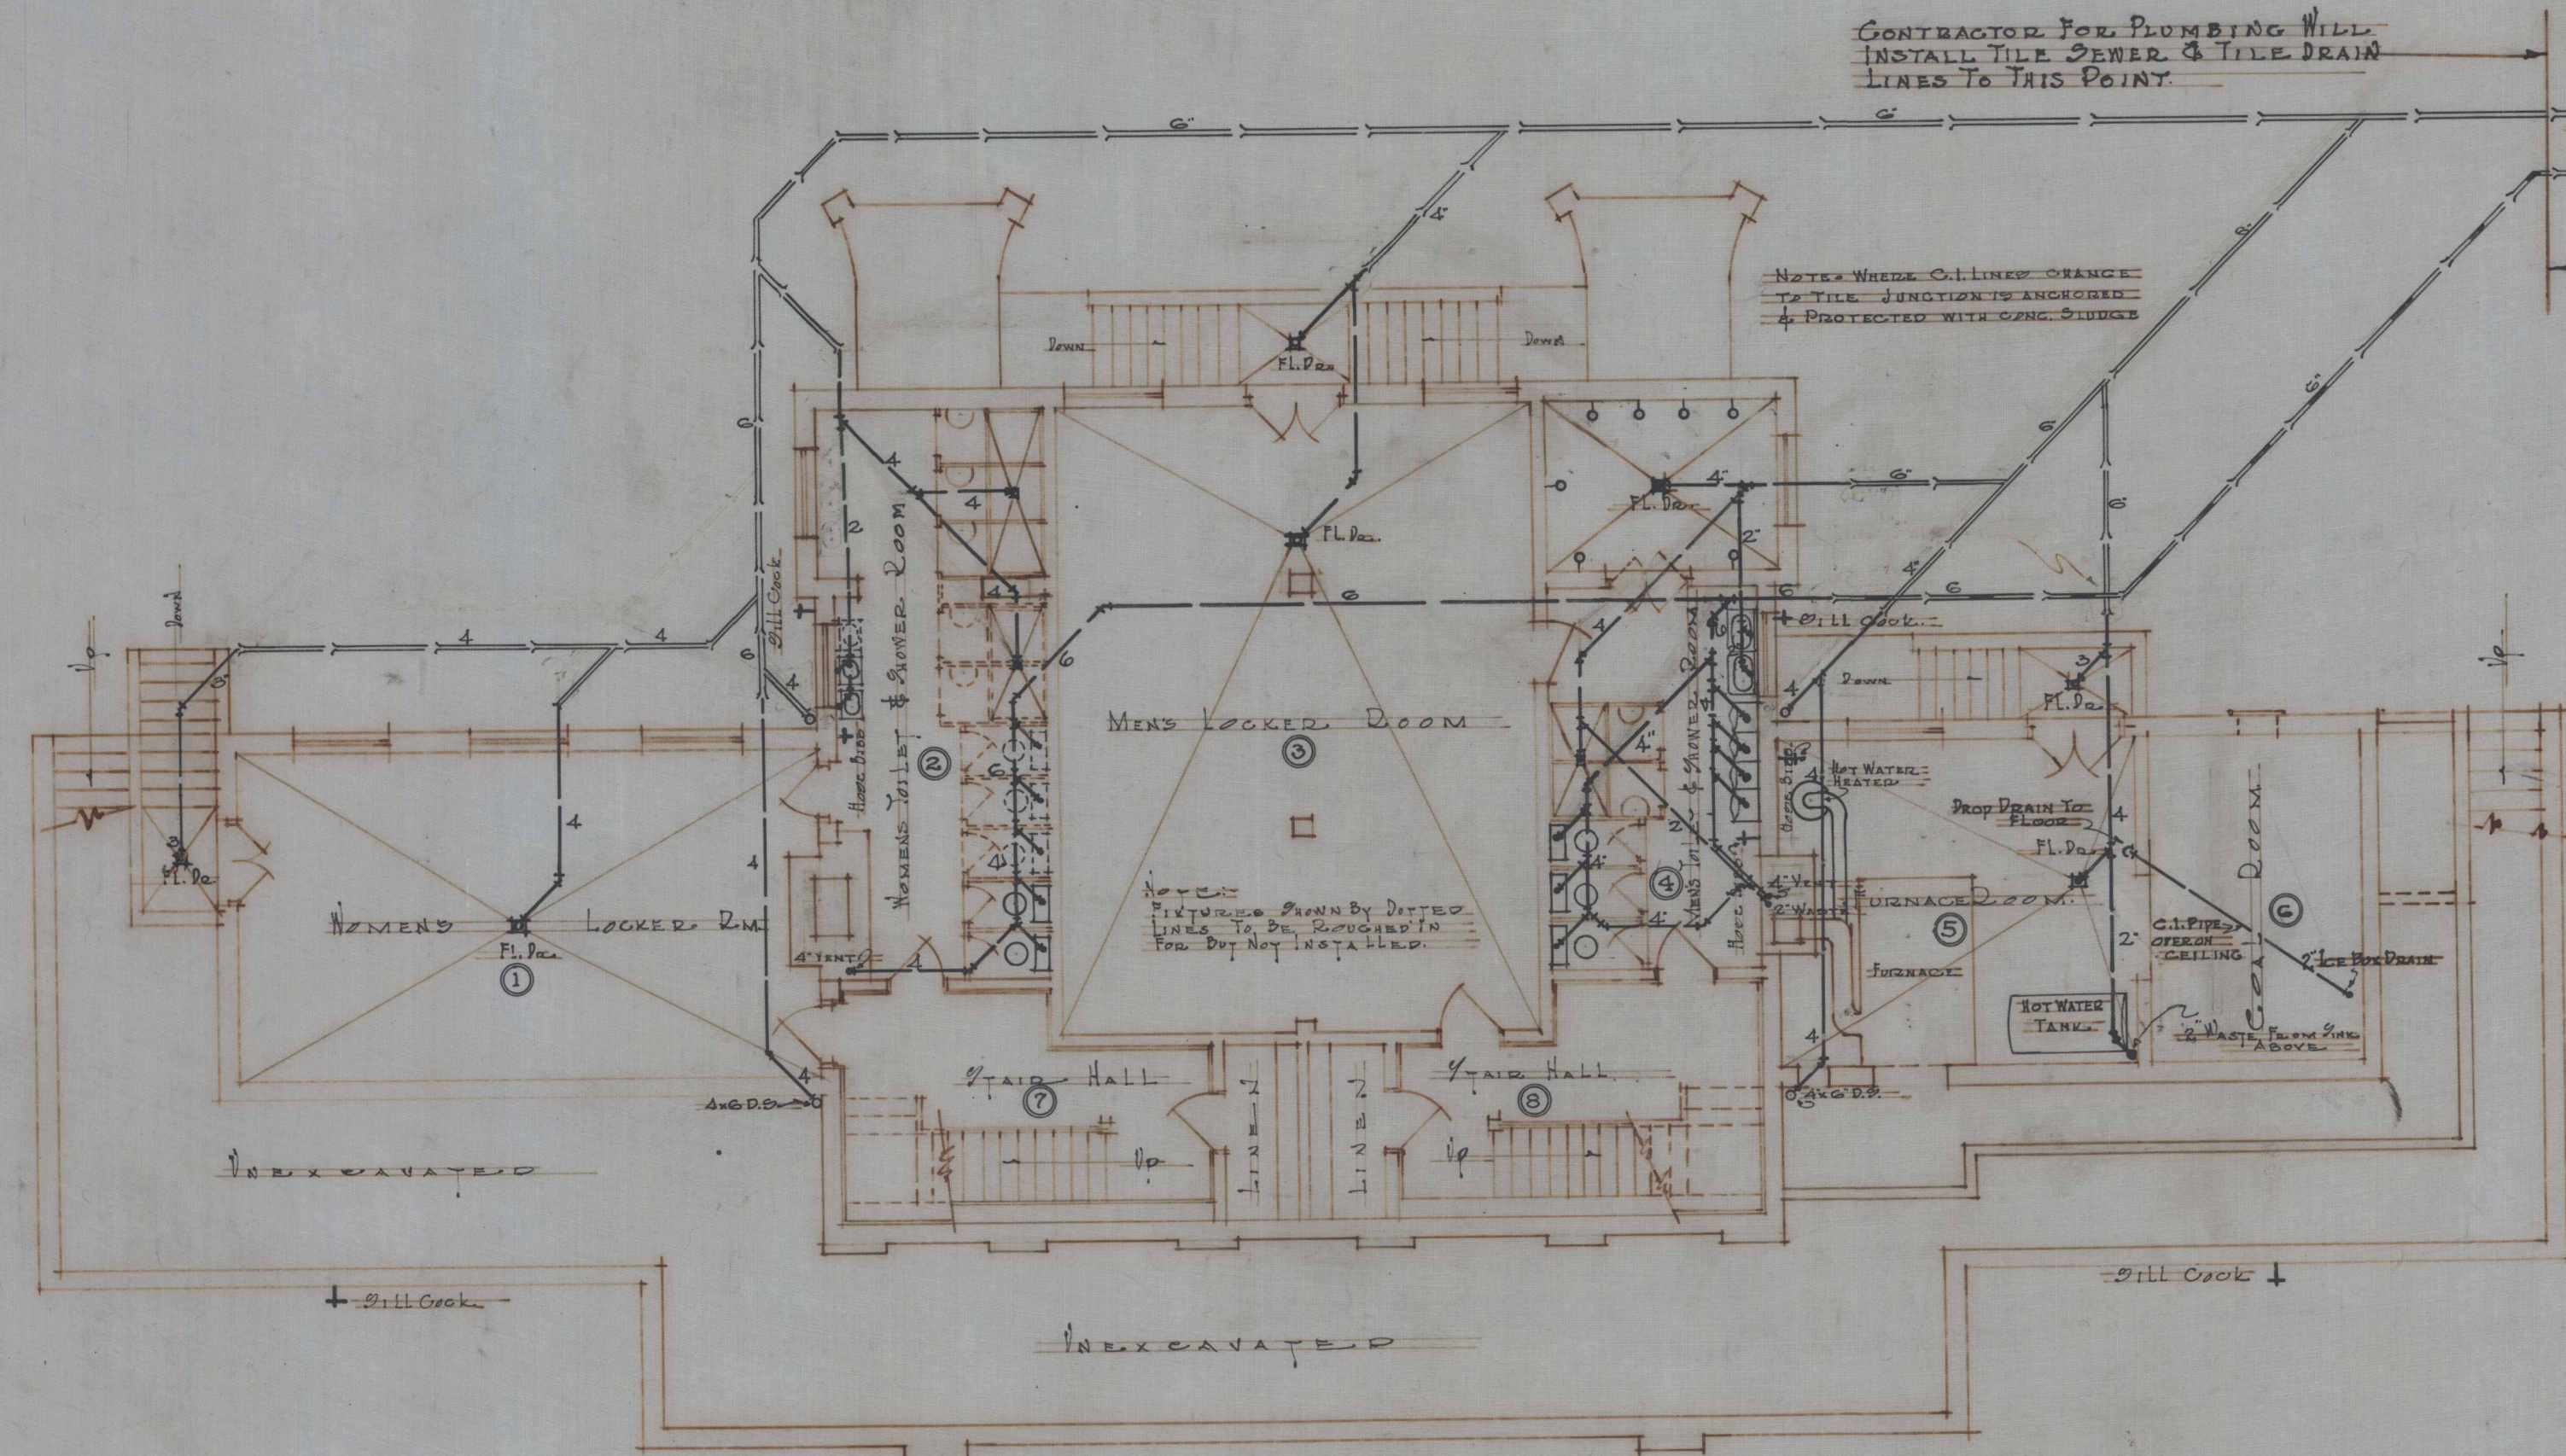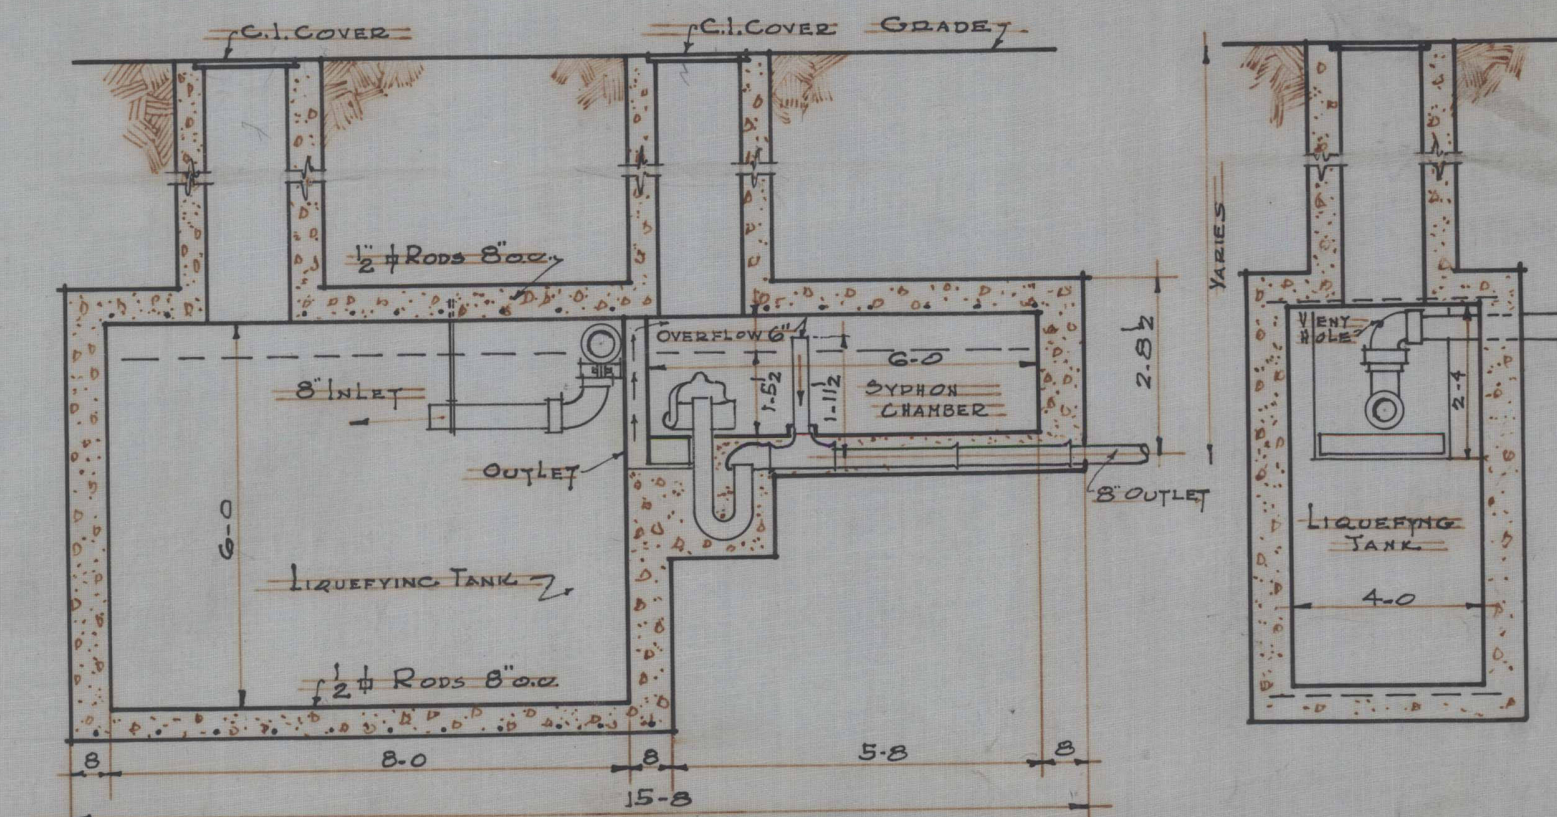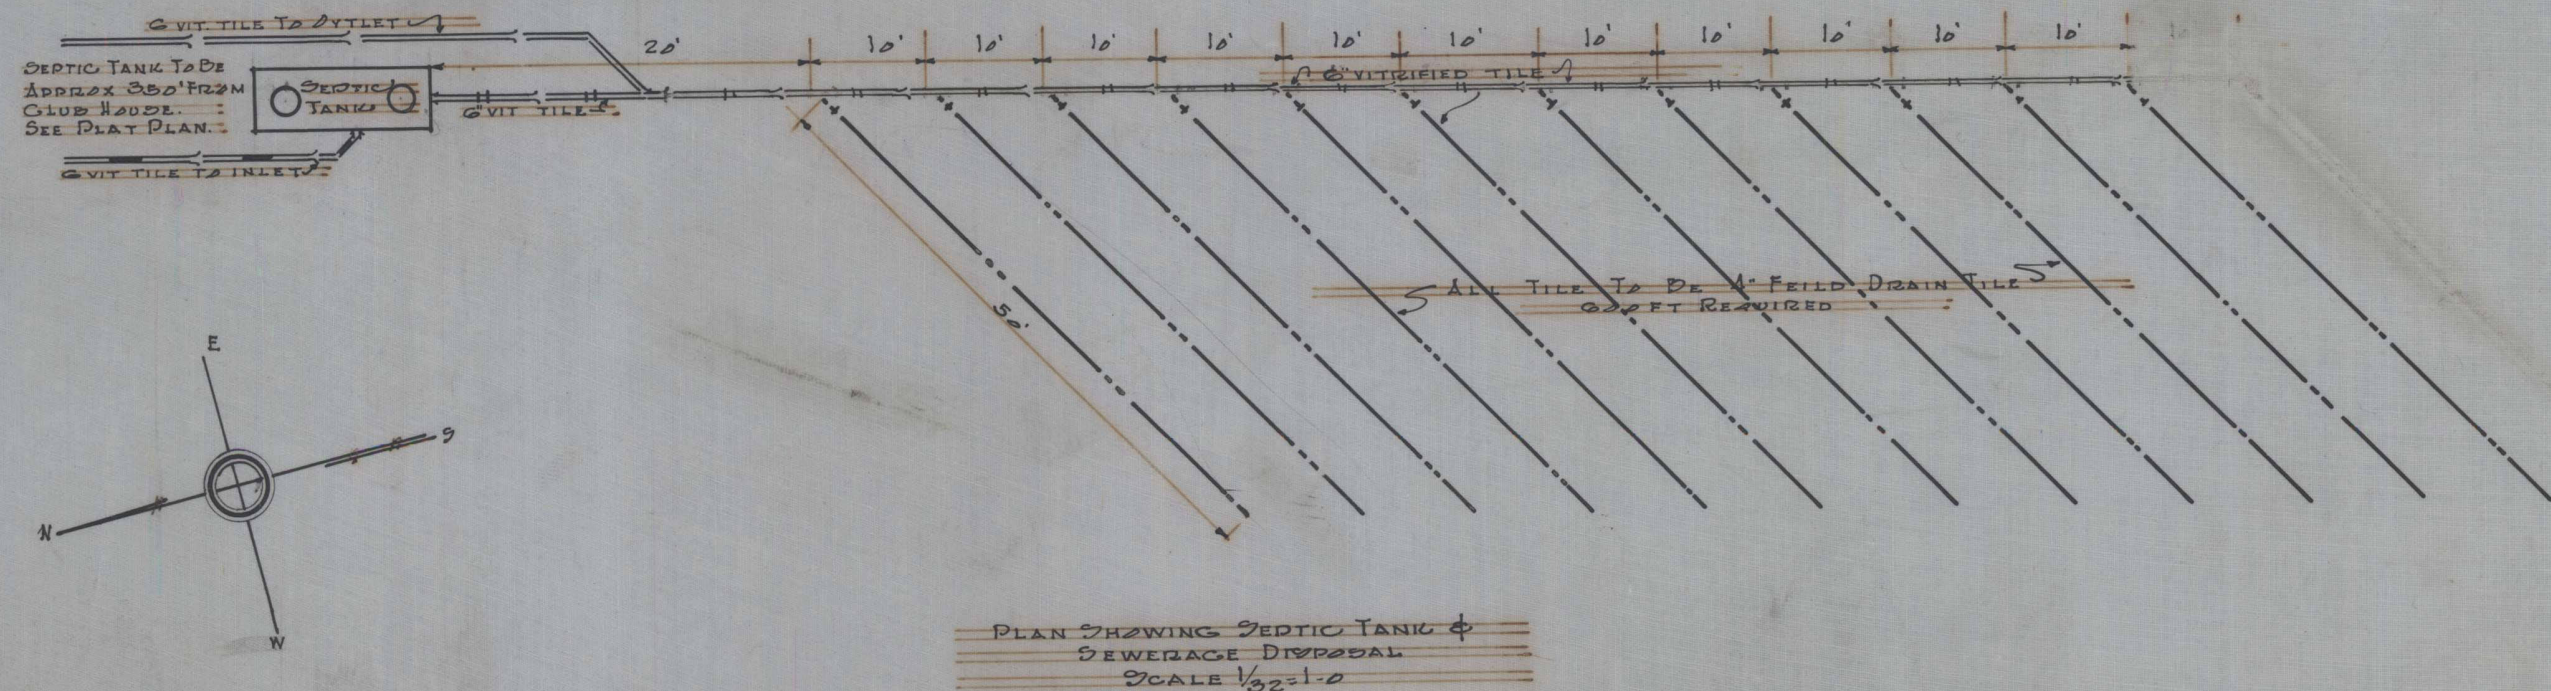

PIPE LEGEND

- Cast Iron ---
- Vitrified Tile ---
- Vitrified Tile to Septic Tank Inlet ---
- Vitrified Tile to Septic Tank Outlet ---
- Vitrified Tile to Disposal Field ---
- Field Drain Tile ---

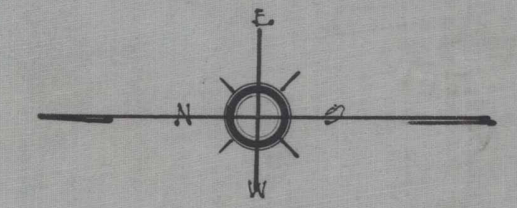

SCALE 1/8" = 1'-0"	PLUMBING	DATE 12-1-22
R.E. H.B.C.	CLVD HOVDE	SCHEM 800
R.Z.Y. W.D.M.	FOR WILLIAM S. DEA-PARK TERRE HAUTE	SHEET 12
JOHNSON MILLER MILLER & YEAGER, ARCHTS. TERRE HAUTE, INDIANA		